


PROPERTY LINE


PROPERTY LINE

KILDONAN DRIVE

NOTE:
EXISTING GATE CHAMBER DIMENSIONS
HAVE BEEN FIELD MEASURED WHERE
ACCESSIBLE BUT MAY VARY SLIGHTLY.
(NO EXISTING DRAWINGS ARE AVAILABLE)

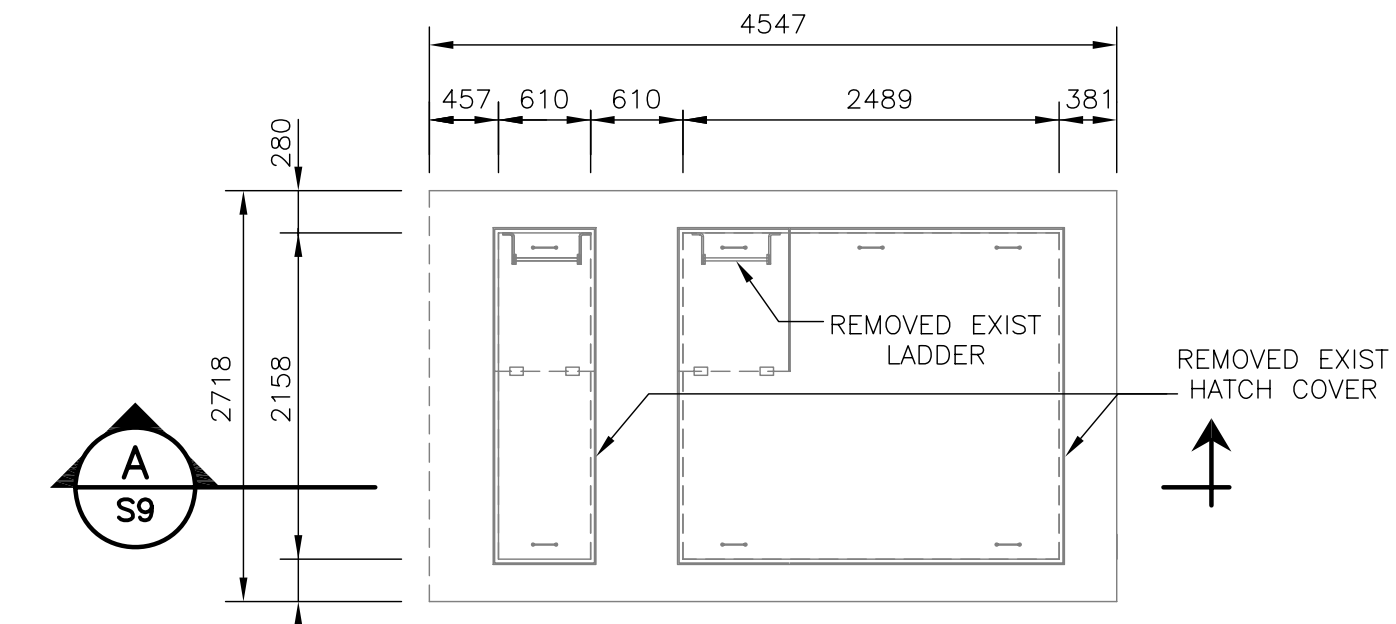

PLAN - EXISTING CHAMBER
TOP LEVEL
SCALE: 1:50

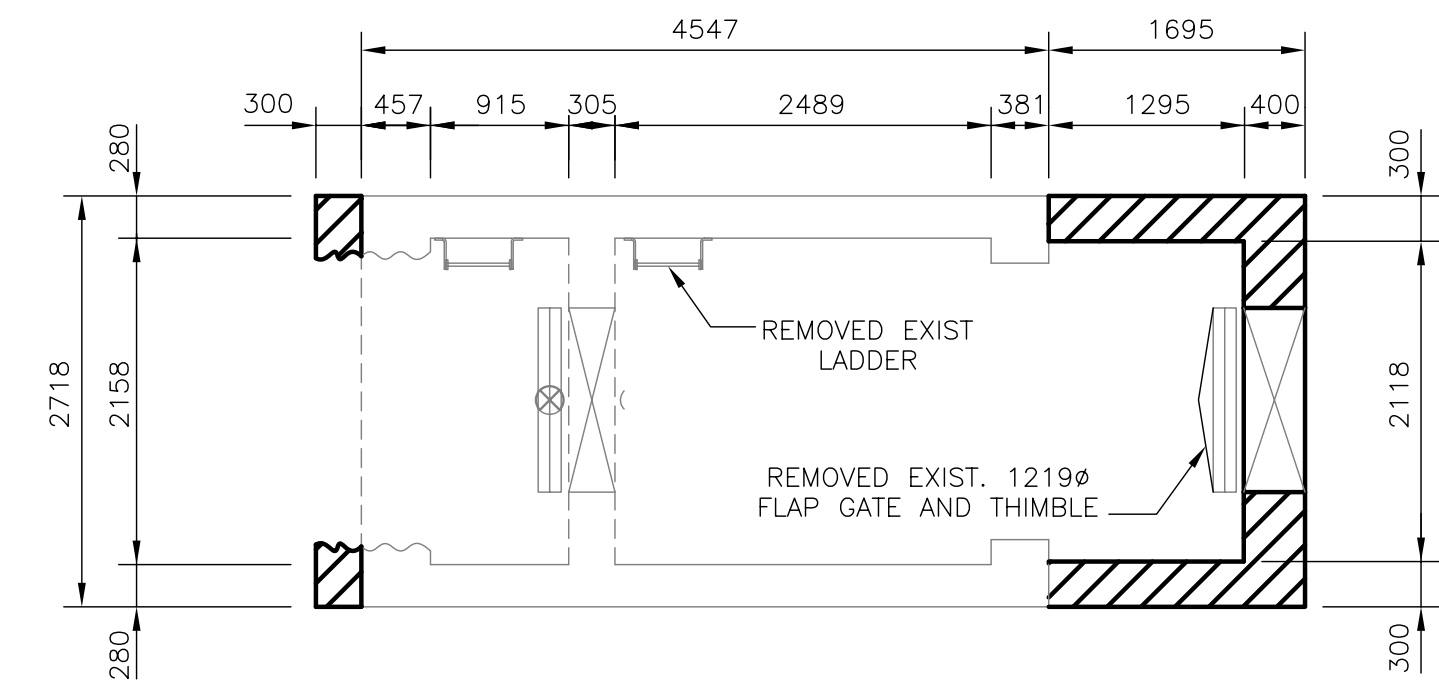

PLAN - EXISTING CHAMBER
BOTTOM LEVEL
SCALE: 1:50

LEGEND:

 WALL DEMOLISHED

METRIC


WHOLE NUMBERS INDICATE MILLIMETRES
DECIMALIZED NUMBERS INDICATE METRES



SCALE: 1:250 METRIC A1
1:500 METRIC A3

AS-CONSTRUCTED
WATER & WASTE DEPARTMENT

PROJECT COMPLETION DATE : 20 JULY 06

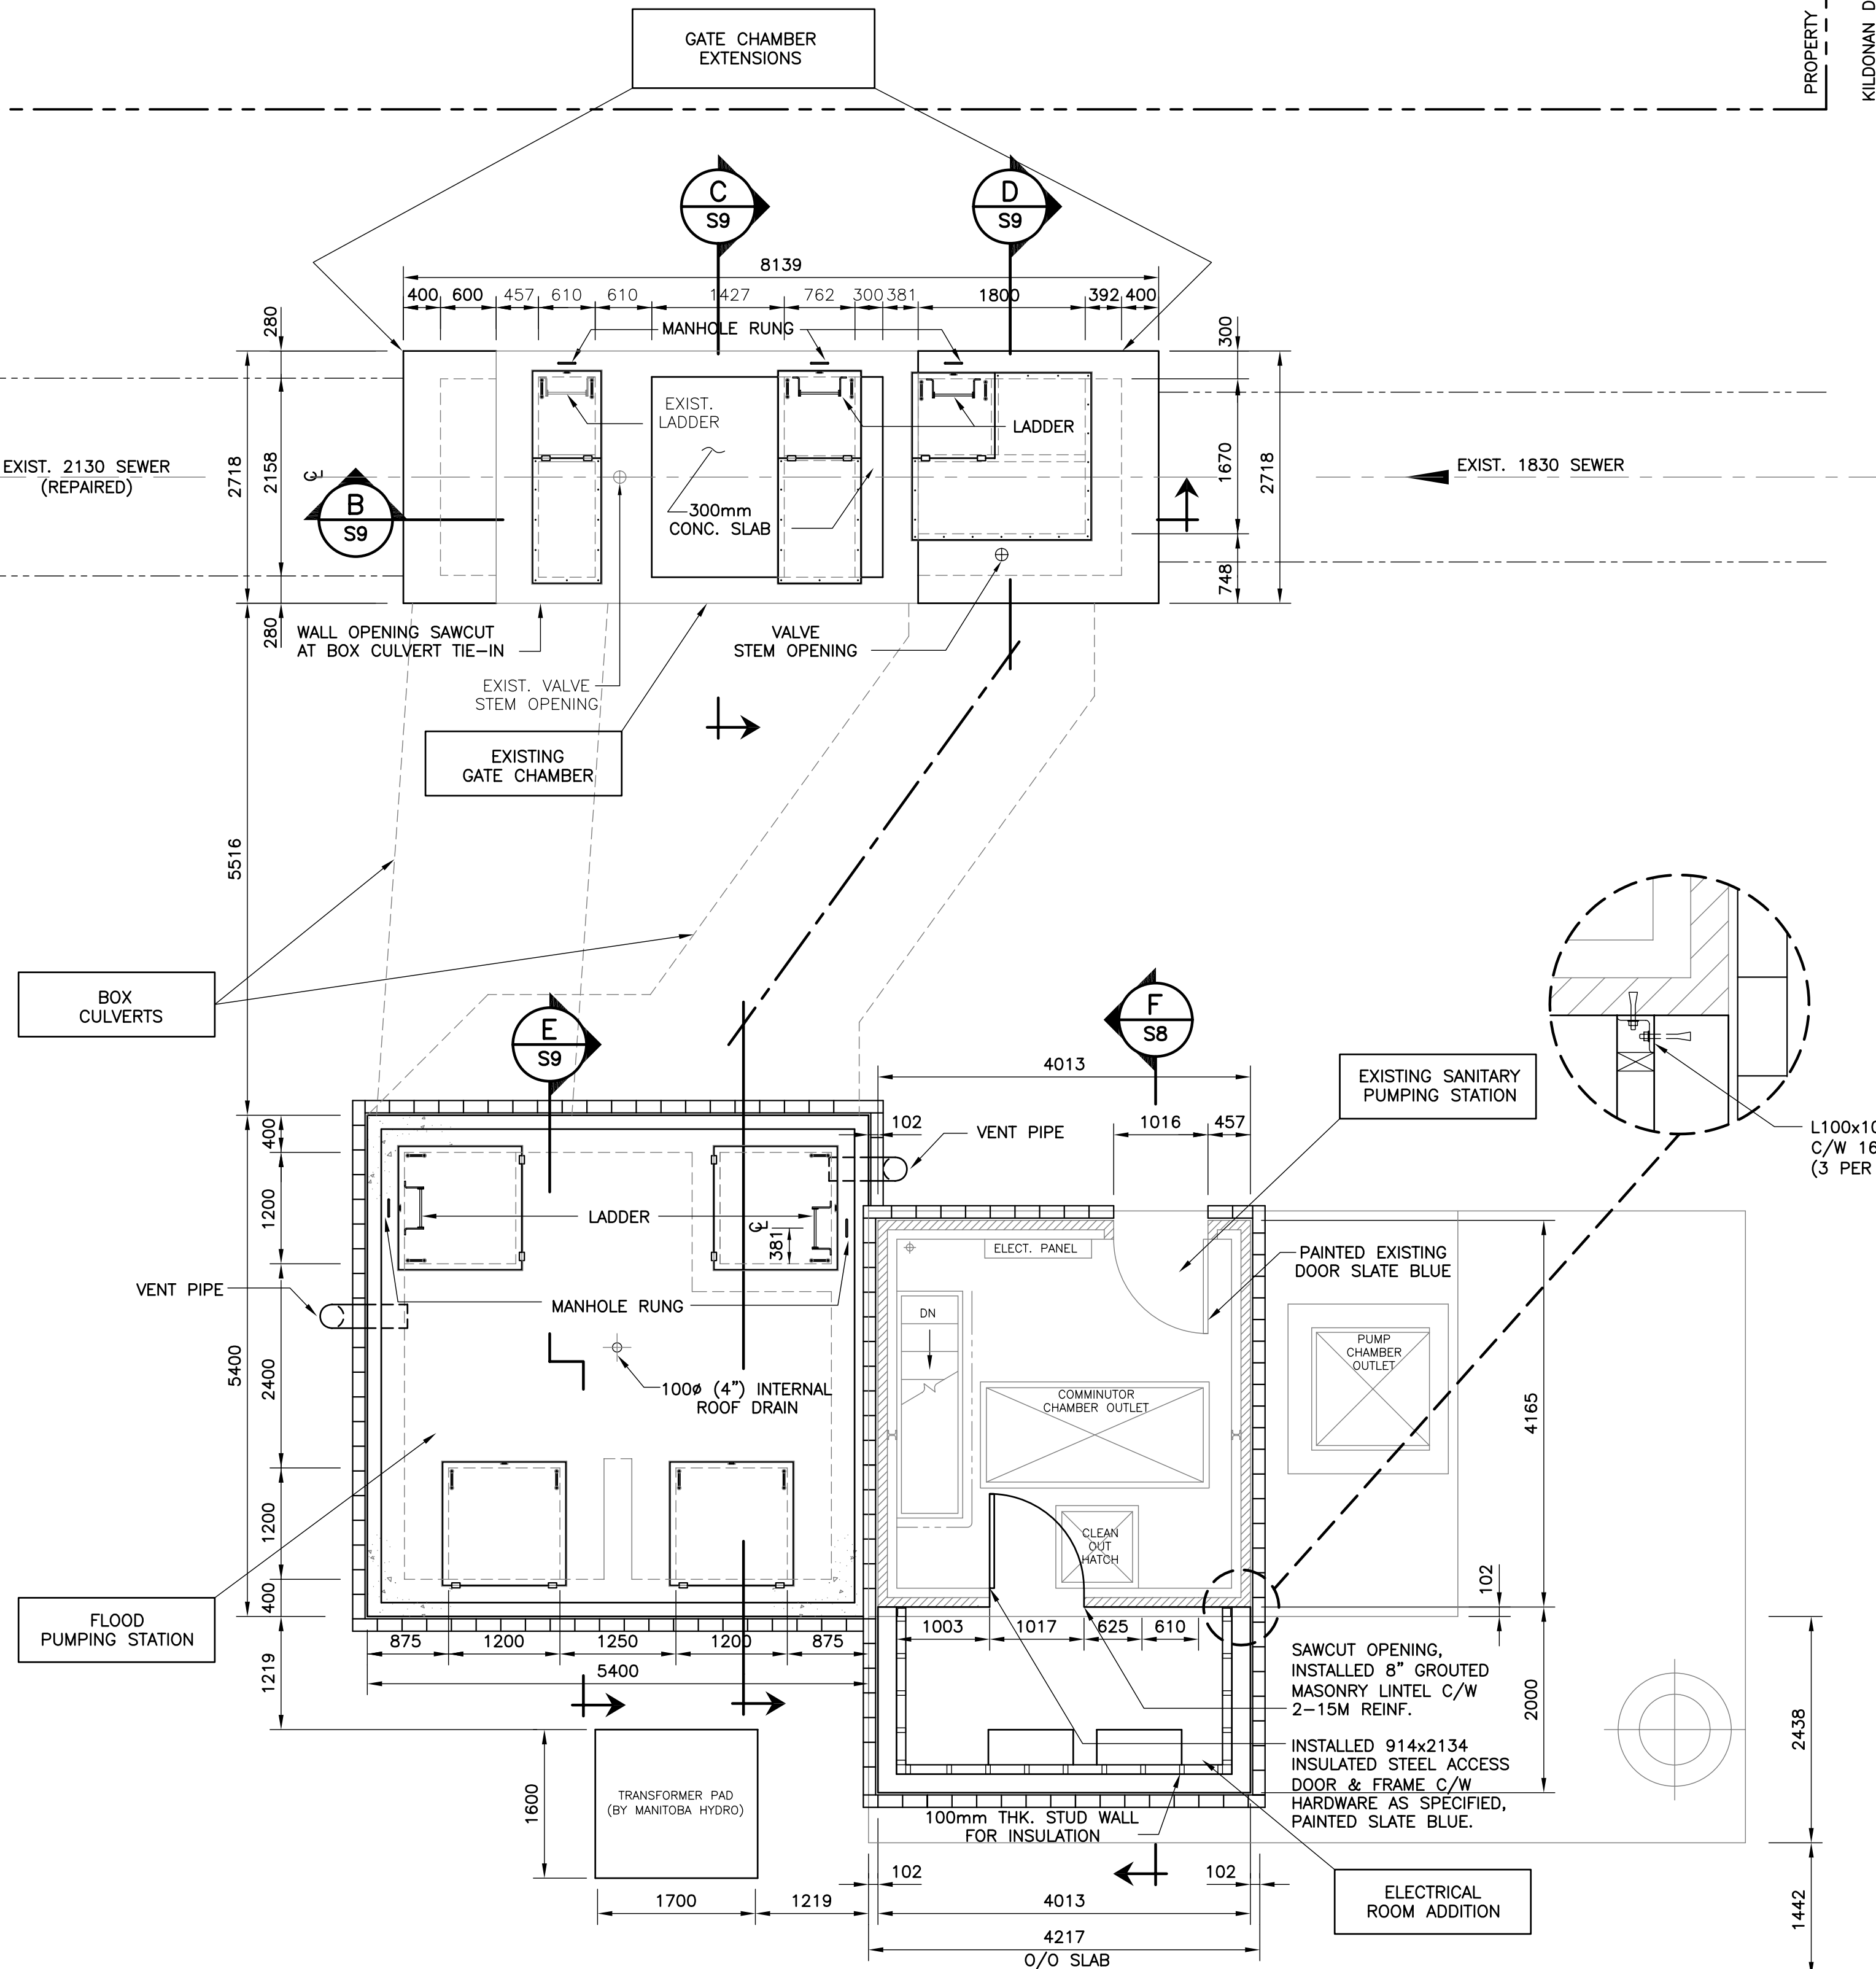

1 SITE PLAN
SCALE: 1:50

COWLEGGEND



| | | | | | |
|-------|-------------------------|----------|-----|------|----------|
| B.M. | XX-XXX | | | | |
| ELEV. | XXX.XXX | | | | |
| 1 | AS-CONSTRUCTED | 06/12/13 | CMS | | |
| 0 | ISSUED FOR CONSTRUCTION | 05/12/07 | CMS | | |
| NO. | REVISIONS | DATE | BY | DATE | 05/11/08 |

KGS GROUP
CONSULTING ENGINEERS & PROJECT MANAGERS
WINNIPEG (204) 896-1209
THUNDER BAY (807) 345-2233

| | | | |
|-------------|----------|----------------------------|-----|
| DESIGNED BY | CMS | CHECKED BY | CMS |
| DRAWN BY | EdC | APPROVED BY | |
| SCALE: | AS NOTED | RELEASED FOR CONSTRUCTION: | |

ENGINEER'S SEAL
ORIGINAL DRAWING SIGNED BY:
C.M. SIEPMAN
12/02/07
DD/MM/YY
CONSULTANT DRAWING NO.
05-0107-13-07

THE CITY OF WINNIPEG
WATER & WASTE DEPARTMENT

**HAWTHORNE FLOOD PUMPING STATION
UPGRADE**
**STRUCTURAL
GENERAL ARRANGEMENT**

SHEET 07 OF 24
CAD FILE DRAWING NUMBER
05-0107-13-07
CITY DRAWING NUMBER
LD-3244