


**GENERAL NOTES**

- A. ALL ABANDONED EQUIPMENT AND SERVICES WITHIN AREA OF WORK SHALL BE REMOVED.
- B. THIS BUILDING MAY CONTAIN ASBESTOS. REFER TO FRONT END SPECIFICATIONS FOR FURTHER INFORMATION.
- C. REFER TO ROOF DETAILS AND SPECIFICATIONS FOR ALL NEW AND CAPPED OPENINGS.

**DEMOLITION KEY NOTES**

- 1. DEMOLISH AND REMOVE NATURAL GAS PIPING AND VENT BACK TO ISOLATION VALVE AS SHOWN. REPAIR AND SEAL PRV VENT ROOF OPENING. REFER TO STRUCTURAL AND ROOFING SPECIFICATIONS (DETAILS).
- 2. REMOVE EXISTING INFRARED HEATERS AND ASSOCIATED CONTROLLER AND THERMOSTAT.
- 3. EXISTING INFRARED HEATER TO REMAIN.
- 4. REMOVE NATURAL GAS LINE SERVING MUA-14. REFER TO DRAWING M1.1 KEYNOTE 3 FOR CONTINUATION.

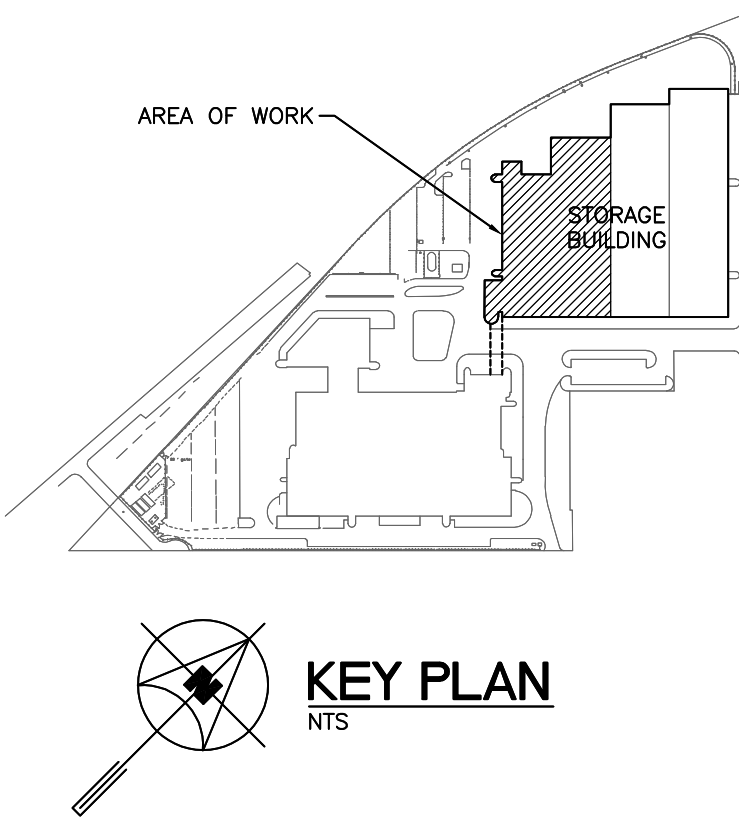

**1 MAIN FLOOR PLAN - SERVICE BAY, B-SECTION, TRACK 1-12 - DEMOLITION - PLUMBING**  
 SCALE: 1/8" = 1'-0"

NO.	Description	BY	DATE
1	ISSUED FOR ADDENDUM 3	JH	08/12/18
0	ISSUED FOR CONSTRUCTION	JH	08/11/18

**ENGINEERS  
 GEOSCIENTISTS  
 MANITOBA**  
 Certificate of Authorization  
**SMS Engineering Ltd.**  
 No. 166

OFFICIAL  
 CONTRACT DRAWING  
 BOUND AND SEALED BY  
 J.T. HOPKOCKS, P. ENG  
 NOVEMBER 9, 2018

770 Bradford Street  
 Winnipeg, Canada  
 T 204 775 0291  
 SMSeng.com

**SMS  
 ENGINEERING**

Project Title  
**CITY OF WINNIPEG FORT ROUGE  
 TRANSIT BASE - STORAGE TRACK  
 13-24 - MECHANICAL UPGRADE**

WINNIPEG MANITOBA  
**MAIN FLOOR - SERVICE BAY,  
 B-SECTION, TRACK 1-12 -  
 DEMOLITION - PLUMBING**

Drawn By	Checked By	Approved By
AS/AS	XZ	JH
Scale	Date	Project No.
AS NOTED	NOVEMBER, 2018	18-246-01
Revision Number	Drawing Number	Sheet Order
1	M1.2	2 OF 12