




**UPS ROOM PLAN**  
SCALE: N.T.S.

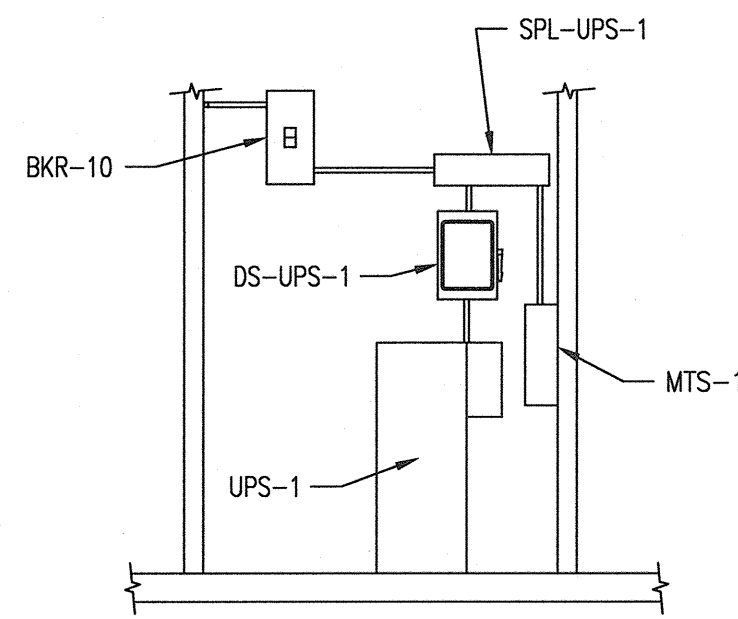

**SECTION A**  
SCALE: N.T.S.

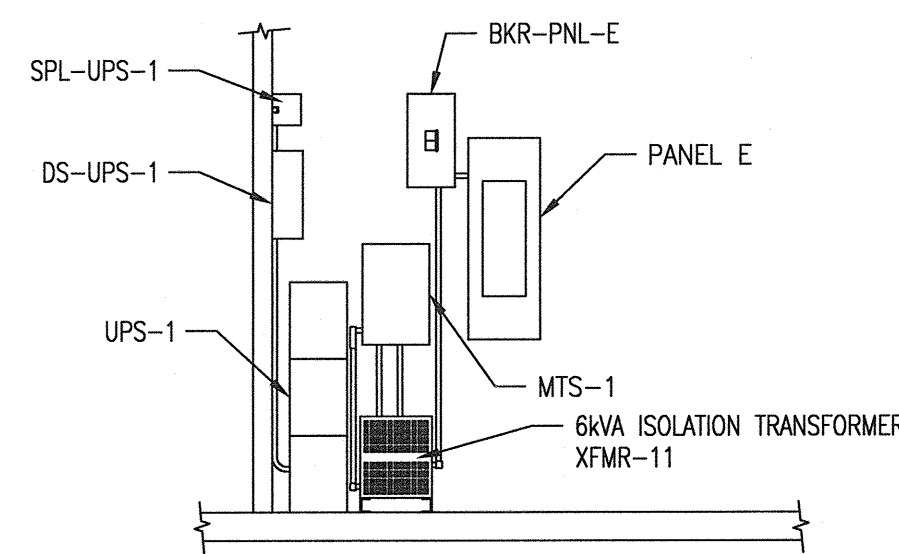

**SECTION B**  
SCALE: N.T.S.

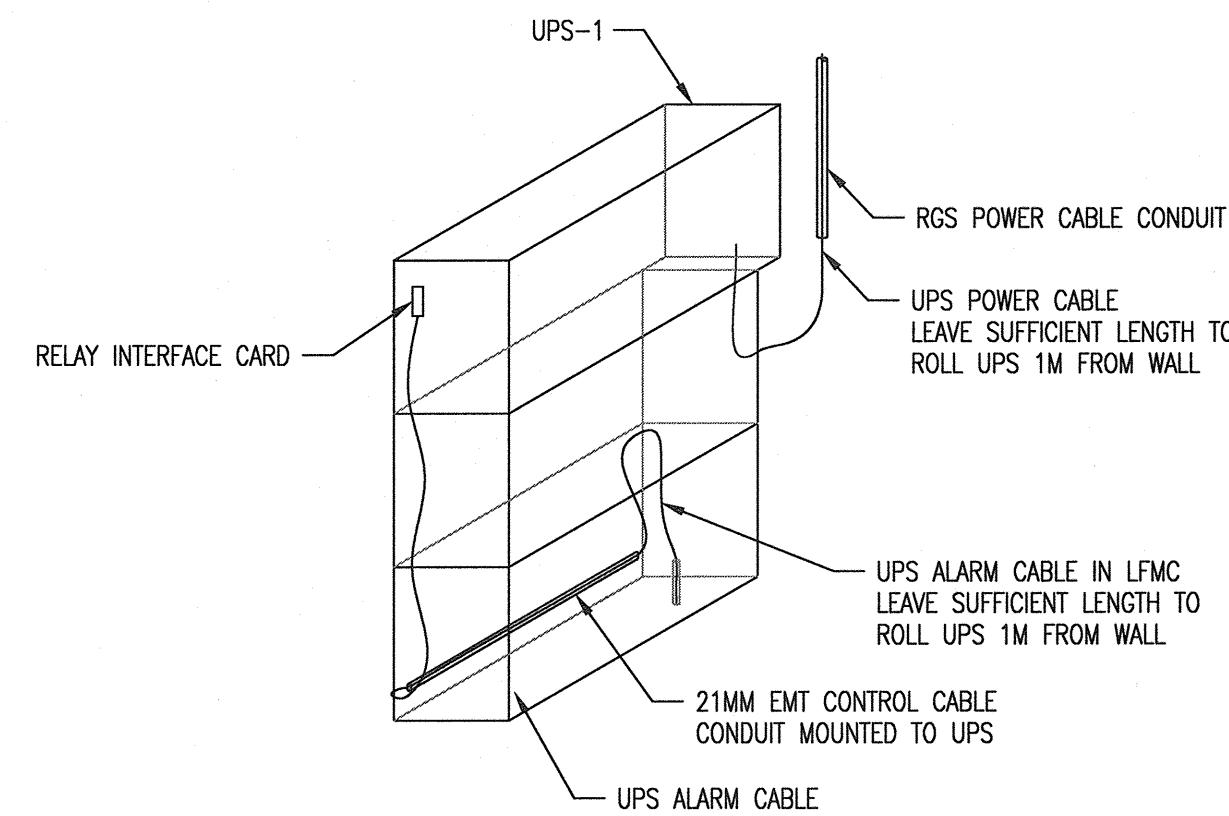

**DETAIL 1**  
SCALE: N.T.S.

**LEGEND:**

- EXISTING
- - - DEMOLITION

**DEMOLITION NOTES:**

- (A) PROVIDE DEMOLITION OF EXISTING CONDUIT AND CABLING FROM FDS-M10 TO FDS-XFMR-M10.
- (B) PROVIDE DEMOLITION OF EXISTING FDS-XFMR-M10.
- (C) PROVIDE DEMOLITION OF EXISTING CONDUIT AND CABLING FROM FDS-XFMR-M10 TO XFMR-M10.


**CONSTRUCTION NOTES:**

- (1) PROVIDE AND INSTALL NEW CABLE AND CONDUIT FROM NEW MCC-M710 TO EXISTING XFMR-M10. REFER TO NEW SINGLE LINE DRAWING 1-0660M-E007 FOR NEW CABLE AND CONDUIT SIZES. UPDATE THIS DRAWING TO SHOW NEW CABLE AND CONDUIT TO XFMR-M10 ON AS BUILT DRAWING.


**NOTES:**

- 1. CLOUDED PORTION OF THIS DRAWING INDICATES WORK TO BE COMPLETED - EITHER REMOVALS OR ADDITIONS AS INDICATED. REFER TO DEMOLITION AND CONSTRUCTION NOTES.

LEGEND	
LFMC	LIQUID TIGHT FLEXIBLE METAL CONDUIT
RGS	RIGID GALVANIZED STEEL CONDUIT

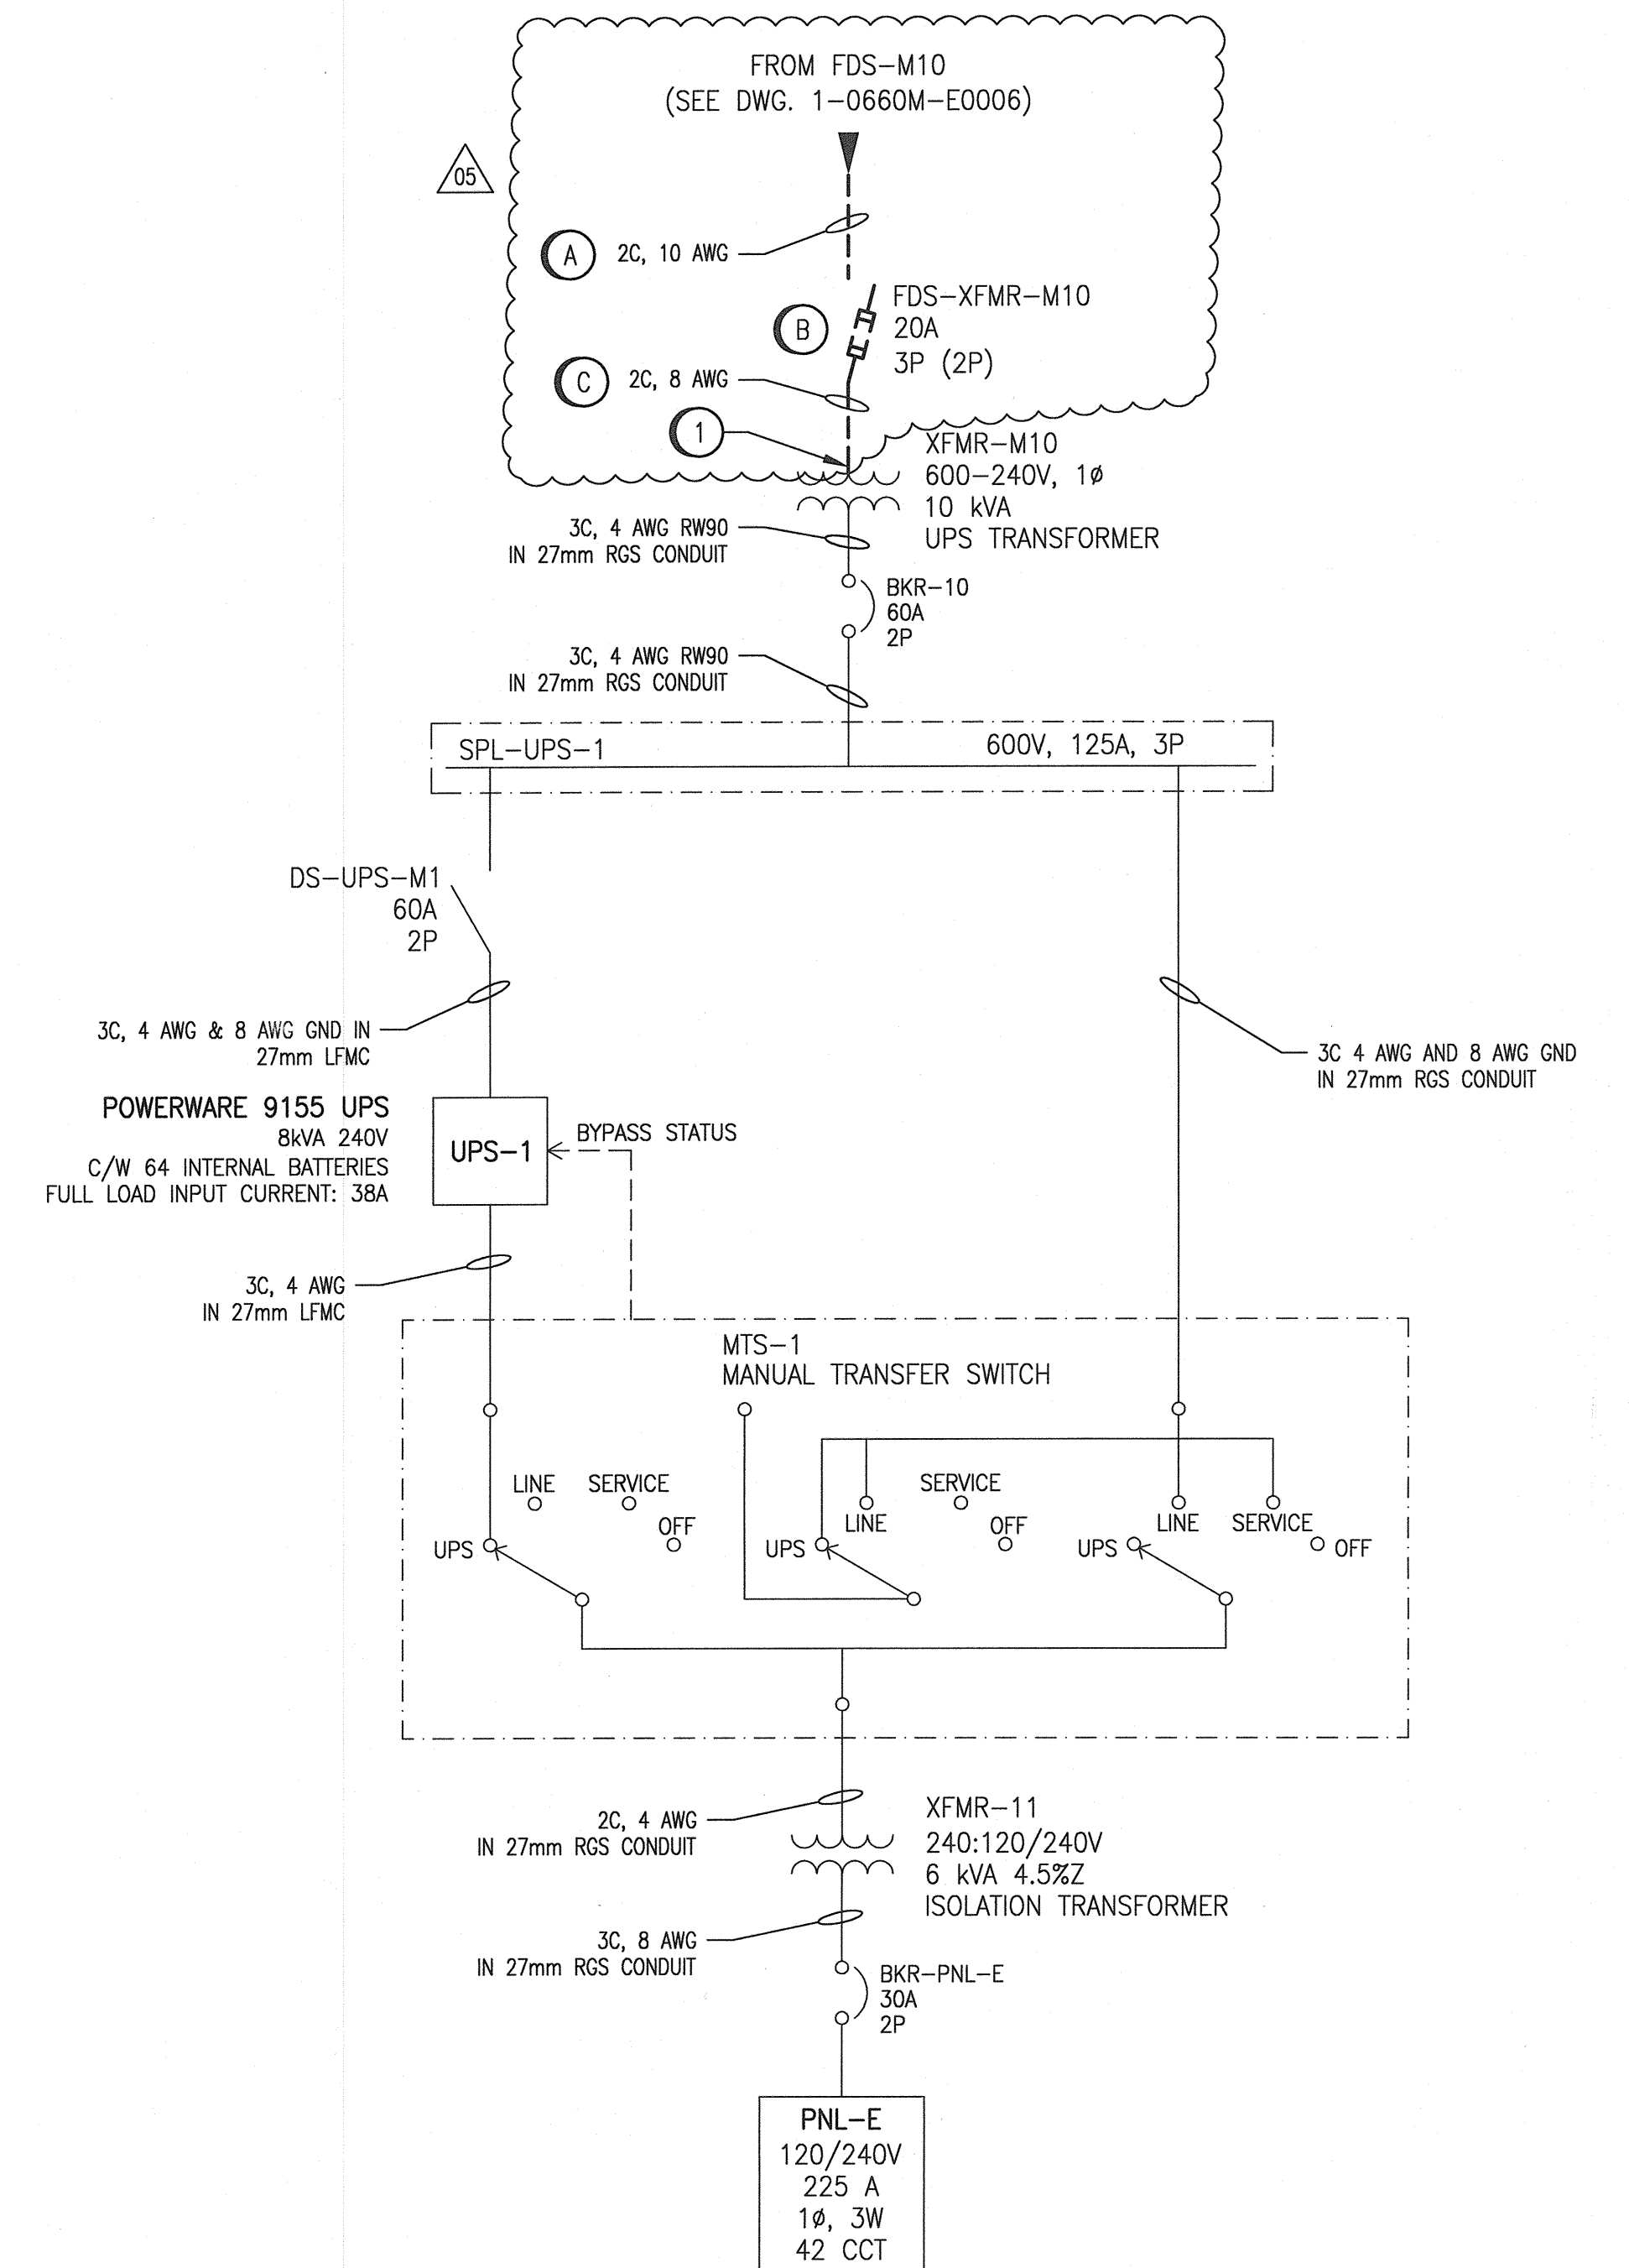


1-0660M-E0007	ELECTRICAL SINGLE LINE DIAGRAM, MCC-M710
1-0660M-E0006	ELECTRICAL SINGLE LINE DIAGRAM, DEMOLITION
DRAWING NUMBER	REFERENCE DRAWINGS

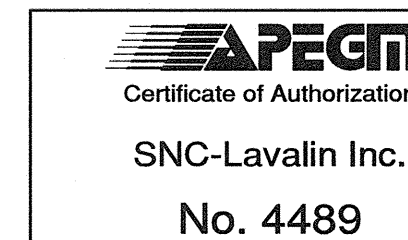

NO.	REVISIONS	DATE	DESIGN	CHECK
05	ISSUED FOR TENDER AND CONSTRUCTION	2019/10/18	SB	BC
04	ISSUED FOR CITY USE	2011/07/13	BC	CJR
03	AS-BUILT	2008/11/24	AEO	-
02	ISSUED FOR CONSTRUCTION	2008/05/13	DC	-
01	REMOVED SUPPLY OF UPS FROM NOTES	2008/02/22	YOM	-
00	ISSUED FOR TENDER	2008/01/08	AEO	-

**SNC-LAVALIN INC.**  
148 Nature Park Way  
Winnipeg, MB, Canada R3P 0X7  
204-786-8080

DESIGNED BY: C. REIMER  
CHECKED BY: C. REIMER  
DRAWN BY: A. OLIVER  
APPROVED BY: C. REIMER  
SCALE: NTS  
ISSUED FOR CONSTRUCTION BY: A. WEISS  
DATE: 2007/07/05  
DATE: 2019/10/18  
CONSULTANT NO.:

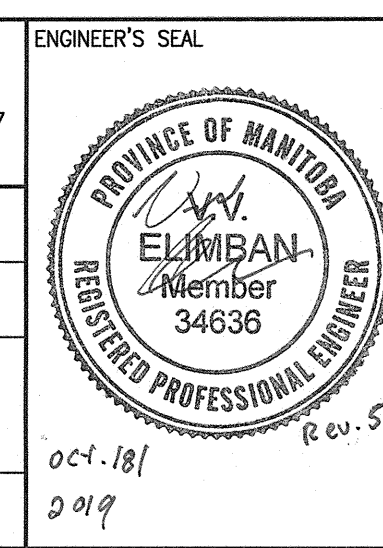

**THE CITY OF WINNIPEG**  
WATER AND WASTE DEPARTMENT

TACHE BOOSTER PUMPING STATION  
SINGLE LINE DIAGRAM & LAYOUT  
UPS

CITY DRAWING NUMBER: 1-0660M-E0002  
SHEET: 001  
REV: 05  
SIZE: A1