


FIRE ALARM DEVICE SYMBOLS	
SYMBOL	DEVICE
	SMOKE DETECTOR
	HEAT DETECTOR - FIXED TEMP
	HEAT DETECTOR - RATE OF RISE
	MANUAL PULL STATION
	ALARM HORN W/STROBE LIGHT
	ALARM STROBE LIGHT (WALL MOUNTED)
	END OF LINE DEVICE

FIRE ALARM DEVICE TYPE MODIFIERS/NOTES	
STROBE LIGHTS	
	75cd
	50cd
ON DEVICES THAT ARE USER-SETTABLE, LIGHT OUTPUT IS INDICATED BESIDE THE DEVICE.	

FIRE ALARM RISER DIAGRAM LINE TYPES	
	ZONE BOUNDARY
	ROOM BOUNDARY

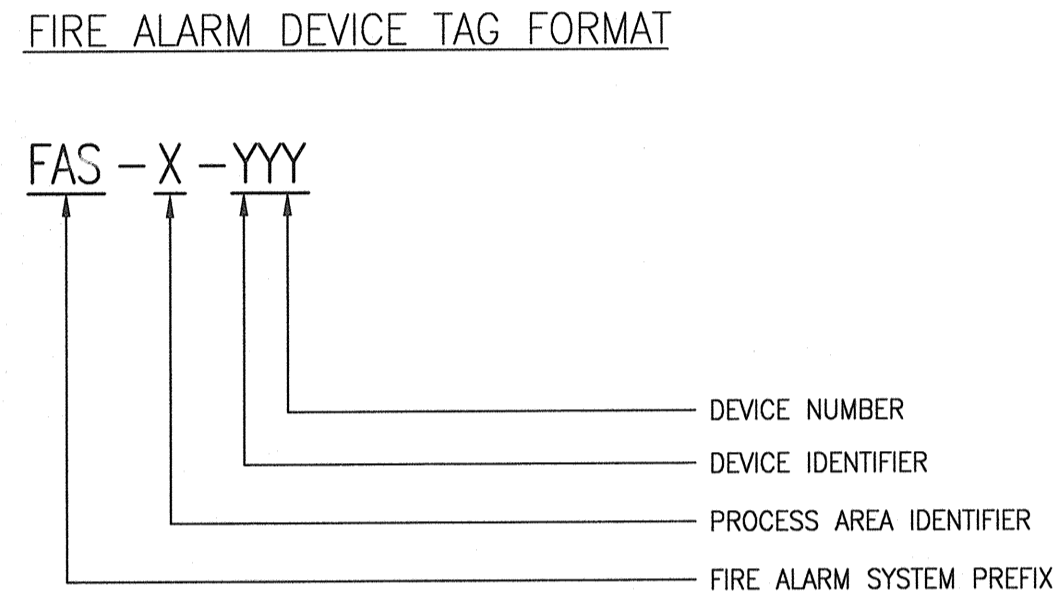

ZONE DESCRIPTION	
ZONE	DESCRIPTION
M01	PUMPHOUSE BASEMENT
M02	PUMPHOUSE MAIN LEVEL

NOTES:

1. THE DEVICE TAG MAY BE SHORTENED TO EXCLUDE THE FIRE ALARM SYSTEM PREFIX AND THE PROCESS AREA/ROOM NUMBER ON SOME DRAWINGS WHERE CONTEXTUAL INFORMATION MAKES THESE PORTIONS OF THE TAG UNNECESSARY.

ABBREVIATION:


FAS = FIRE ALARM SYSTEM
 FACP = FIRE ALARM CONTROL PANEL
 NAC = NOTIFICATION APPLIANCE CIRCUITS
 IDC = INITIATING DEVICE CIRCUITS

1-0660M-E0025-001	FIRE ALARM, RISER DIAGRAM, DETECTION AND NOTIFICATION CIRCUITS
1-0660M-E0024-001	FIRE ALARM PLAN, BASEMENT
1-0660M-E0023-001	FIRE ALARM PLAN, PUMP ROOM
DRAWING NUMBER	REFERENCE DRAWINGS



NO.	REVISIONS	DATE	DESIGN	CHECK
00	ISSUED FOR TENDER AND CONSTRUCTION	2019/10/18	VE	BC

DESIGNED BY: V. ELIMBAN	CHECKED BY: B. CLEVEN
DRAWN BY: C. DUBON	APPROVED BY: D. BECKER
SCALE: NTS	ISSUED FOR CONSTRUCTION BY: A. WEISS
DATE: 2019/07/15	DATE: 2019/10/18
CONSULTANT NO.:	

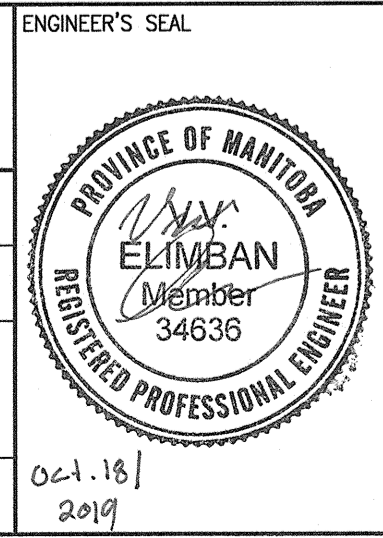

TACHE BOOSTER PUMPING STATION			
ELECTRICAL FIRE ALARM LEGEND AND DETAILS			
CITY DRAWING NUMBER	SHEET	REV.	SIZE
1-0660M-E0026	001	00	A1