




AHU-1 (AUDITORIUM) CONTROL SCHEMATIC (CONSTANT FLOW)  
 SCALE: N.T.S.

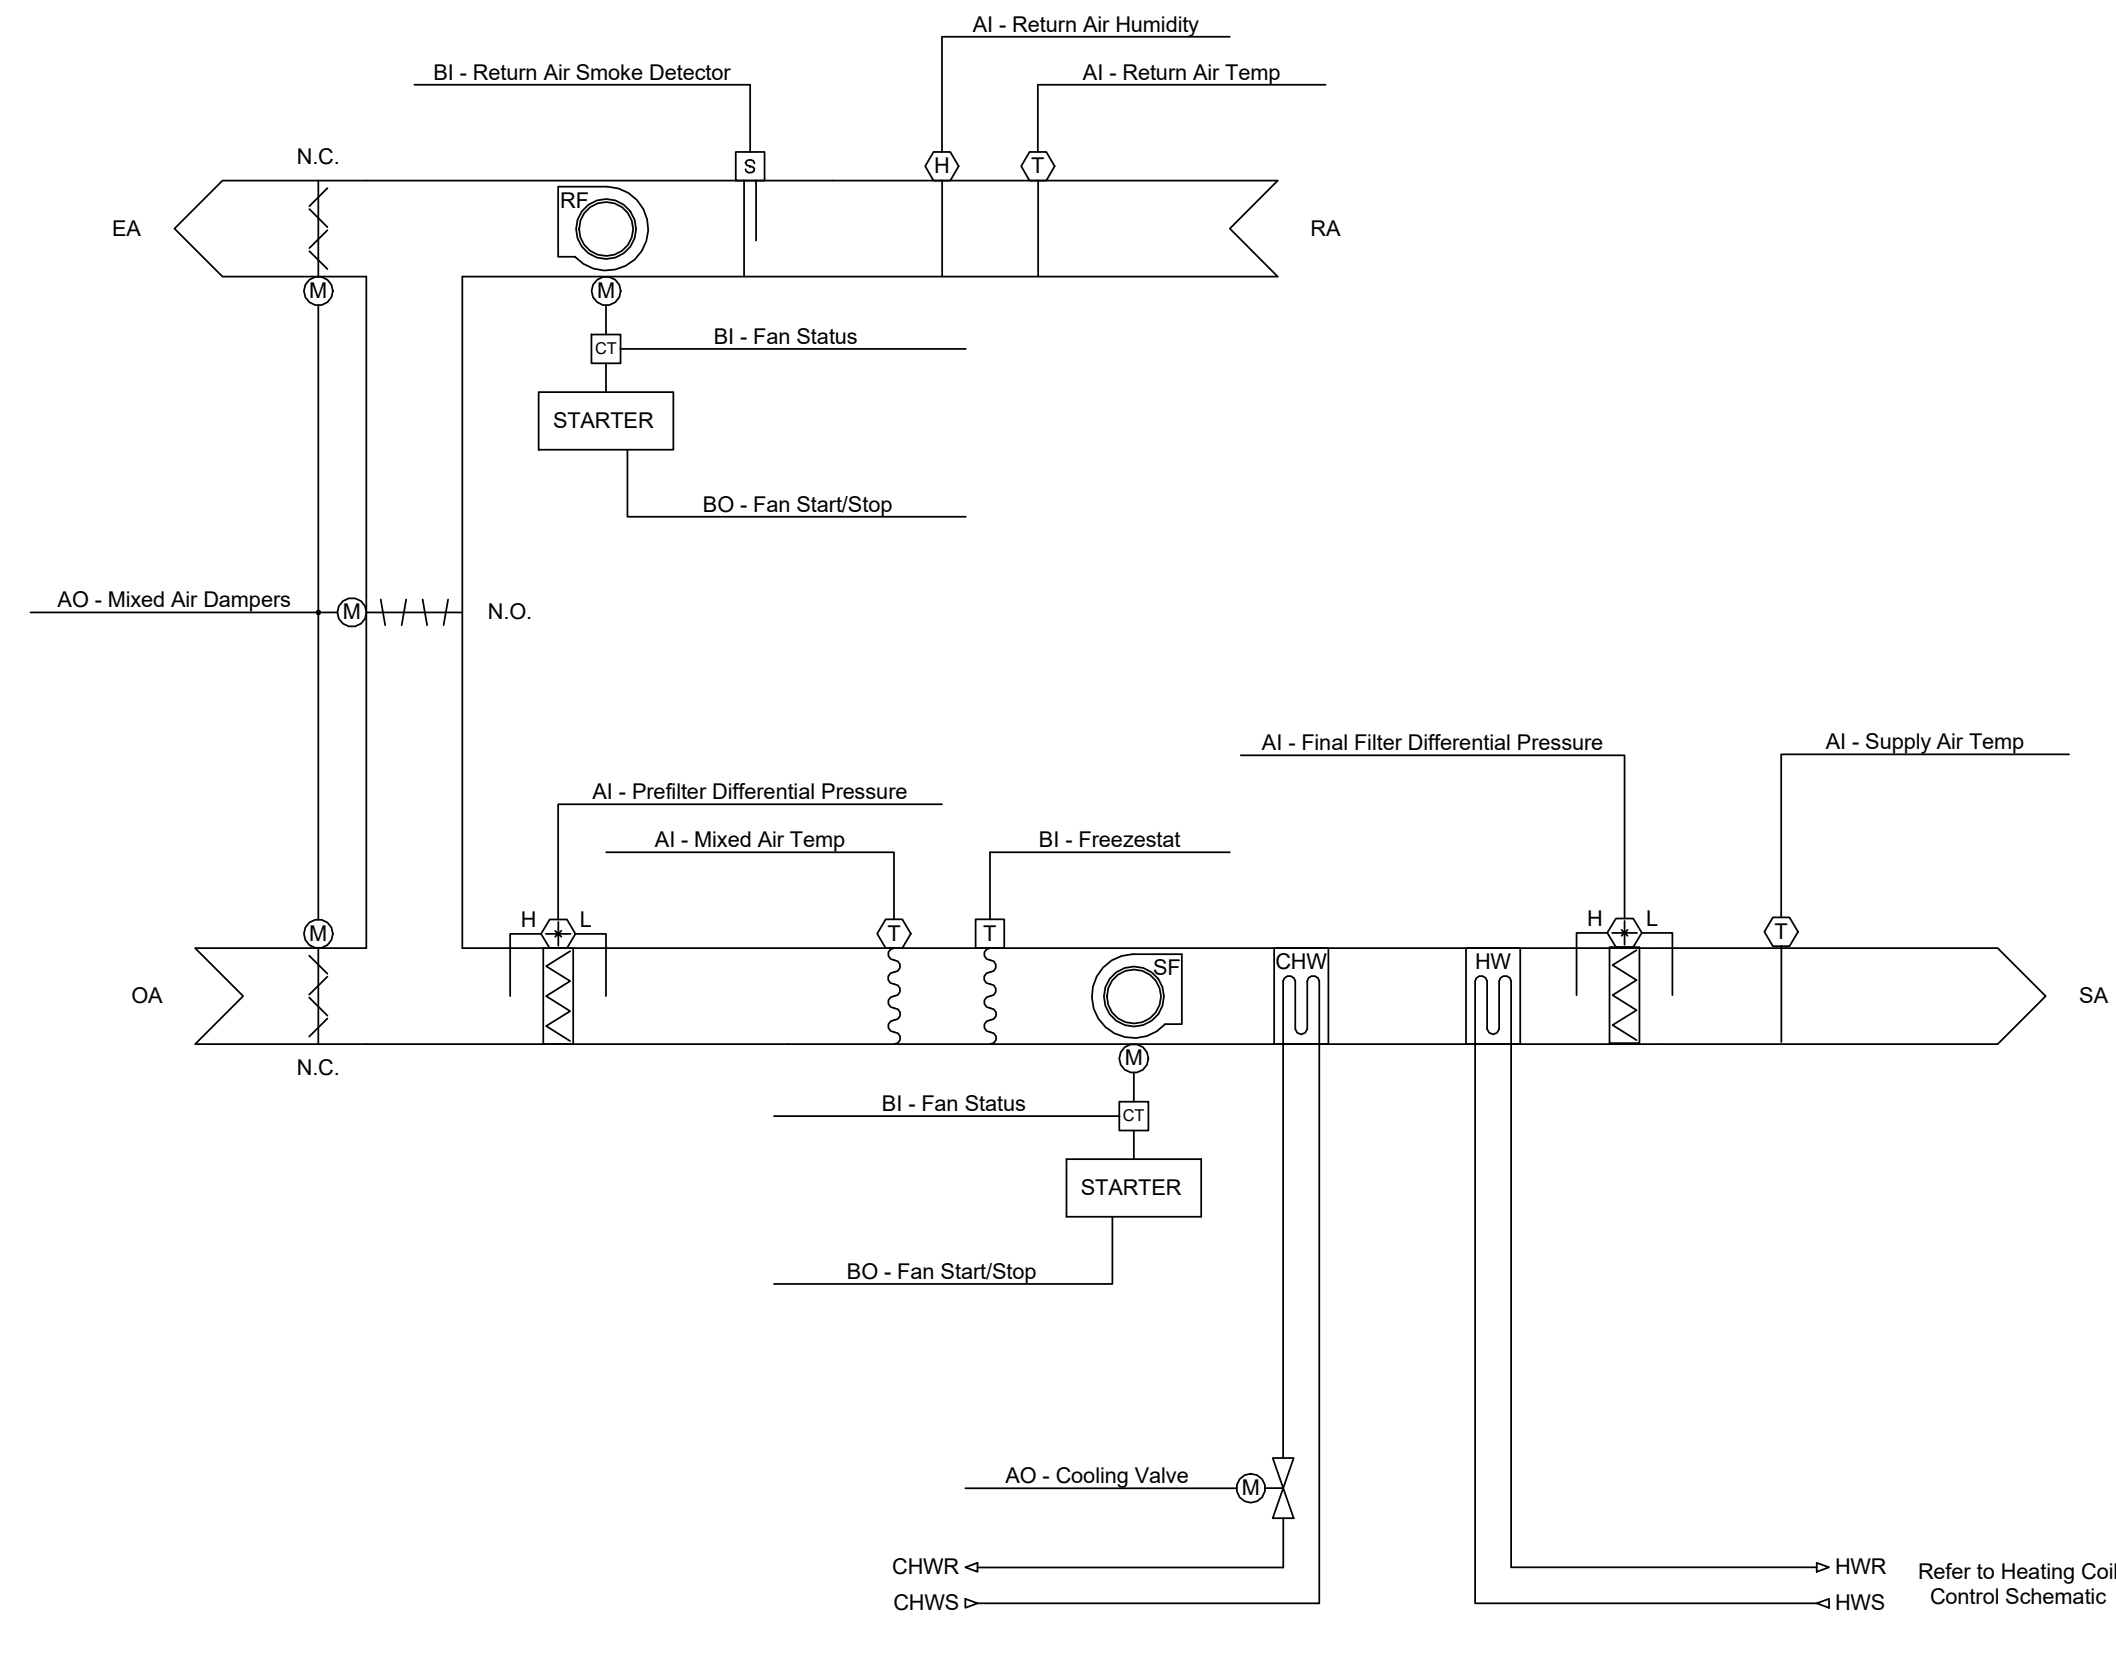


AHU-2 (LOBBY) CONTROL SCHEMATIC (CONSTANT FLOW)  
 SCALE: N.T.S.

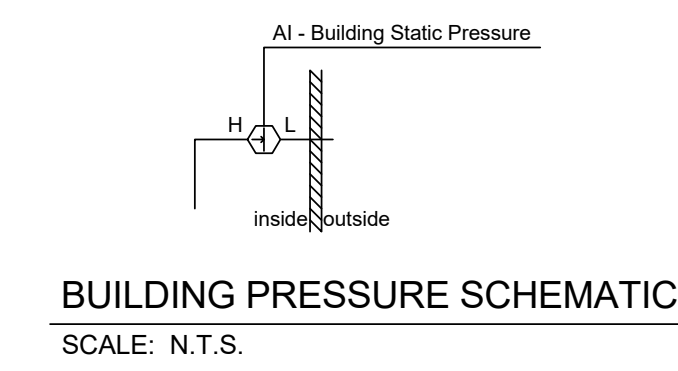


BUILDING PRESSURE SCHEMATIC  
 SCALE: N.T.S.

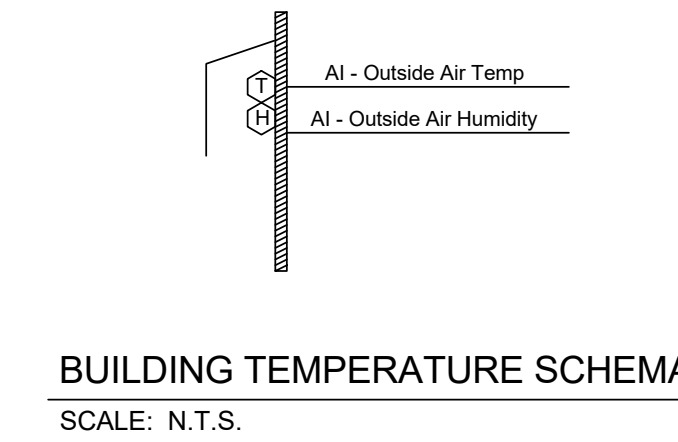


BUILDING TEMPERATURE SCHEMATIC  
 SCALE: N.T.S.

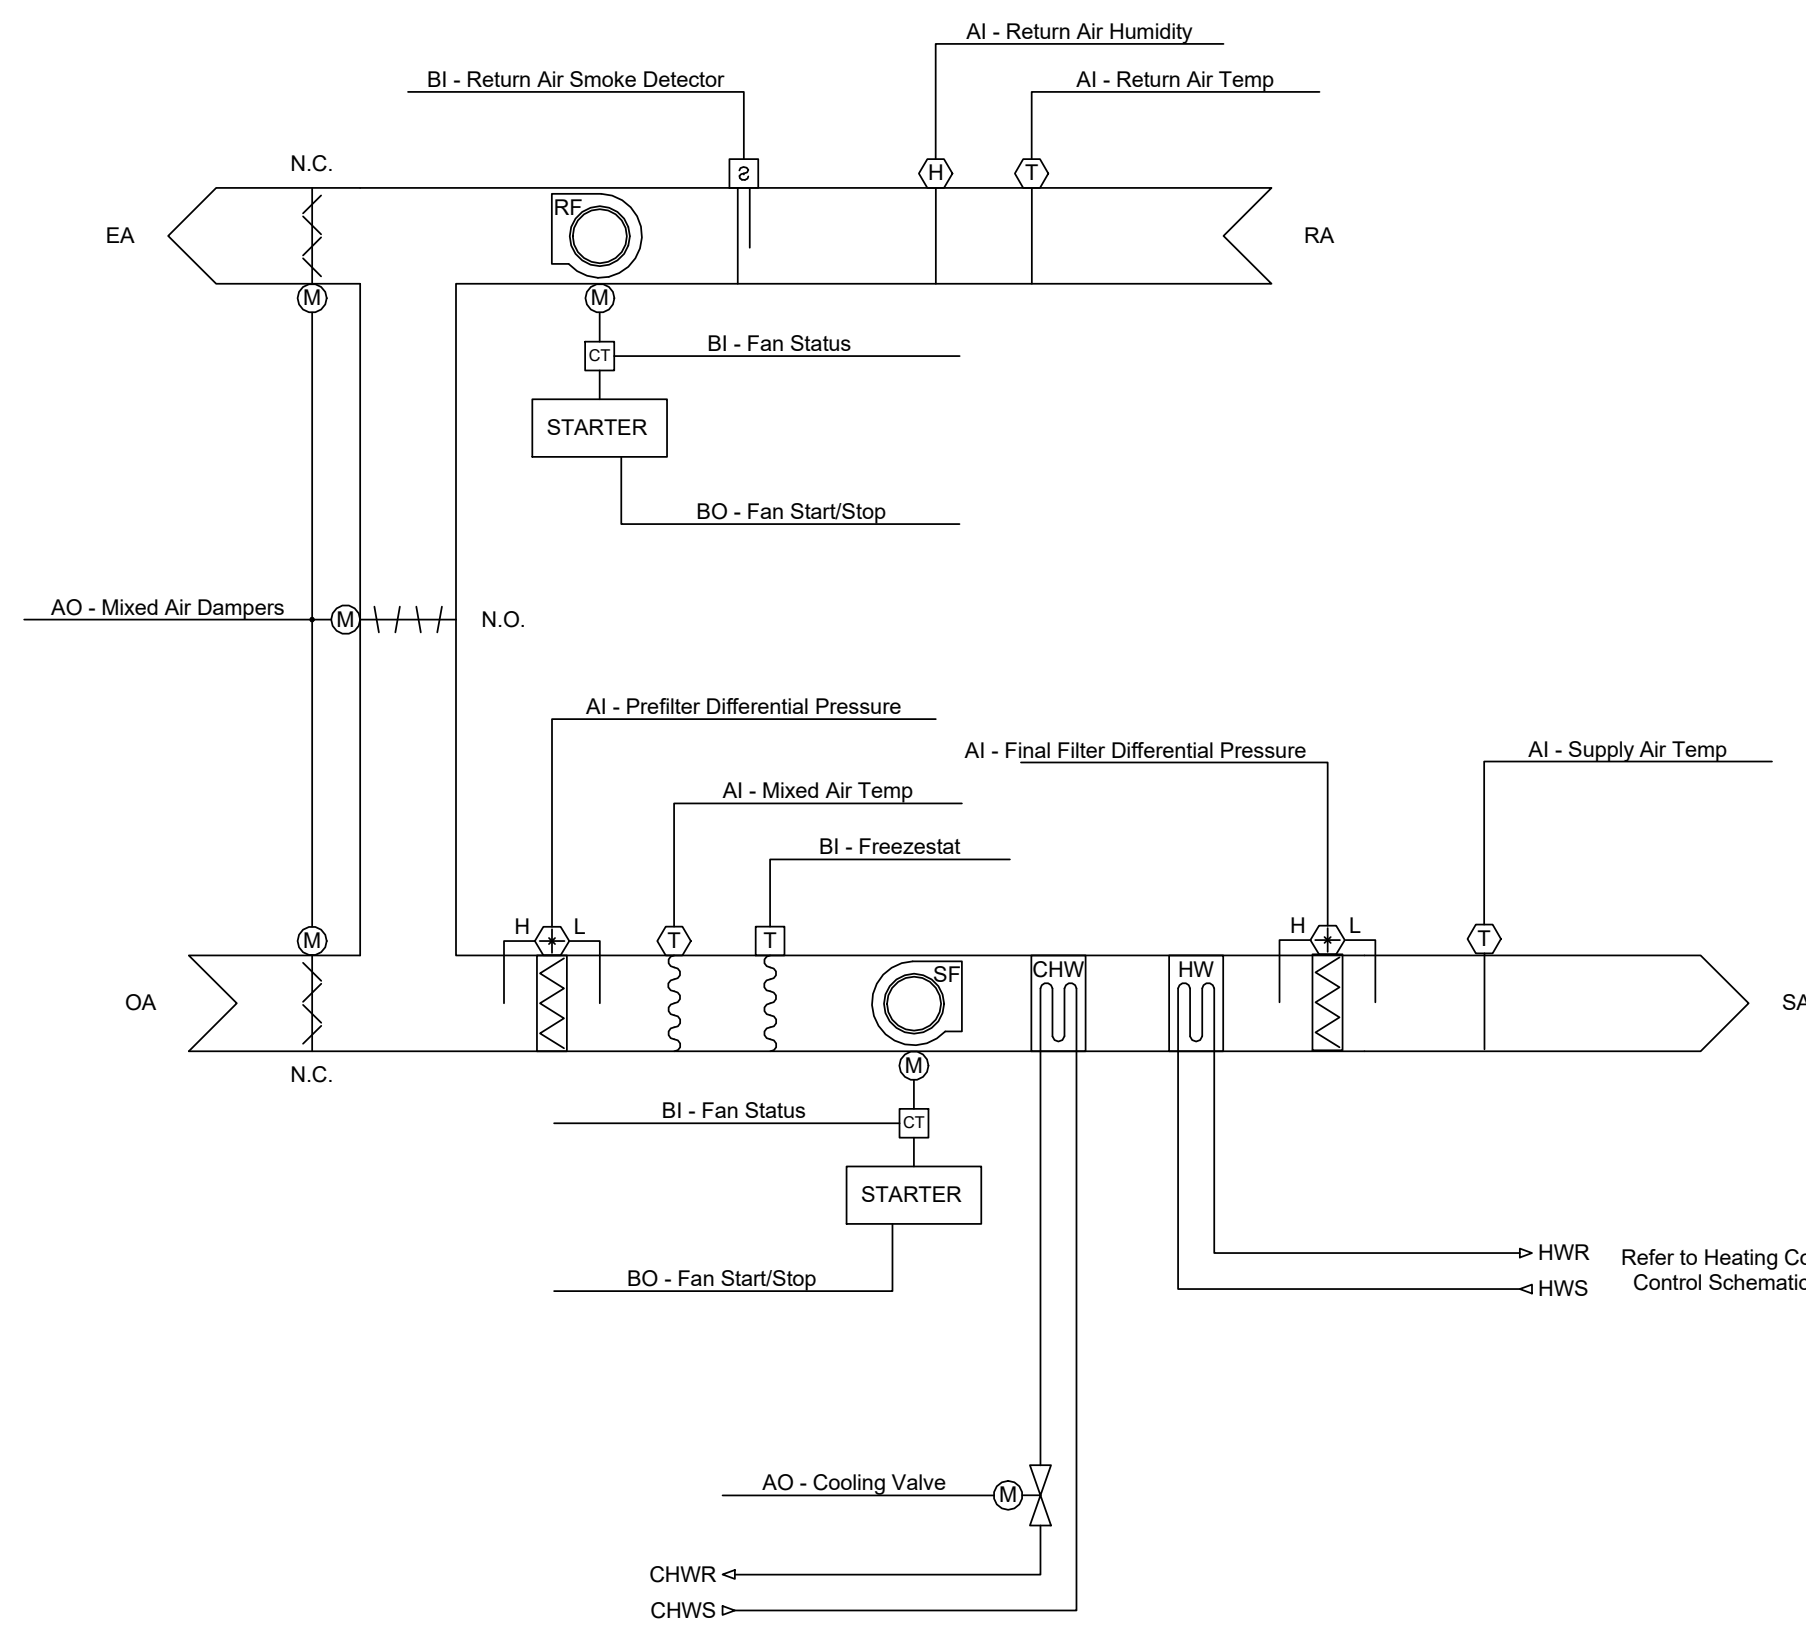


AHU-3 (BASEMENT) CONTROL SCHEMATIC (CONSTANT FLOW)  
 SCALE: N.T.S.

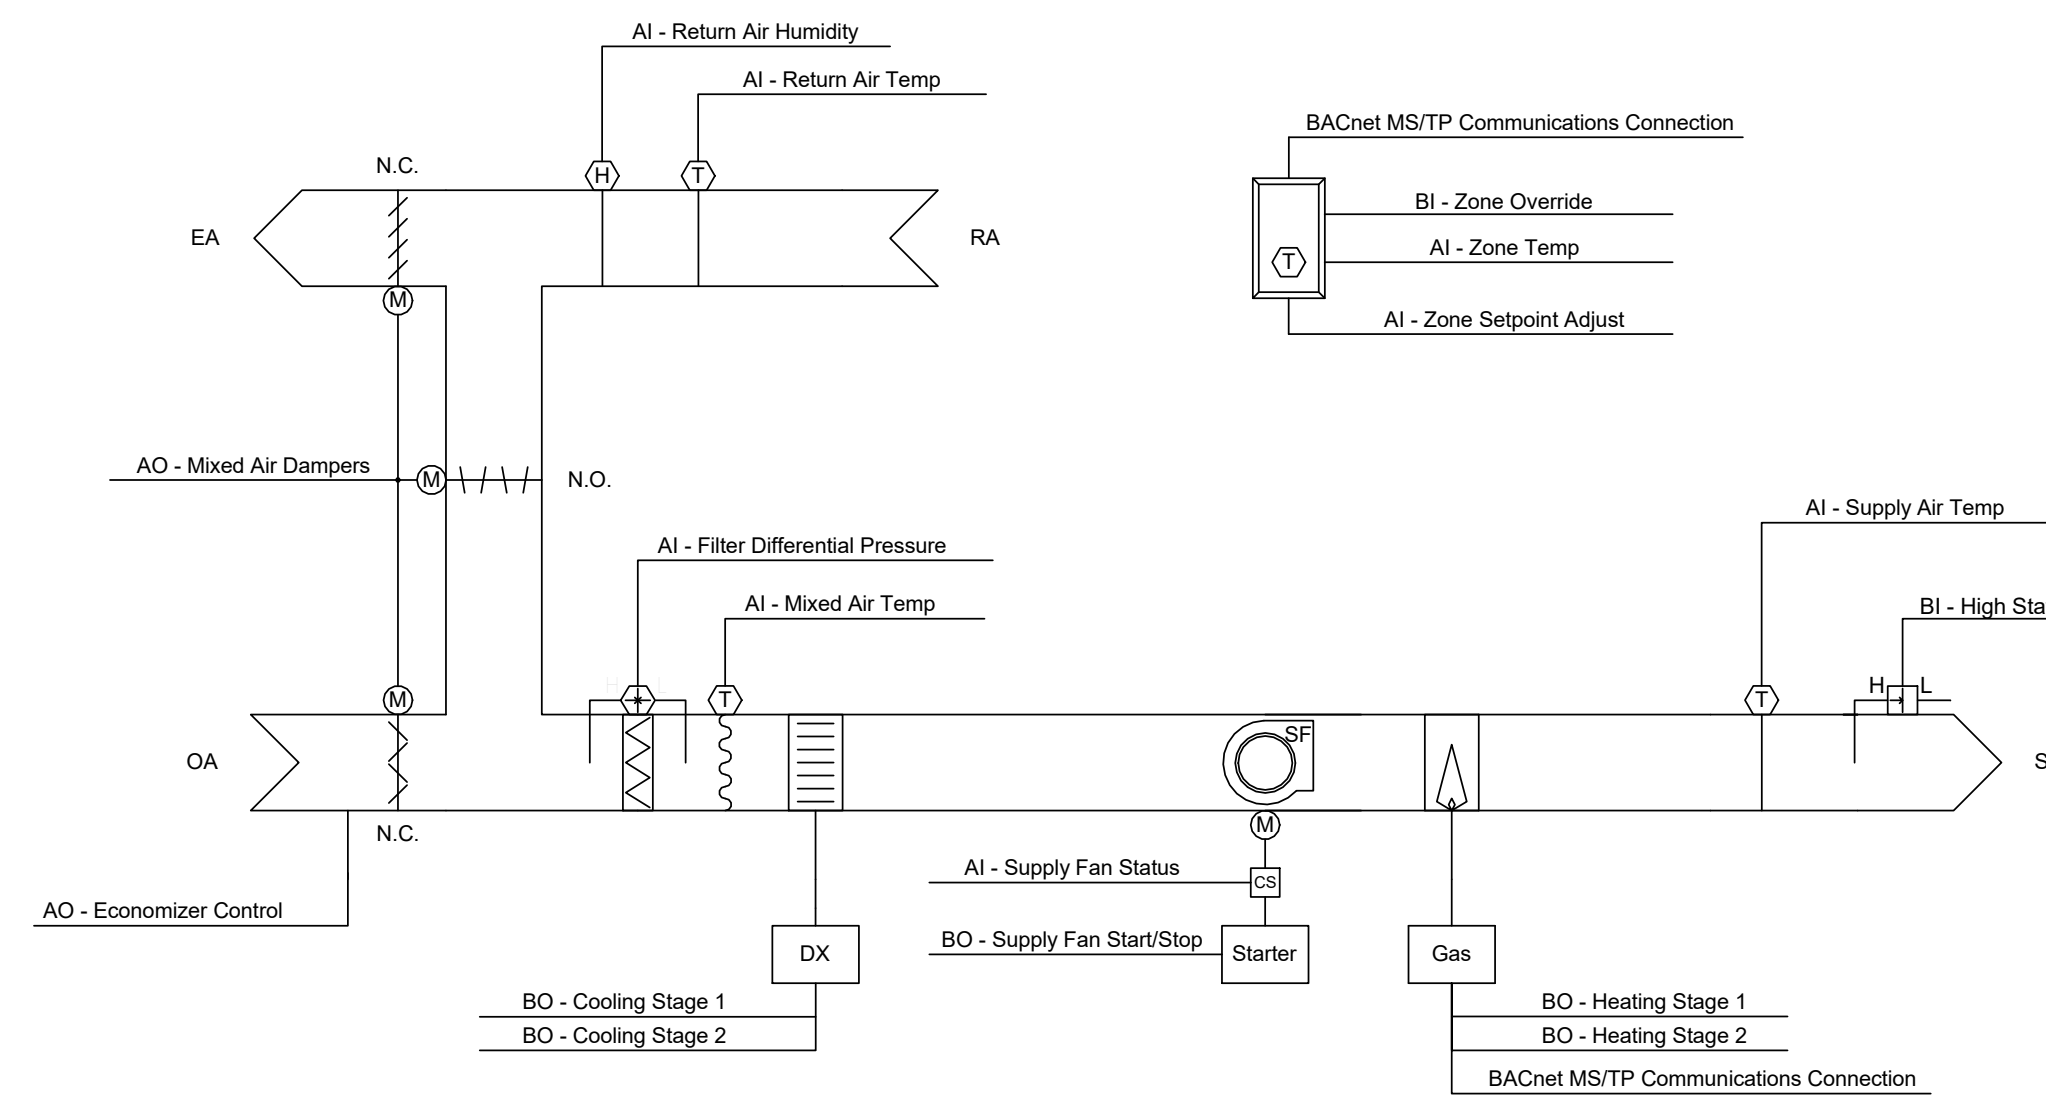


AHU-5 (FITNESS ROOM) CONTROL SCHEMATIC (CONSTANT FLOW)  
 SCALE: N.T.S.

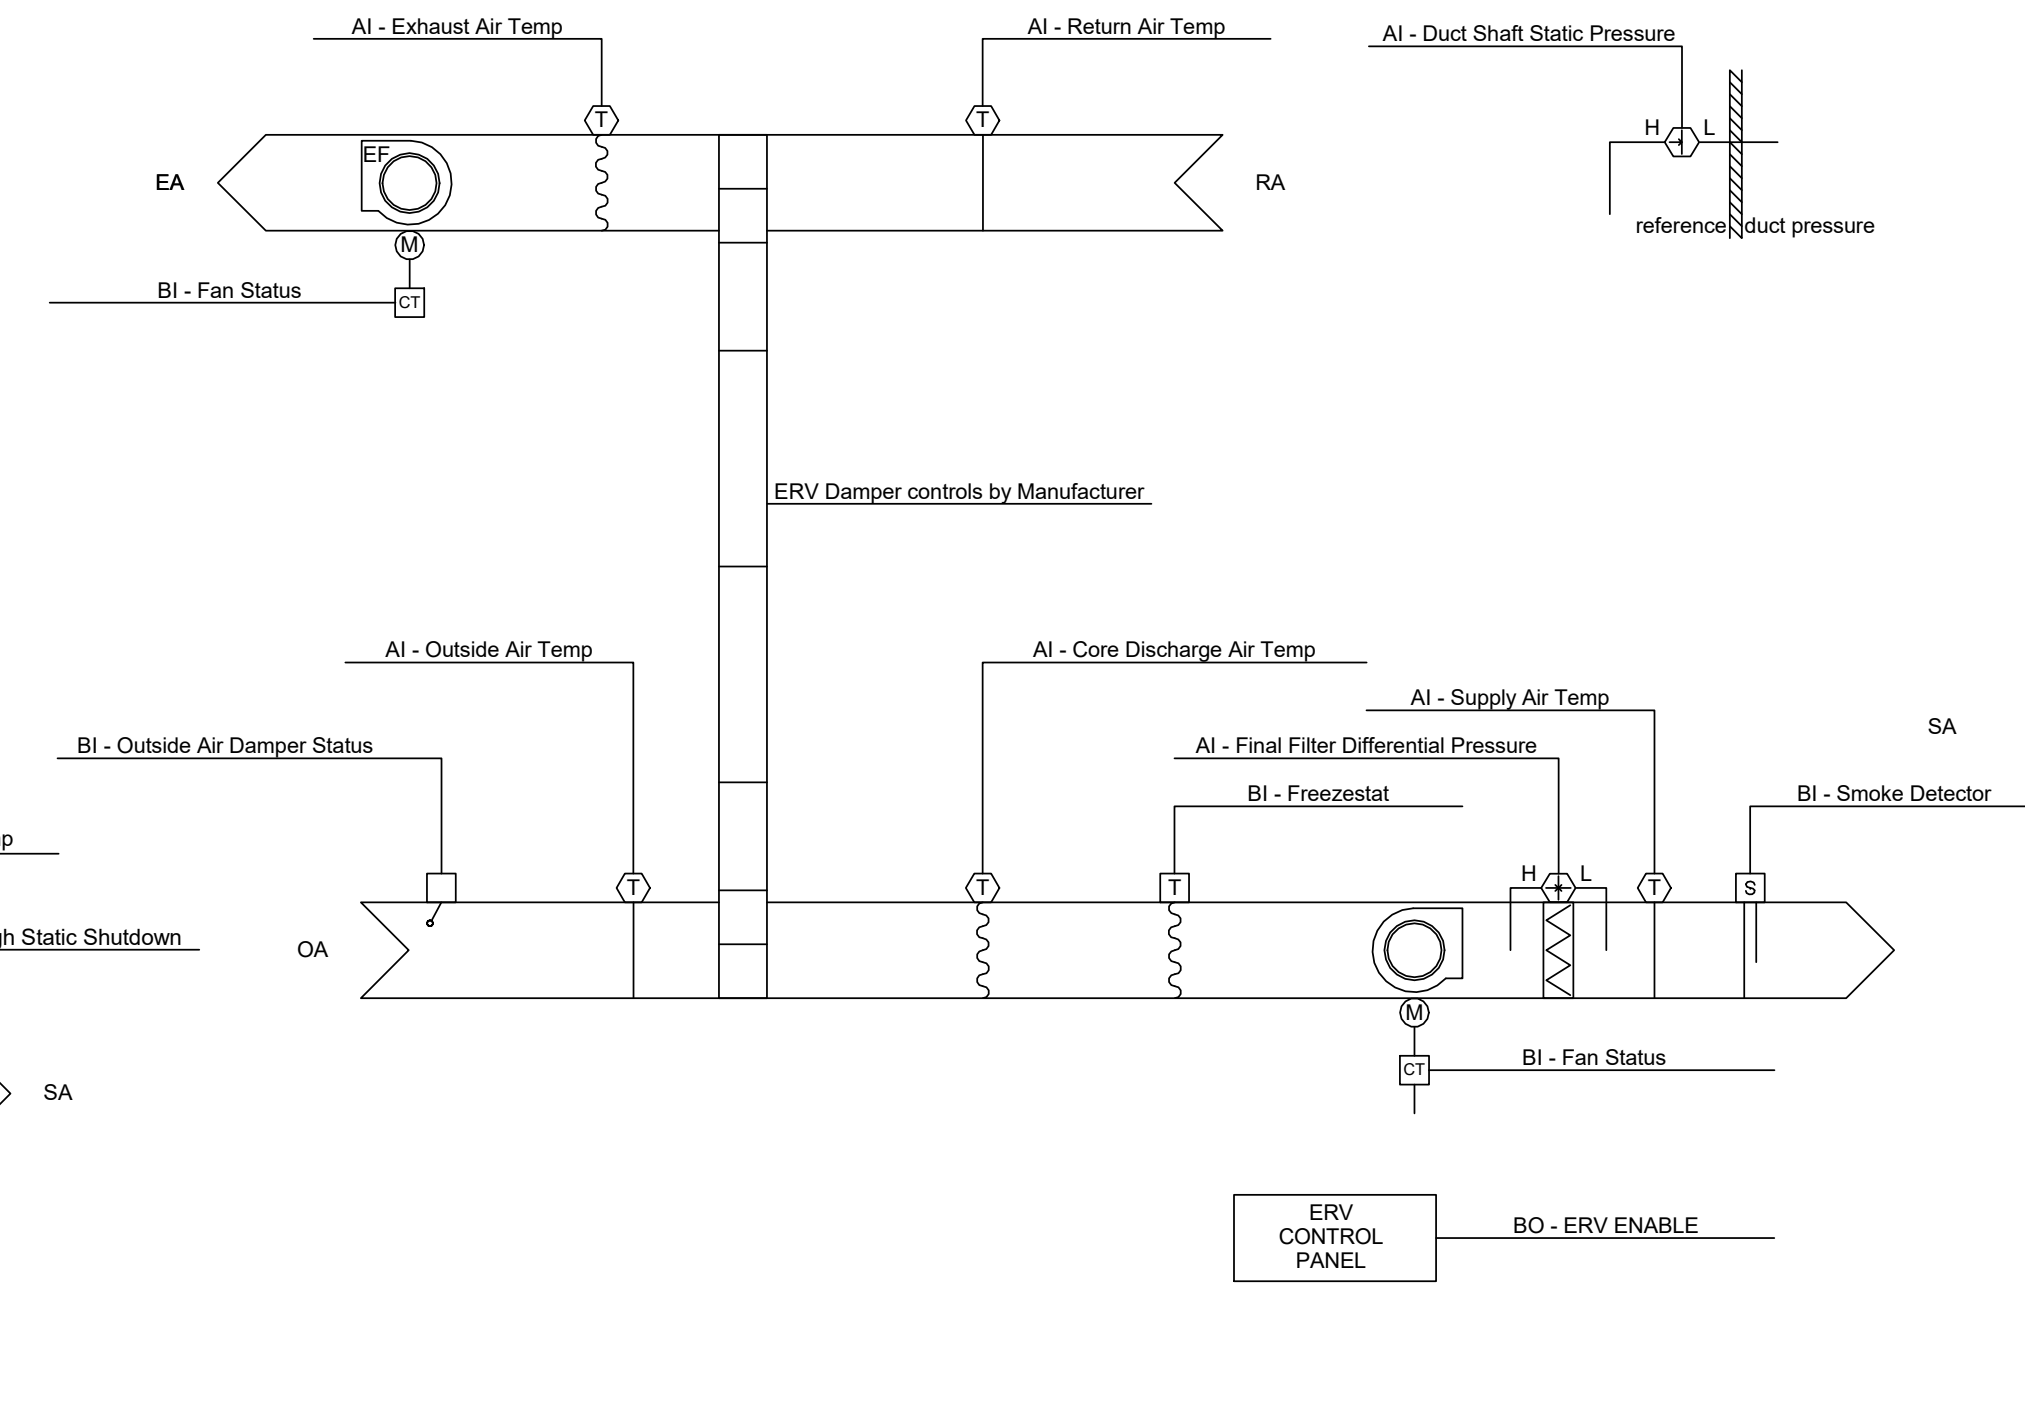

ERV-1 AND ERV-2 CONTROL SCHEMATIC  
 SCALE: N.T.S.

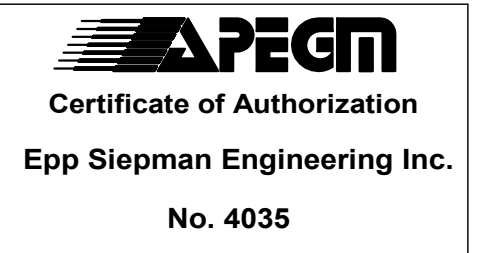

This is a print of a document that has been electronically authenticated with technology authorized by the APEGM. The original is in electronic form.

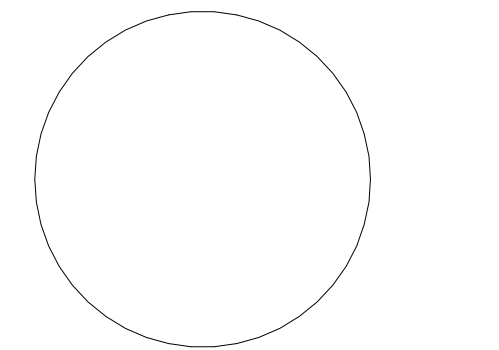

This drawing must not be scaled. The contractor shall verify all dimensions and other data on site prior to commencement of work. Discrepancies, errors, and omissions are to be reported to Public City Architecture Inc. prior to proceeding with the Work.

Drawings and specifications as instruments of service are the property of Public City Architecture Inc., the copyright in the same being reserved. No reproduction or revision to these drawings may be made without the permission of Public City Architecture Inc., and when made, must bear their name. All prints to be returned to Public City Architecture Inc. upon request.

Project  
**ST. JAMES CIVIC CENTRE**

Drawing  
**MECHANICAL SCHEMATICS - CONTROLS**

Drawn By: EB Review By: JS  
 Scale: NTS Tender No: 1176-2019  
 Date: 11/06/19  
 Sheet: M5.3