


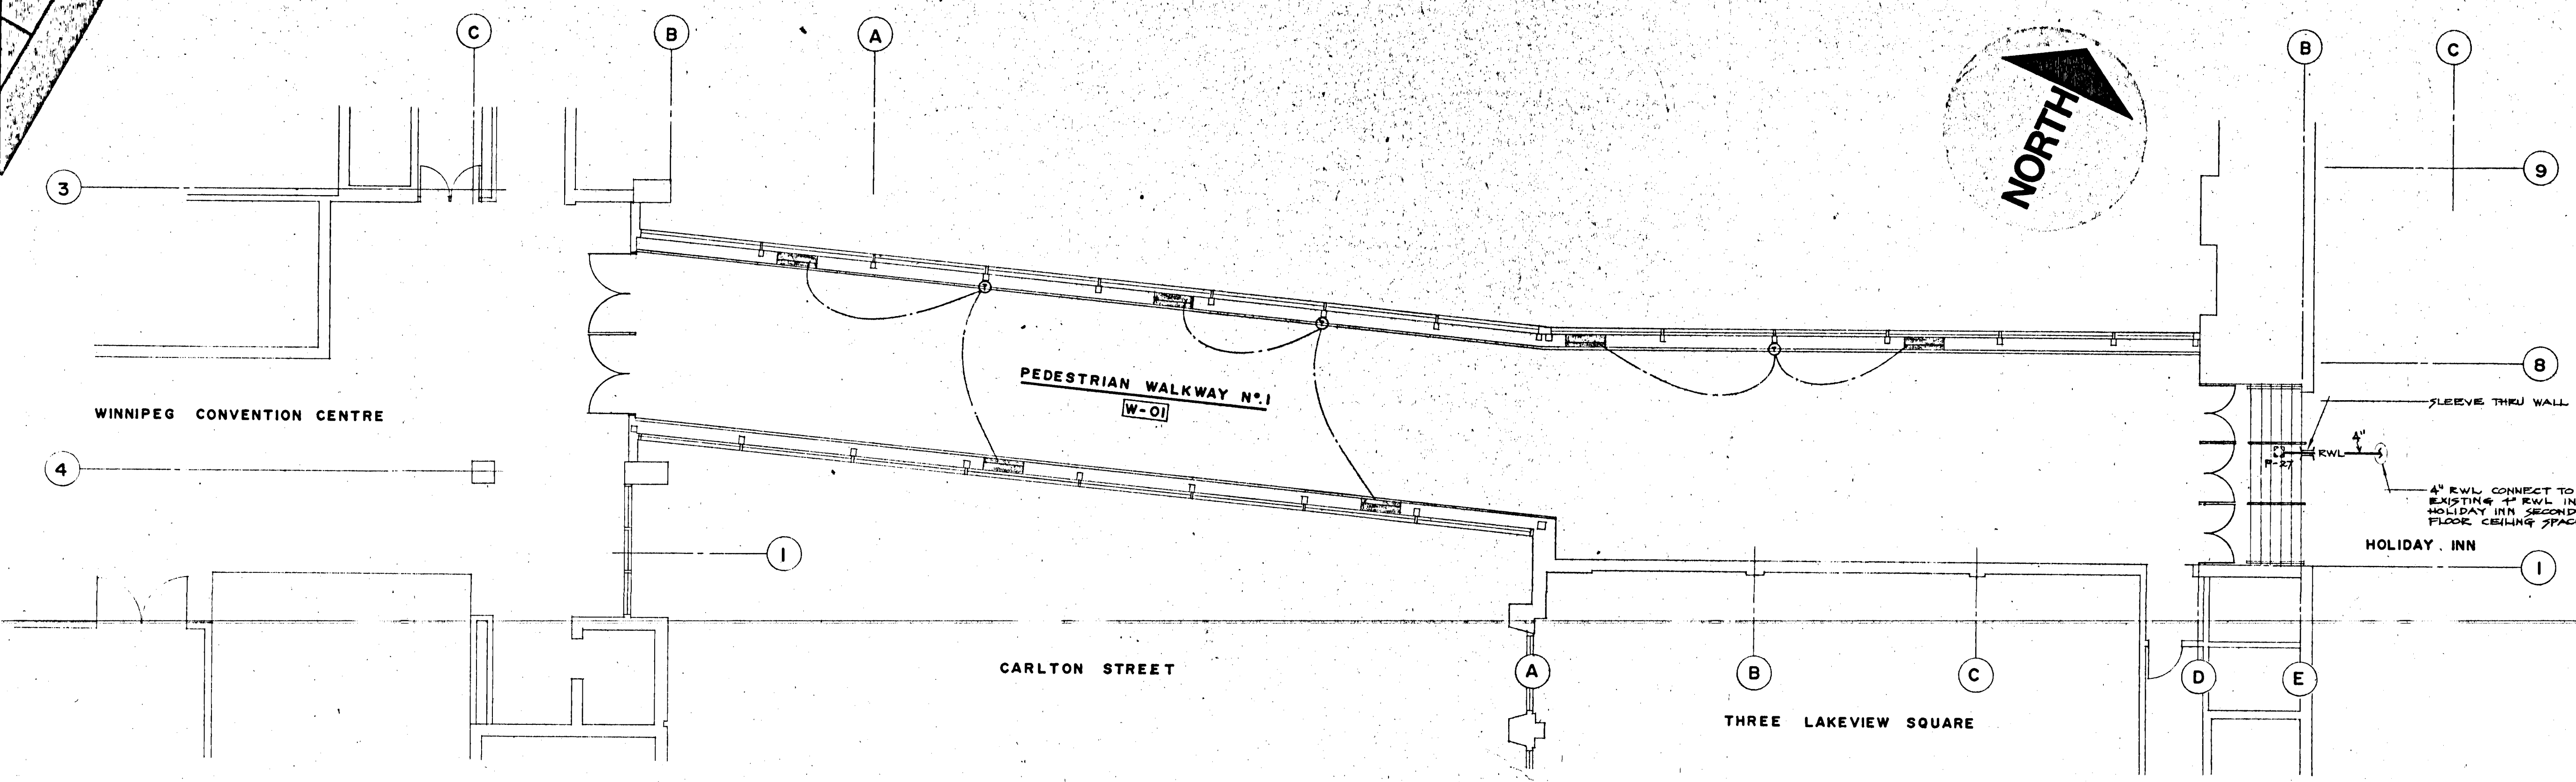

- NOTES:**
1. All conditions of the original mechanical plumbing specifications for the Holiday Inn shall apply to all items shown on this drawing.
 2. The Mechanical Contractor shall supply and install a roof drain as shown on the drawing. Roof drain P-27 shall be Zurn: Z-100-ERC, or equal, c/w extension deck, clamps and sump receiver.
 3. Electrical Contractor shall supply and install six (6) air conditioning units complete with proper supports and remote thermostat with guard. The air conditioning units shall be: General Electric Model Zoneline I R748D complete with temper proof control panel and supply louvre.
Cooling 15,000 BTU/hr.
Heating 4.5 KW 208/1/60
Cabinet RAB 18A
Electric Sub-Base RAB-73
 4. All drilling, cutting and patching by General Contractor.
 5. ALL THERMOSTATS TO BE MOUNTED ON INSULATED SUB-BASE




DATE	DR	REVISION
17/6/74		CONTRACT EXAMINATIONS
		ARCHITECTURAL LAYOUT IMPROVED

THIS DRAWING MUST NOT BE SCALED.
 THE GENERAL CONTRACTOR SHALL VERIFY ALL DIMENSIONS, DATUMS AND LEVELS PRIOR TO COMMENCEMENT OF WORK. ALL ERRORS AND OMISSIONS TO BE REPORTED IMMEDIATELY TO THE ARCHITECT.
 VARIATIONS & MODIFICATIONS TO WORK SHOWN ON THESE DRAWINGS SHALL NOT BE CARRIED OUT WITHOUT WRITTEN PERMISSION FROM THE ARCHITECT.
 THIS DRAWING IS THE EXCLUSIVE PROPERTY OF THE ARCHITECTS AND CAN BE REPRODUCED ONLY WITH THE PERMISSION OF THE ARCHITECTS, IN WHICH CASE THE REPRODUCTION MUST BEAR THEIR NAME AS ARCHITECTS.

WINNIPEG CONSORTIUM
 THE LA ARCHITECTURAL GROUP
 THE NUMBER TEN ARCHITECTURAL GROUP
ARCHITECTS
 5th Floor, Two Lakes Square - 175 Carlton St. - Winnipeg R3C 0X8
 Telephone (204) 942-3546

ASSOCIATE ARCHITECT

CONSULTING ENGINEER
Klein & Dashevsky Ltd.
 CONSULTING MECHANICAL ENGINEERS
 WINNIPEG, MANITOBA R3C 0X8

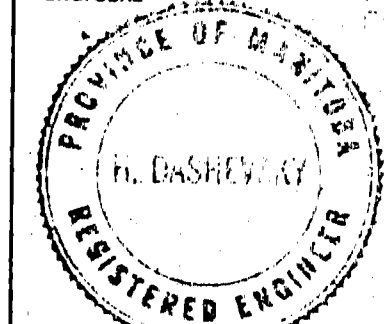ARCH. SEAL
 ENG. SEAL


PROJECT
PEDESTRIAN WALKWAY NO. 1
 FROM
THE WINNIPEG CONVENTION CENTRE
 TO
THE HOLIDAY INN

SHEET TITLE
FLOOR PLAN

DRAWN BY: *HA* DATE: MAY 27, 1974 SHEET NO.: M-1
 CHECKED BY: *JCB* PROJECT NO.: FILE NO.:

B-14
FILE
 RETURN TO CIVIC PROPERTIES BUILDING INVENTORY.
 6 | 08 | 1

AUG 08 1974