


**GENERAL NOTES**

- A. ELECTRICAL SUBCONTRACTOR TO VISIT SITE DURING BID AND VERIFY ALL EXISTING SERVICES ON SITE PRIOR TO SUBMITTING BID. REPORT ANY DISCREPANCIES TO CONTRACT ADMINISTRATOR DURING BID PERIOD.
- B. FOR ALL EXISTING ELECTRICAL DEVICES, EQUIPMENT, ETC. THAT ARE TO BE REMOVED, REMOVE EXISTING CONDUIT, WIRING, CONTROL PANEL, MOTOR STARTER, ETC. BACK TO SOURCE UNLESS OTHERWISE NOTED. TURN BREAKER OFF, MARK AS SPARE, UPDATE PANEL DIRECTORY AND LABELLING. FOR CONDUITS EMBEDDED IN FLOOR SLAB, REMOVE WIRING, CUT CONDUIT AT FLOOR LEVEL AND SEAL CONDUIT.
- C. EXISTING EQUIPMENT TO BE OFFERED TO THE CITY UPON REMOVAL. DISPOSE OF EQUIPMENT UPON THE CITY'S REQUEST.
- D. COORDINATE WITH THE CITY PRIOR TO SHUT-DOWN OR REMOVAL OF EQUIPMENT.
- E. ALL ABANDONED EQUIPMENT AND SERVICES WITHIN AREA OF WORK SHALL BE REMOVED.
- F. THIS BUILDING MAY CONTAIN ASBESTOS. REFER TO FRONT END SPECIFICATIONS FOR FURTHER INFORMATION.
- G. FIRE STOP ALL PENETRATIONS LEFT BY DEMOLITION OF CABLE/CONDUITS.
- H. ELECTRICAL SUBCONTRACTOR TO VERIFY ALL EXISTING CIRCUITING ON SITE PRIOR TO DISCONNECTION OF LOADS.

**DEMOLITION KEY NOTES**

- 1. EXISTING FAN F-2 BE REMOVED BY MECHANICAL. REMOVE ALL ASSOCIATED WIRING, CONDUIT, ETC. BACK TO SOURCE.
- 2. DISCONNECT AND REMOVE EXISTING MCC-MM ONCE ALL ROOF TOP FANS ARE REMOVED BY MECHANICAL. REMOVE FEEDER, WIRE, CONDUIT, ETC. BACK TO EXISTING MAIN DISTRIBUTION. REFER TO DRAWING E1.2 FOR ROOF TOP FANS REMOVAL. DISCONNECT AND REMOVE EXISTING MCC BUCKETS AND TURN OVER TO CITY. DISPOSE OF EXISTING MCC.
- 3. NEW HEAT TRACE TO BE ADDED TO EXISTING HRU. REFER TO DRAWING E.2.2.

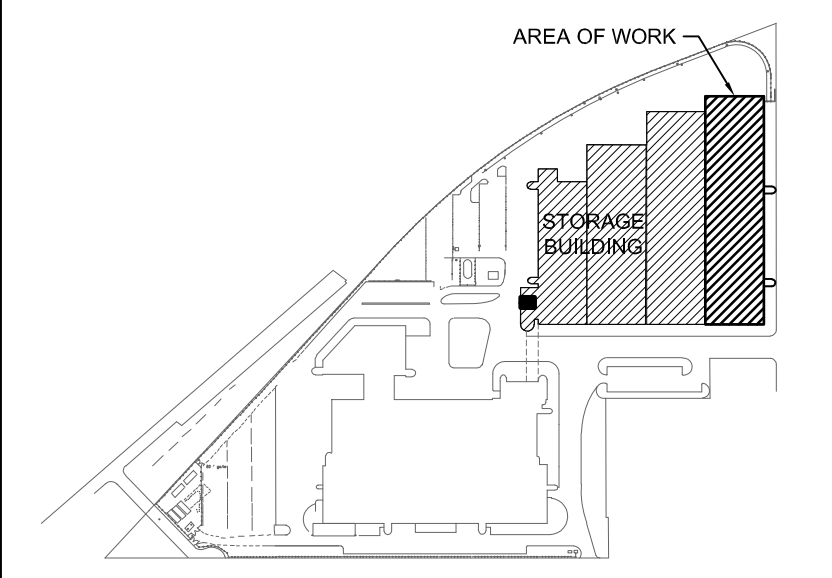

**KEY PLAN**  
NTS

NO.	Description	BY	DATE
1	RE-ISSUED FOR ADDENDUM 2	VEK	07/02/20
0	ISSUED FOR CONSTRUCTION	VEK	16/01/20

**ENGINEERS  
GEOSCIENTISTS  
MANITOBA**  
Certificate of Authorization  
**SMS Engineering Ltd.**  
No. 166

ORIGINAL  
CONTRACT DRAWING  
SIGNED AND SEALED BY  
**VE. KANE, P. ENG.**  
JANUARY 16, 2020

770 Bradford Street  
Winnipeg, Canada  
T 204 775 0291  
SMSeng.com



Project Title  
**CITY OF WINNIPEG FORT ROUGE  
TRANSIT BASE - STORAGE  
TRACK 25-36 - MECHANICAL  
UPGRADE**  
WINNIPEG MANITOBA

Drawing Title  
**MAIN FLOOR PLAN -  
STORAGE TRACKS -  
ELECTRICAL -  
DEMOLITION**

Drawn By WPD	Checked By RD	Approved By VEK
Scale	Date JANUARY, 2020	Project No. 19-332-02
Revision Number <b>1</b>	Drawing Number <b>E1.3</b>	Sheet Order 3 OF 6

**1 MAIN FLOOR PLAN - STORAGE TRACKS - MECHANICAL - DEMOLITION**  
E1.3 SCALE: 1/32" = 1'-0"

E:\Projects\2019\19-332-02\Drawings\19-332-02-01-E1.3-DWG.dwg  
 DATE PLOTTED: 2020-01-16 10:00:00 AM  
 PLOTTER: HP DesignJet T1100PS