


GENERAL NOTES:

1. -

BUILDING/ROOM LEGEND:

- 101A - RAILCAR SHELTER 1 (EXISTING)
- 101B - RAILCAR SHELTER 2 (NEW)
- 101C - FERRIC CHLORIDE CHEMICAL STORAGE ROOM (NEW)
- 101D - NEW ELECTRICAL ROOM

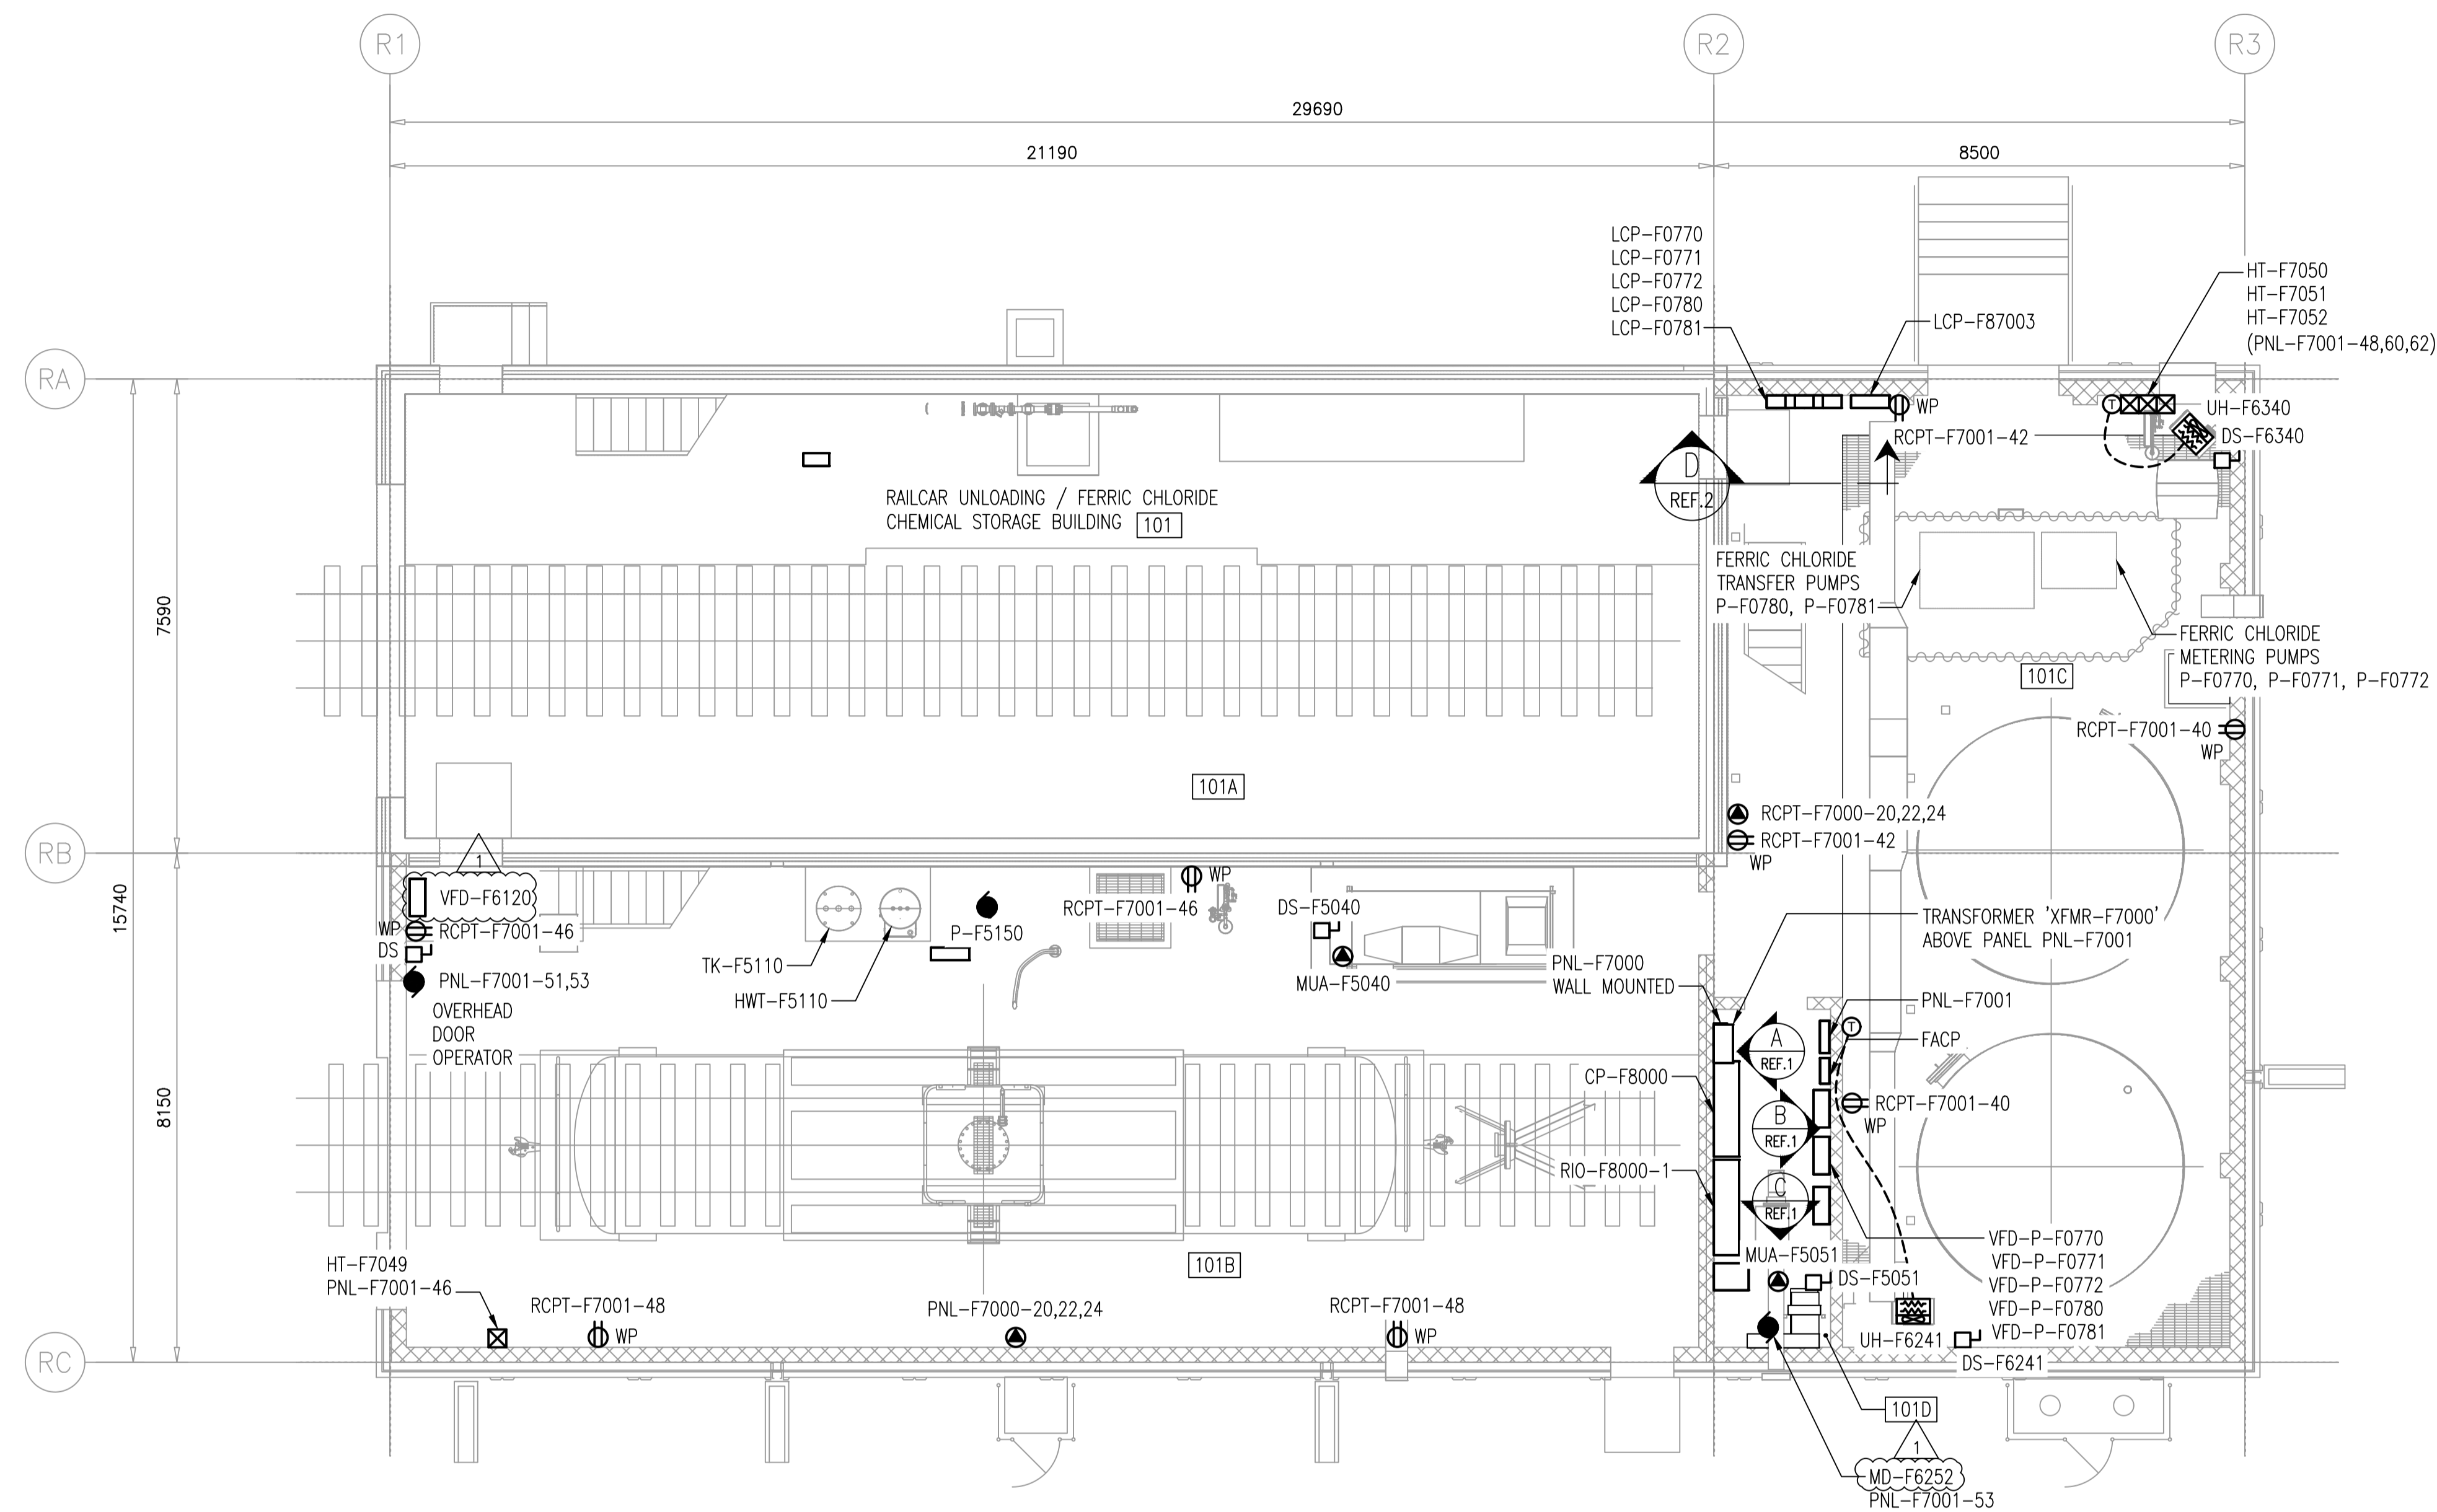

PLAN - MAIN FLOOR  
 SCALE: 1:75mm

10	-	-
9	-	-
8	-	-
7	-	-
6	-	-
5	-	-
4	-	-
3	-	-
2	1-0101-EGAD-F208-001	ELECTRICAL - ELECTRICAL DETAILS - INSTALLATION DETAILS
1	1-0101-EDTL-F003-001	ELECTRICAL - INSTALLATION DETAILS
NO.	DRAWING NUMBER	REFERENCE DRAWING TITLE
REFERENCE DRAWINGS		



B.M. ELEV.	
CONSTRUCTION COMPLETION DATE: YYYY MM DD	
DESIGNED BY	DG
CHECKED BY	JAB
DRAWN BY	RG
APPROVED BY	JAB
SCALE:	AS SHOWN
RELEASED FOR CONSTRUCTION	
DATE	2021 12 16
DATE	2022 07 12
NO.	REVISIONS
1	RE-ISSUED FOR CONSTRUCTION 2022 07 05 JAB
0	ISSUED FOR CONSTRUCTION 2022 05 18 JAB

**KGS GROUP**

DESIGNED BY	DG	CHECKED BY	JAB
DRAWN BY	RG	APPROVED BY	JAB
SCALE:	AS SHOWN		
DATE	2021 12 16	DATE	

ENGINEER'S SEAL
CONSULTANT DRAWING NUMBER
21-0107-015_E2.111

**THE CITY OF WINNIPEG**  
 WATER AND WASTE DEPARTMENT  
 ENGINEERING DIVISION

**Winnipeg**

NORTH END SEWAGE TREATMENT PLANT (NEWPC)  
 INTERIM PHOSPHOROUS REMOVAL  
 ELECTRICAL

BUILDING 101  
 MAIN FLOOR POWER LAYOUT

CITY DRAWING NUMBER	1-0101-EGAD-F201-001	SHEET	1	OF	1
---------------------	----------------------	-------	---	----	---