
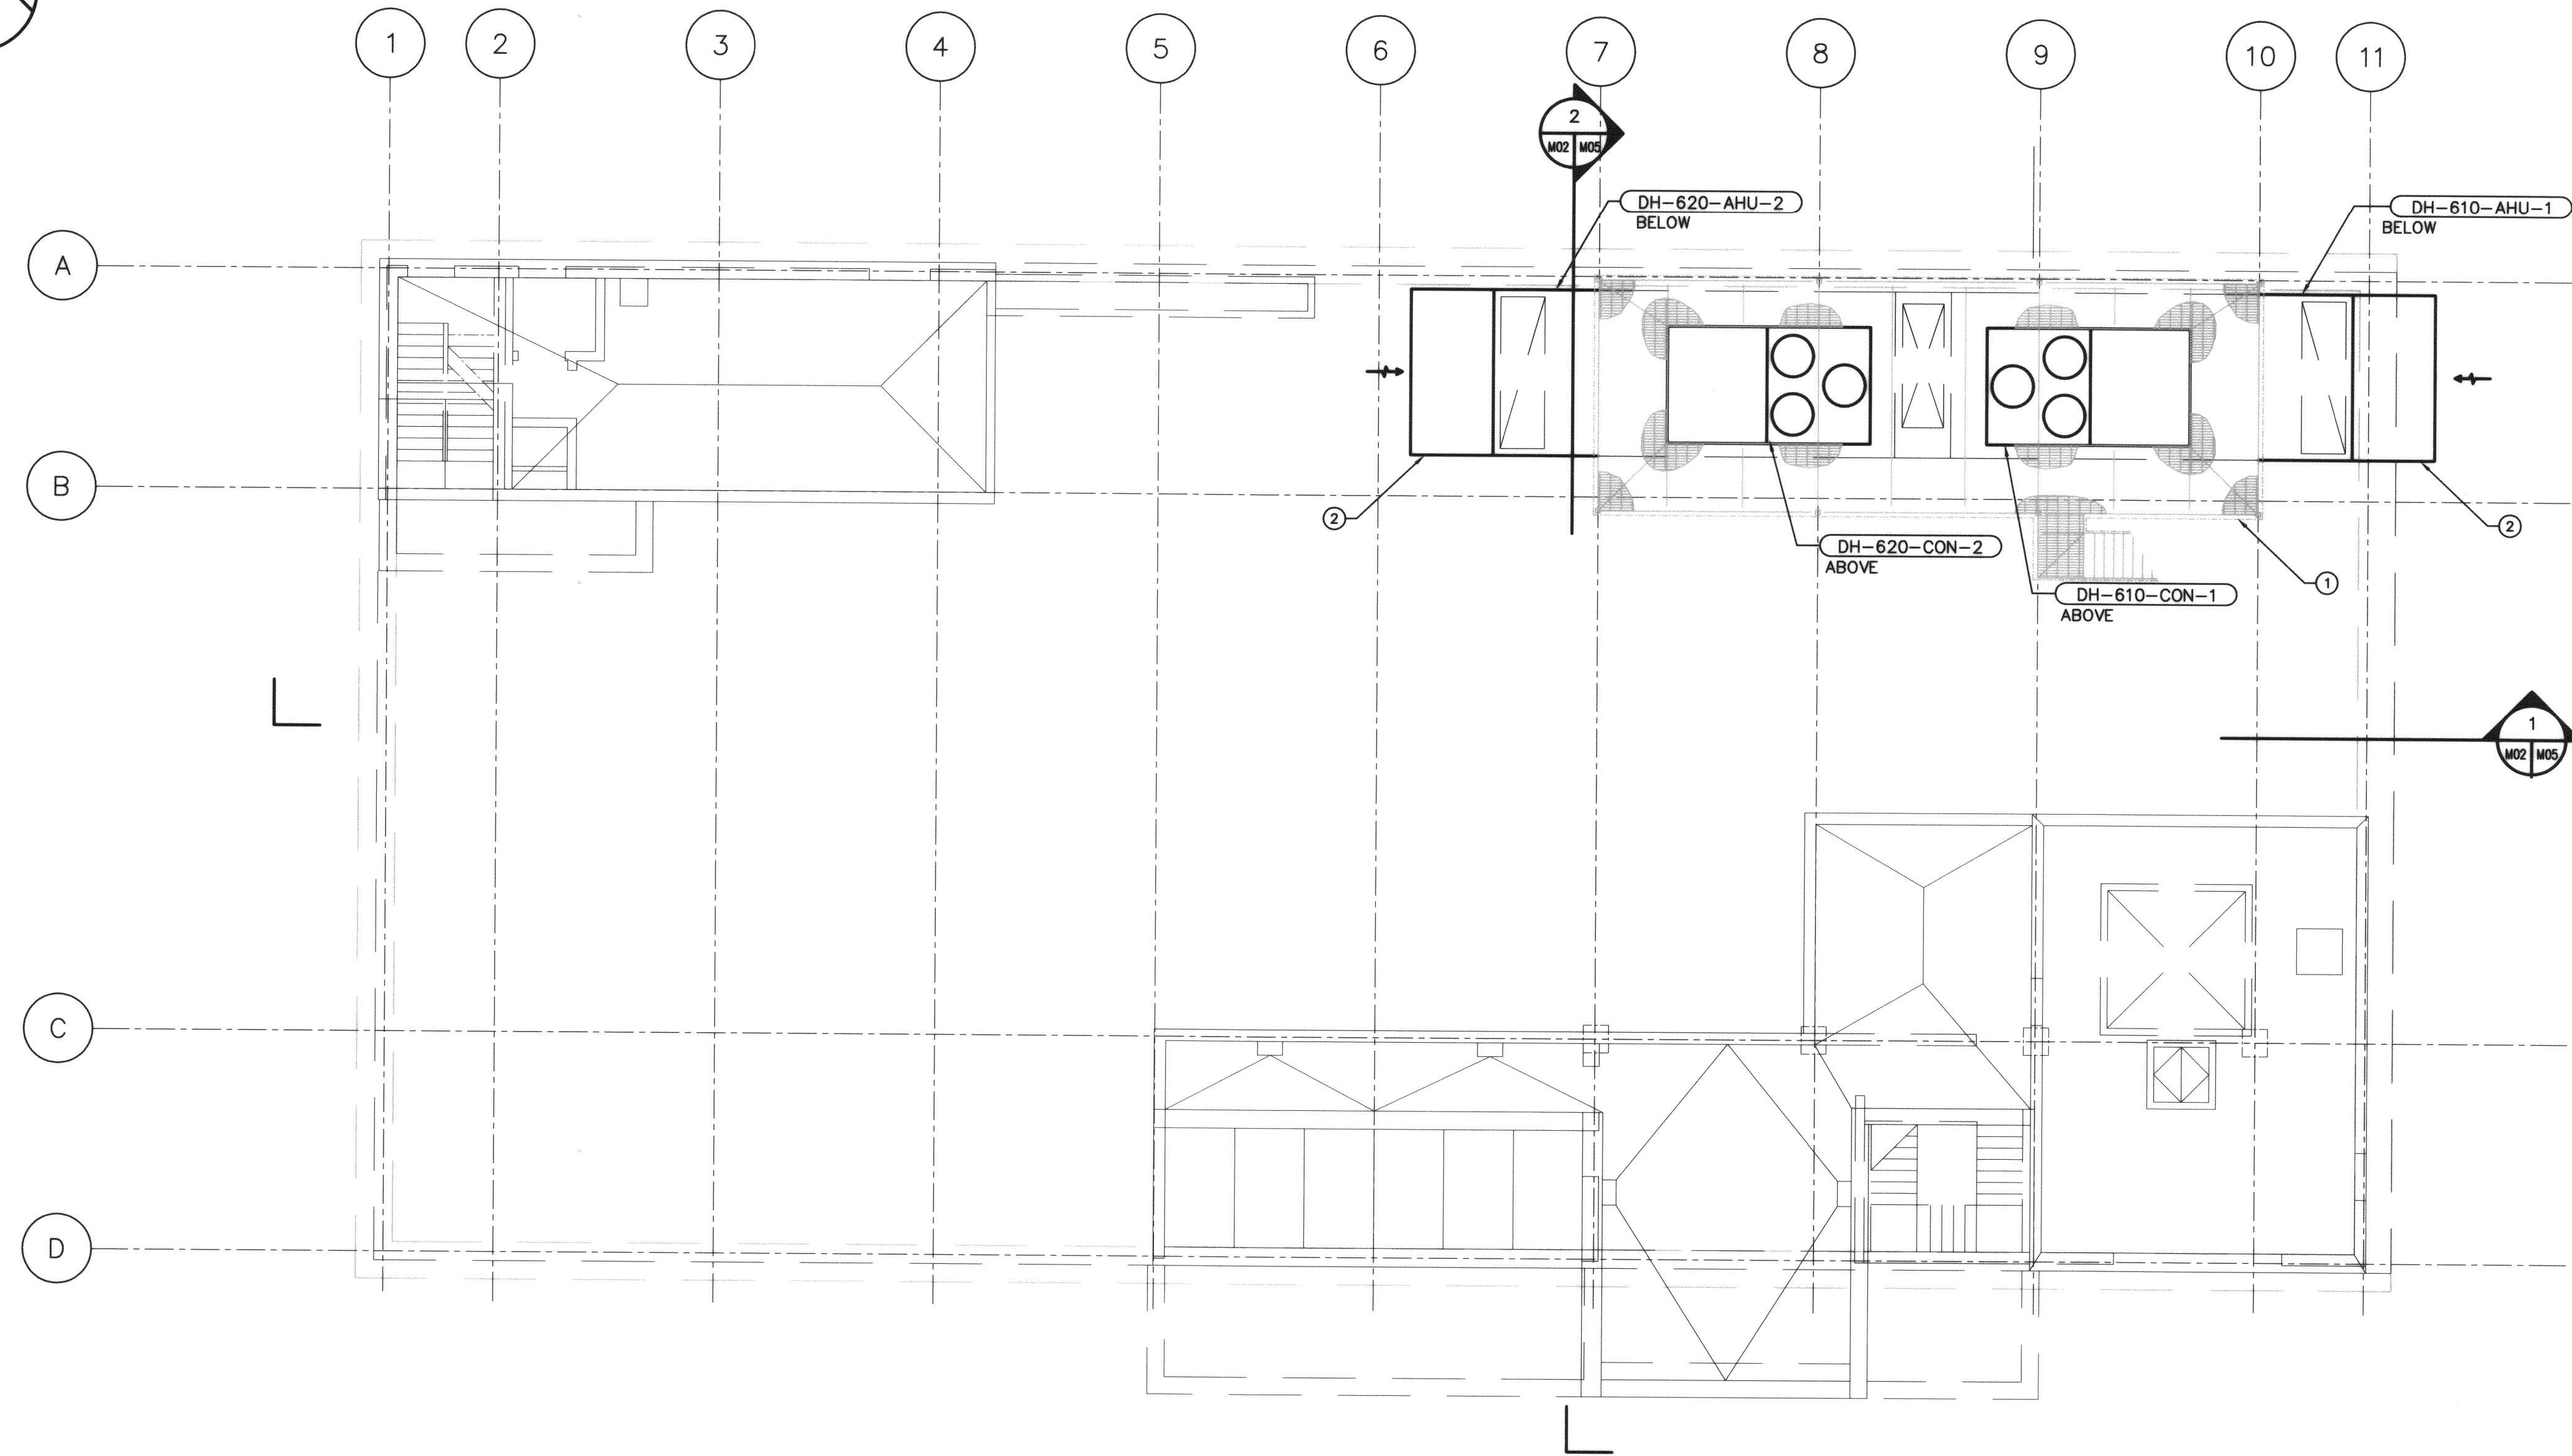


SHEET: 048-41 (1/2003)

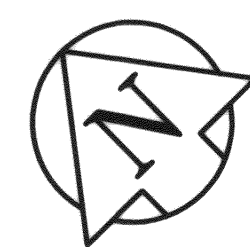

DRAWING NOTES

- ① SEE DRAWINGS S20, S21 AND S22 FOR PLATFORM DETAILS.
- ② OUTSIDE AIR HOOD. TYPICAL FOR EACH AIR HANDLING UNIT.

GENERAL NOTES

- 1. COORDINATE ROUTING OF REFRIGERATION PIPING AND CONTROL WIRING BETWEEN AIR HANDLING UNITS AND CONDENSING UNITS WITH MANUFACTURER AND CONTRACT ADMINISTRATOR.
- 2. COORDINATE WITH OTHER TRADES SO AS TO PREVENT CONFLICTS.

MECHANICAL ROOF PLAN ABOVE EL. 236.500m
SCALE: 1:100



<p>B.M. ELEV.</p>	<p>EARTH TECH <small>Earth Tech (Canada) Inc. Winnipeg, Manitoba (914.677.2266)</small></p>	<p>CH2MHILL</p>	<p>ENGINEER'S SEAL A. M. AFTANAS REGISTERED PROFESSIONAL ENGINEER </p>	<p>THE CITY OF WINNIPEG Winnipeg WATER AND WASTE DEPARTMENT</p>	<p>CITY FILE NUMBER</p>
	DESIGNED BY: JDB	CHECKED BY: AMA		<p>DEACON ULTRAVIOLET (UV) LIGHT DISINFECTION PROJECT</p>	<p>SHEET 2 OF 7</p>
	DRAWN BY: DC, DL	APPROVED BY: D.T.		<p>MECHANICAL - HVAC UPGRADE ROOF PLAN ABOVE EL. 236.500m</p>	<p>CITY DRAWING NUMBER D-8420</p>
	HOR. SCALE: AS SHOWN	RELEASED FOR CONSTRUCTION BY:		<p>CONSULTANT DRAWING NO. 63672-C5-M02</p>	
0 ISSUED FOR TENDER	03/12/12	DL			
NO. REVISIONS	DATE	BY	DATE	2003/11/17	