



UV DISTRIBUTION PLAN
SCALE: 1:20



UV DISTRIBUTION FRONT ELEVATION
SCALE: 1:20

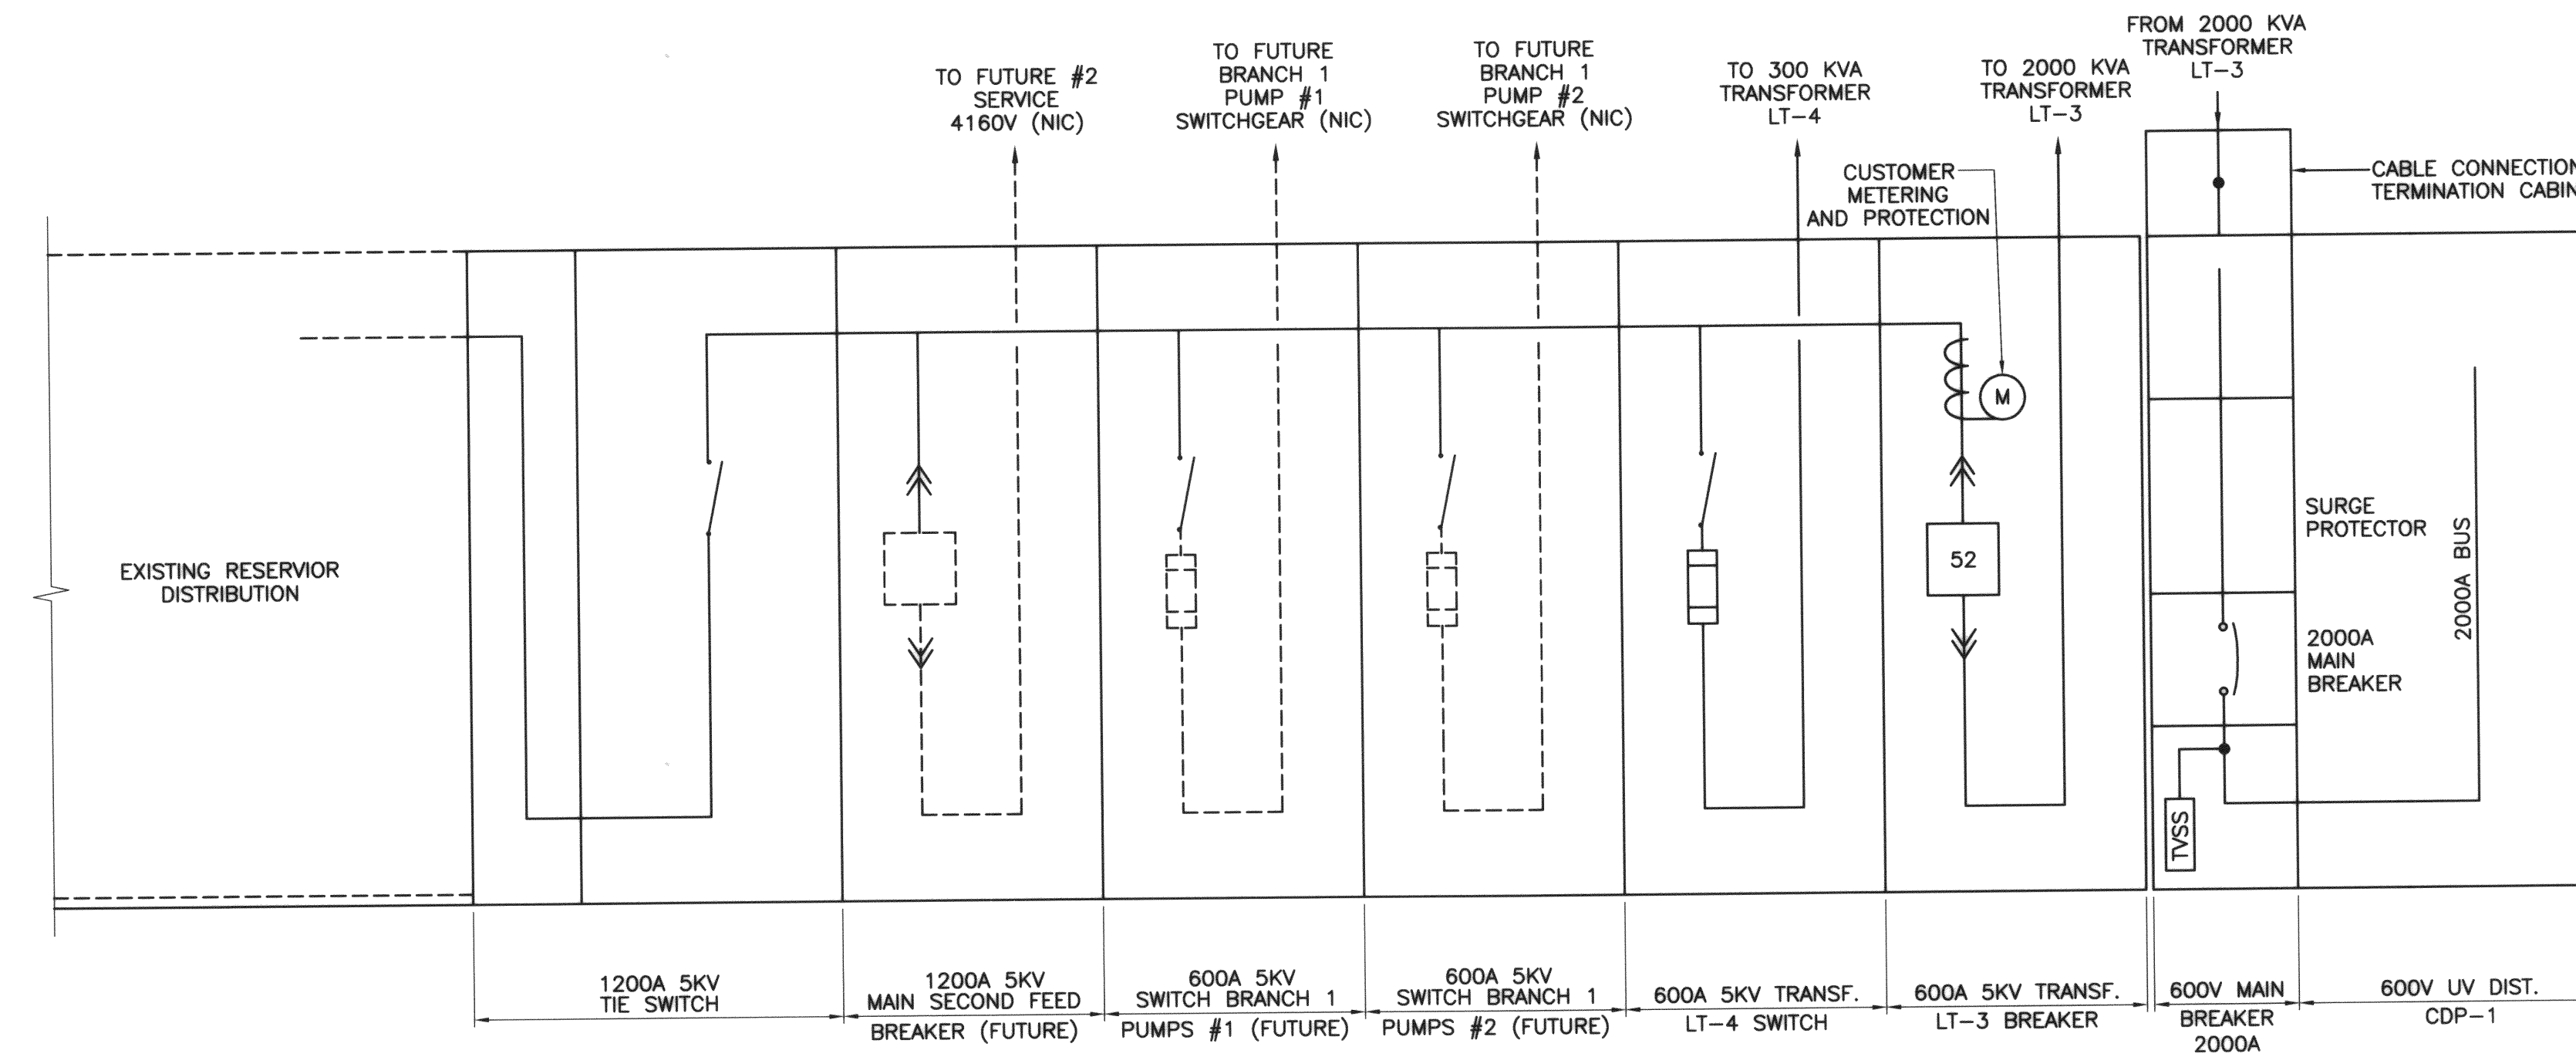

B.M. ELEV.							
EARTH TECH		CH2MHILL		DESIGNED BY: GSN		CHECKED BY: SWT	
DRAWN BY: DS		APPROVED BY: D.T.		HOR. SCALE: NTS		RELEASED FOR CONSTRUCTION BY:	
NO. REVISIONS		DATE		DATE		DATE	
0 ISSUED FOR TENDER		03/12/12 DC		2003/11/18			

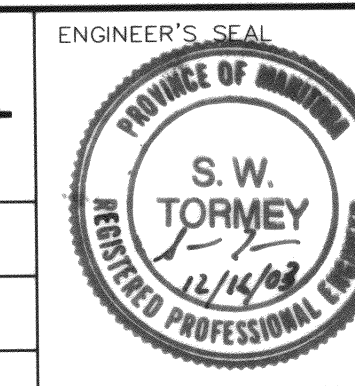

THE CITY OF WINNIPEG
Winnipeg WATER AND WASTE DEPARTMENT

DEACON ULTRAVIOLET (UV) LIGHT DISINFECTION PROJECT

ELECTRICAL - UV INSTALLATION
DISTRIBUTION EQUIPMENT PLAN AND ELEVATION

CITY FILE NUMBER
SHEET 2 OF 7
CITY DRAWING NUMBER
D-8431

CONSULTANT DRAWING NO.
63672-C5-E02