
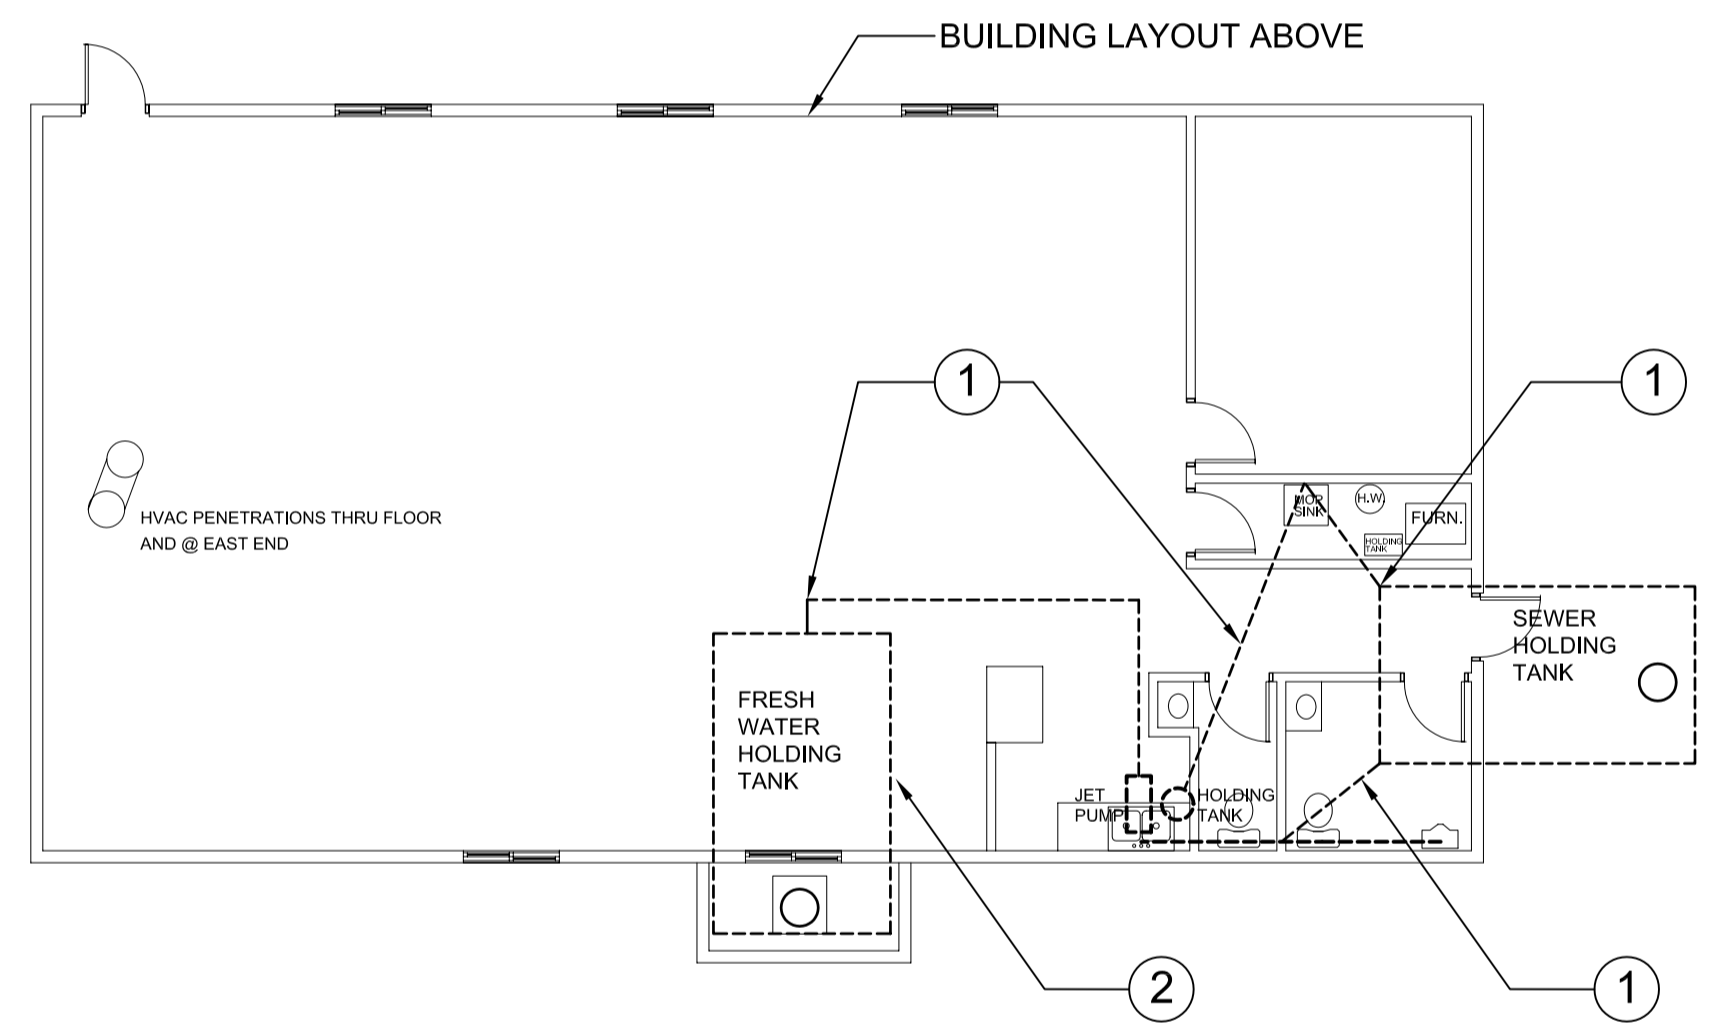
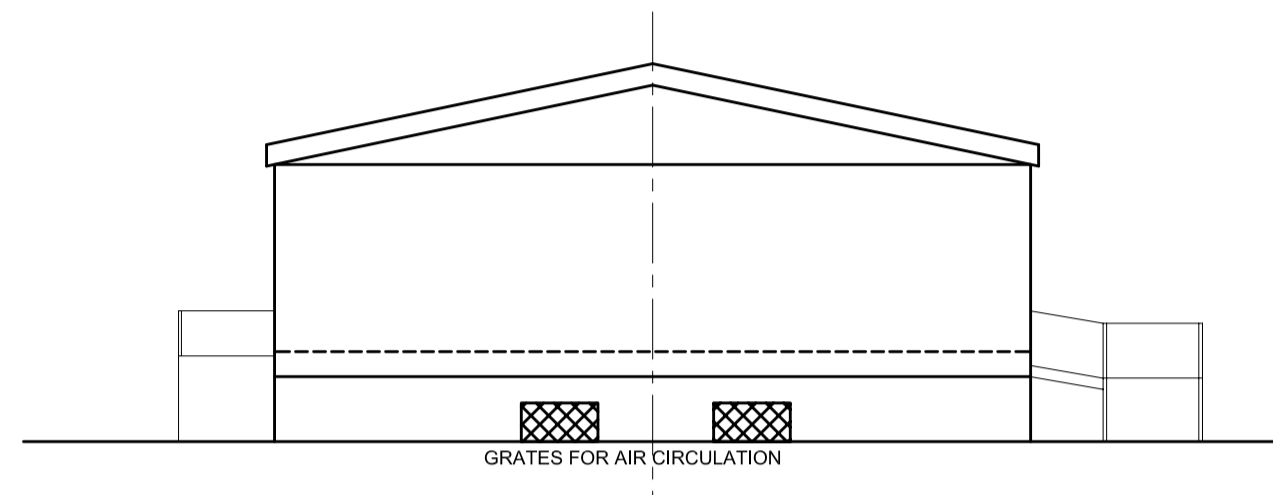
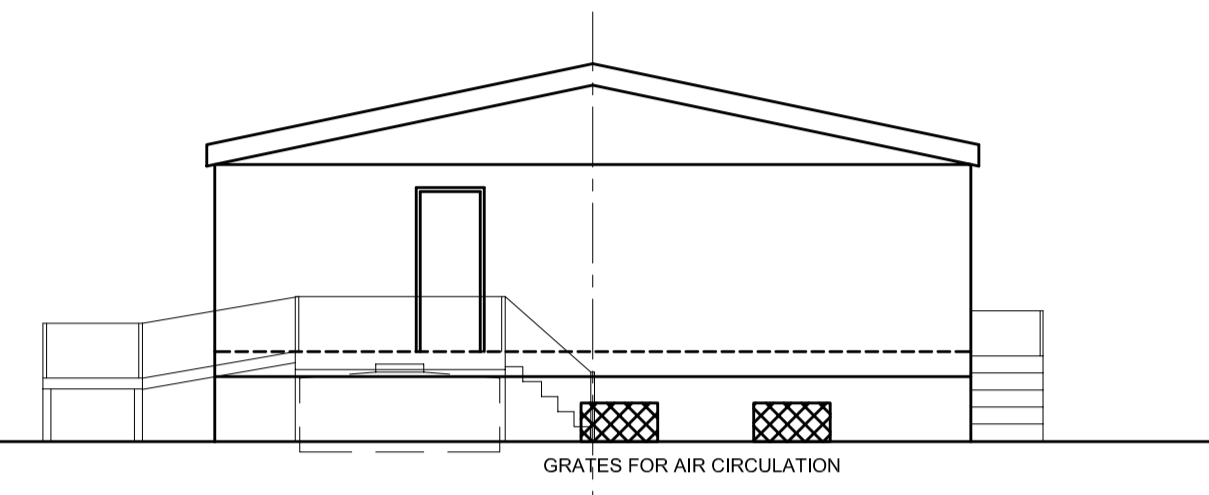


File Name: 2003067/01M1.dwg
 Date: 2004.06.14
 Description: Mech. Plan & Elevations
 Project No.: 2003-067
 Address: 341 Cadboro Rd.

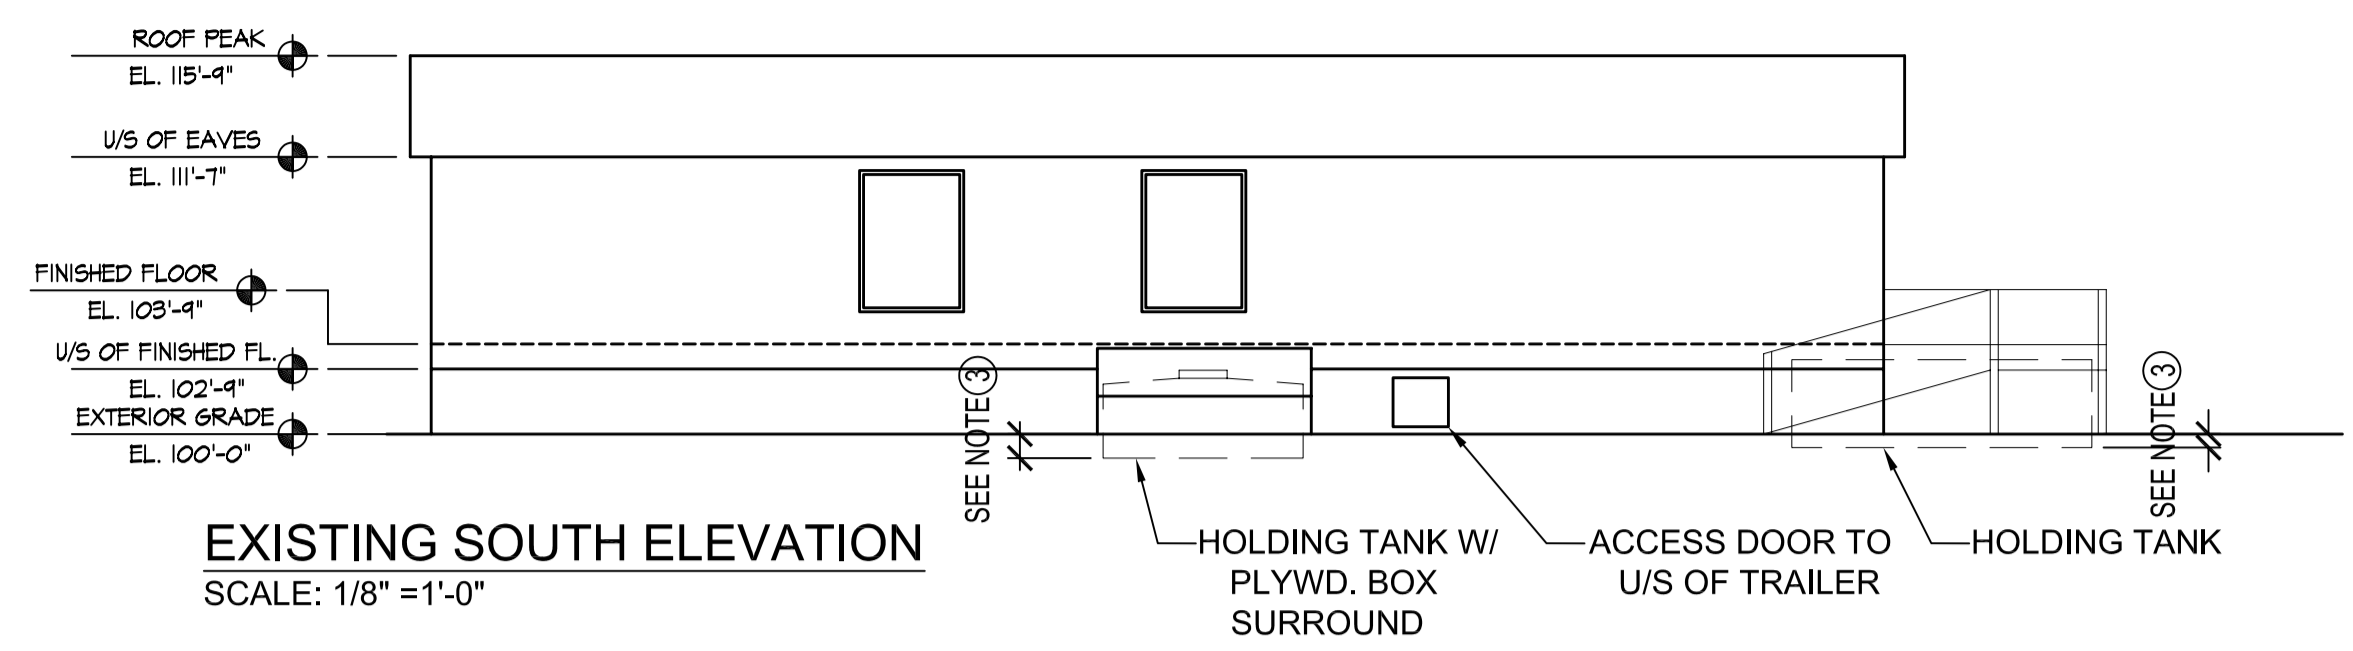

- HVAC & PLUMBING NOTES**
- ① PROVIDE NEW DRAIN & PUMP LINES & CONNECTORS AND CONNECT TO NEWLY RELOCATED BUILDING & HOLDING TANKS AS REQUIRED.
 - ② FRESH WATER HOLDING TANK TO BE ISOCYANURATE INSULATED.
 - ③ TANKS ARE LOCATED BELOW GRADE ON COMPACTED BASE. DEPTH TO BE DETERMINED

PLAN -NEW PLUMBING & HVAC RECONNECTIONS
 SCALE: 1/8" = 1'-0"

- NOTES :**
1. THE CONTRACTOR SHALL VISIT THE SITE AND SATISFY ONESELF THAT ALL DIMENSIONS, DATUM AND DETAILED INFORMATION SHOWN ARE CORRECT.
 2. ALL PRODUCTS AND MATERIALS TO BE USED AND INSTALLED SHALL CONFORM WITH MANUFACTURER'S SPECIFICATIONS AND ALL WORK SHALL BE DONE TO APPLICABLE CODES.
 3. THE CONTRACTOR SHALL BE RESPONSIBLE TO PATCH AND MAKE GOOD ALL EXISTING CONSTRUCTION AFFECTED BY THE REMOVAL OF ALL ITEMS FORMING THE PART OF THE RENOVATION WORK.

ORIGINAL SEALED BY:
 D.A. Paley P. Eng.
 Date: 2004/06/18

NO.	REVISION/DESCRIPTION	BY	DATE

DRAWN BY	CHECKED BY	APPROVED
MMK		
DATE	2004.06.14	USER APPROVAL

CITY OF WINNIPEG
 PLANNING, PROPERTY &
 DEVELOPMENT DEPARTMENT
 CIVIC ACCOMMODATIONS DIVISION
 300 - 65 GARRY ST. R3C 4K4

PROJECT
**Wpg. Police Services -Bridgewater Park
 Foundation Upgrading**
 341 CADBORO ROAD -Police Firing Range

SHEET TITLE
Mechanical Plan & Elevations

SCALE	PROJECT NO.	SHEET NO.
Noted	2003-067	M-1