



**1** WALL SECTION  
A103 A104 1 : 10

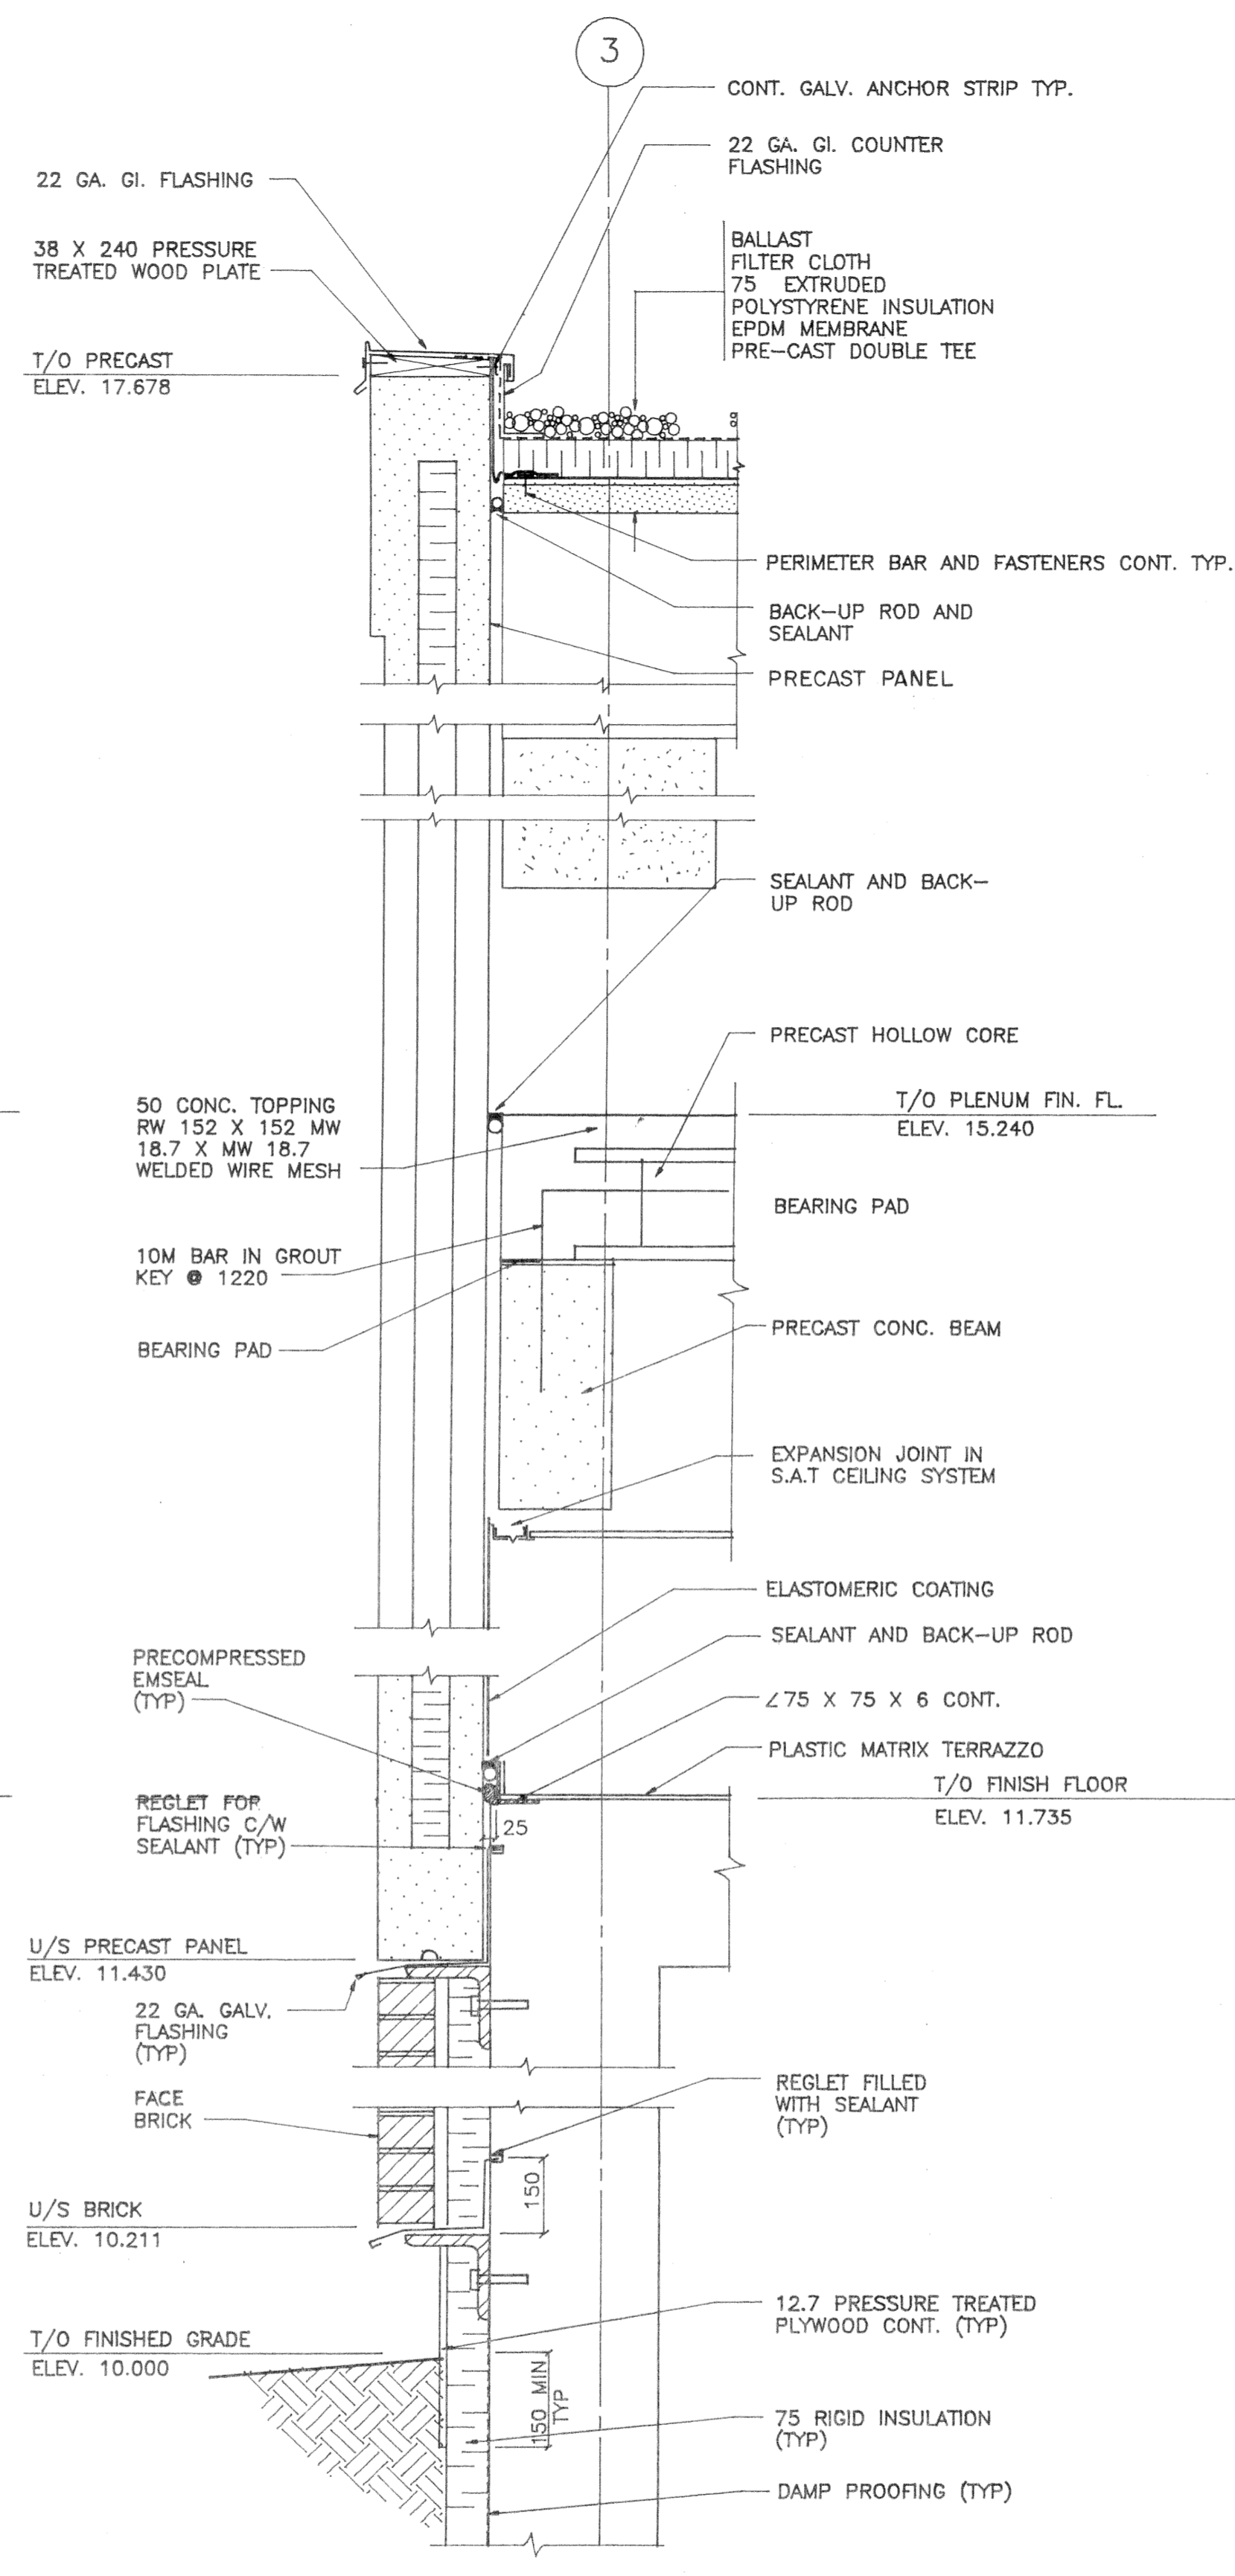

**2** WALL SECTION  
A102 A104 1 : 10

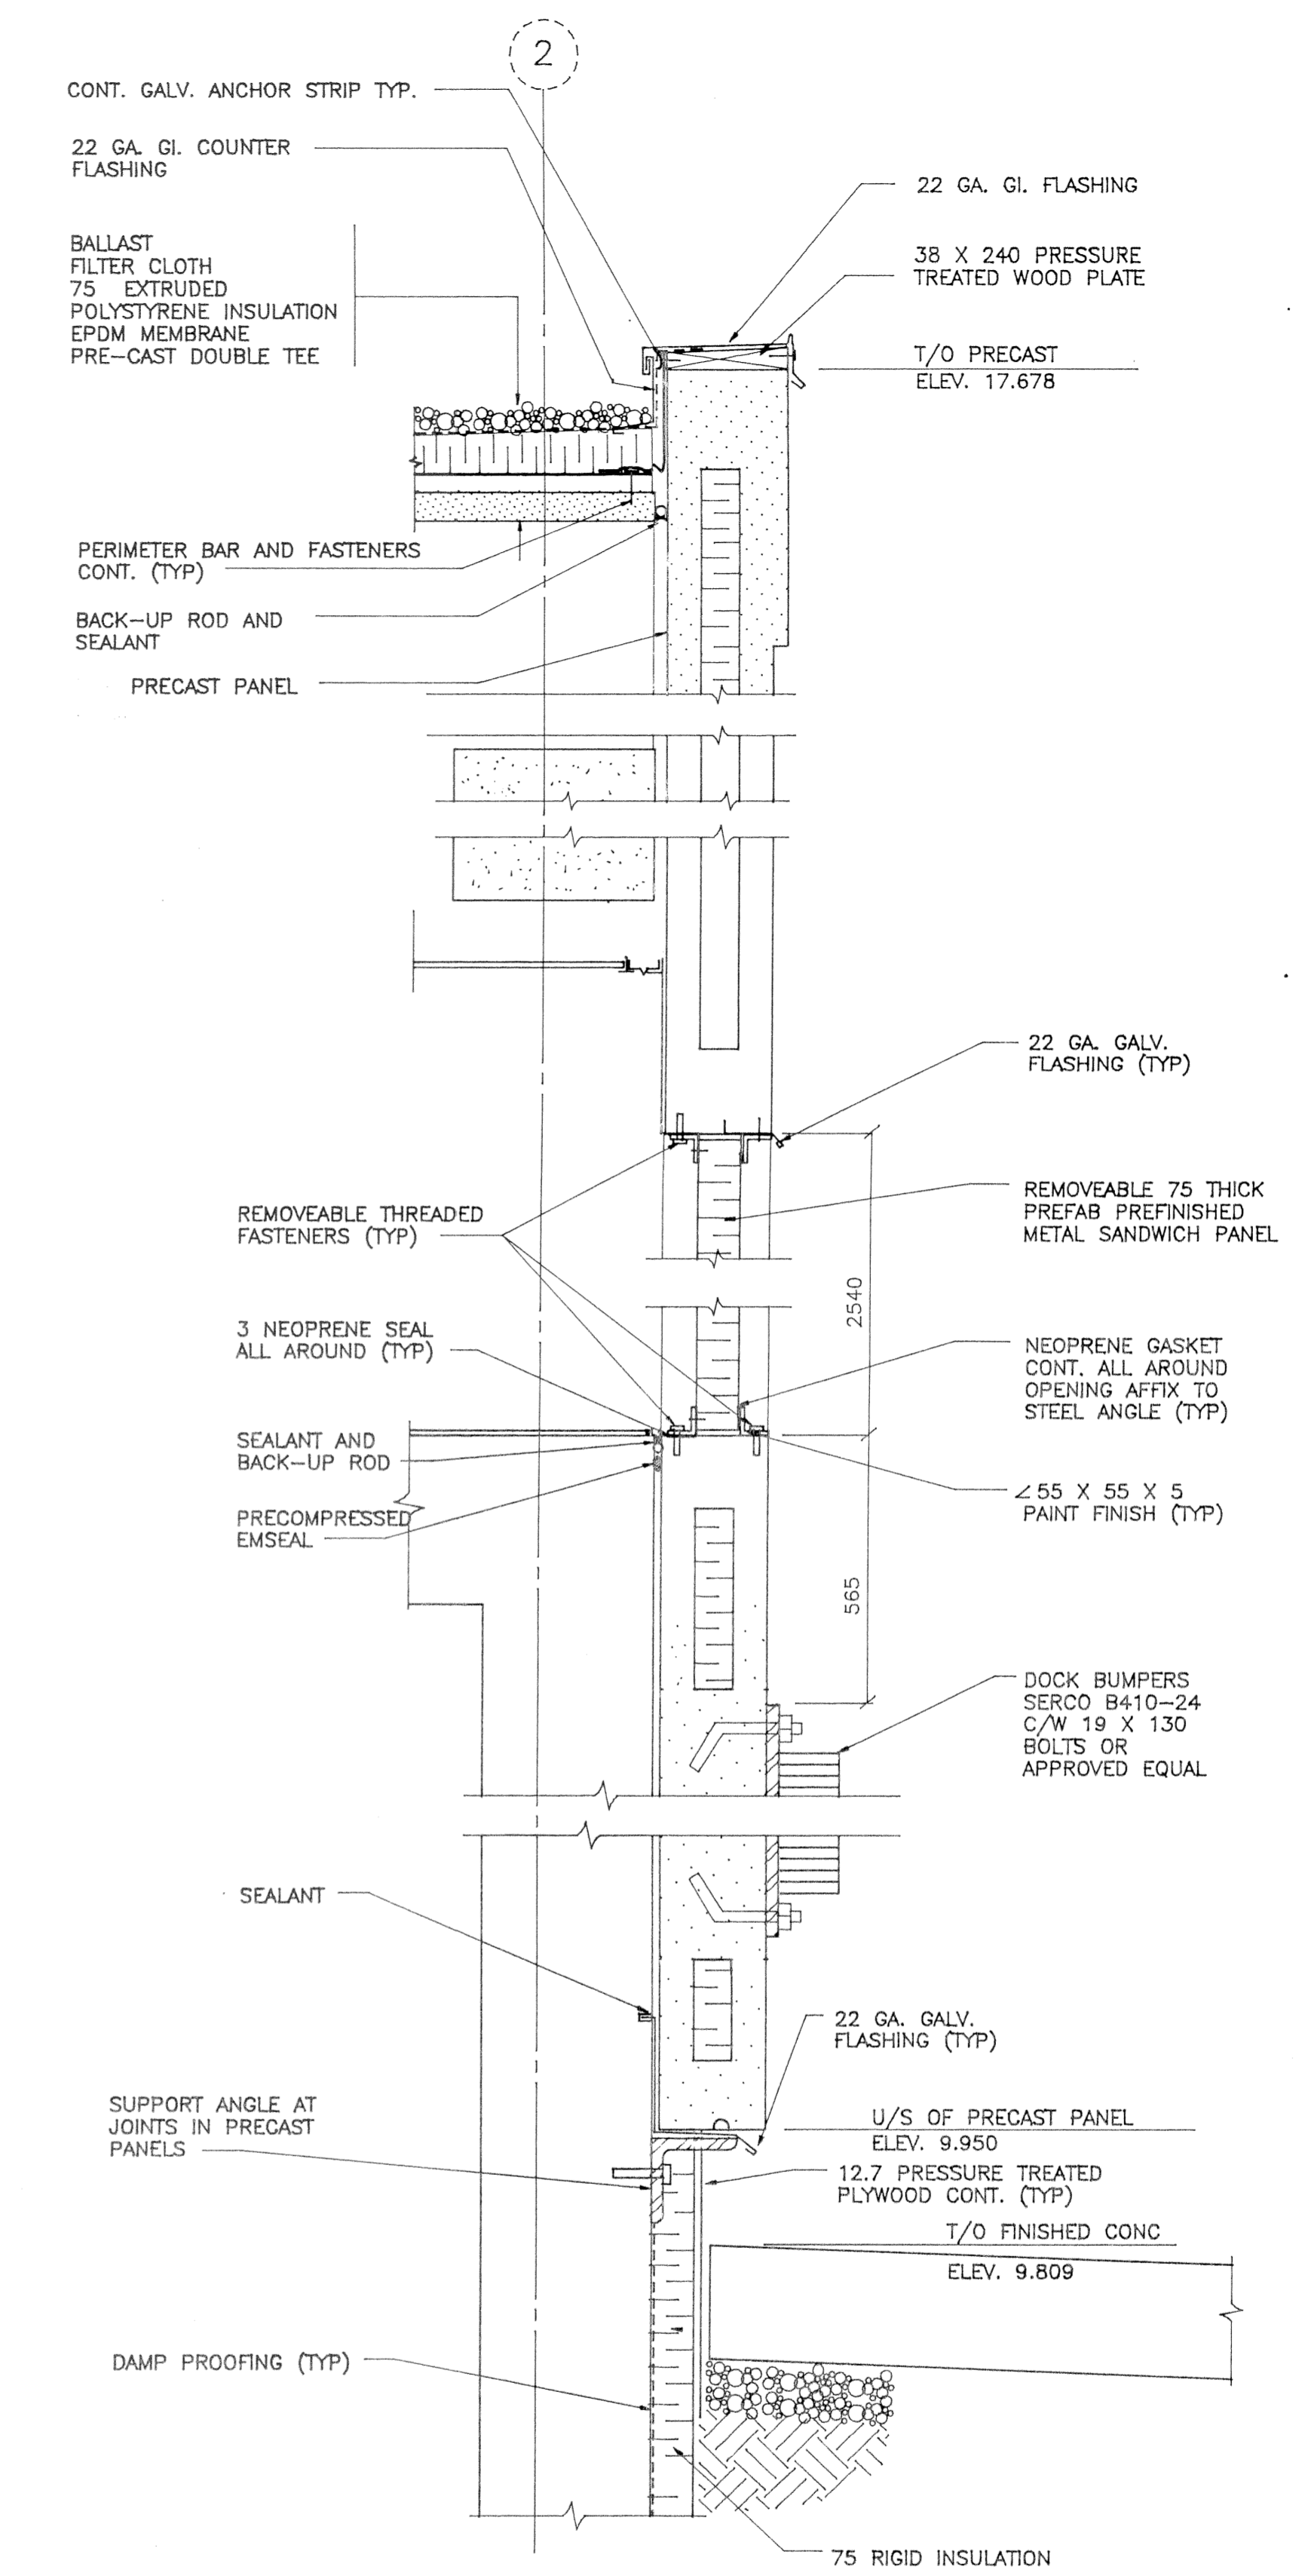

**3** WALL SECTION  
A103 A104 1 : 10

APPROVED  
DATE  
CHECKED BY

<p><b>Wardrop-MacLaren</b> ENGINEERING CONSULTANTS</p>		<p>ENGINEERS <b>C. D. STEWART</b> REGISTERED ENGINEER</p>		<p><b>THE CITY OF WINNIPEG</b> WORKS AND OPERATIONS DIVISION WATERWORKS, WASTE AND DISPOSAL DEPARTMENT</p>	
DESIGNED BY	DRM	CHECKED BY	<i>M. August</i>	<p>NORTH END WATER POLLUTION CONTROL CENTRE PRE-TREATMENT BUILDING - ARCHITECTURAL</p>	
DRAWN BY	GRA	APPROVED BY	<i>R. Stewart</i>	<p>WALL SECTIONS</p>	
DATE	SEPTEMBER 1988	RELEASED BY	<i>R. Stewart</i>	<p>NEP 1555</p>	
REVISIONS	1 AS CONSTRUCTED AUG 88	DATE	SEPT. 19, 1988	<p>870012-05-02-A104</p>	
	0 ISSUED FOR TENDER AUG 88			<p>NR11743</p>	

NEP-1555