

ACCESSORIES LIST

Code	Item	Manufacturer	Model No.	Remarks
A	Fold Down Change Table	Bobriok	B2210	Mtd. @900mm a.f.f.
B	Channel Frame Mirror	Bobriok Frost Various	B-200 Series 041 VW-0620-A Series	Tempered glass, 30" High, full length of counter.
C	Napkin Dispenser	Bobriok Frost	B-2800 VW-0884	Dispenses both products, s.s. finish. Wall-mounted.
D	Toilet Tissue Dispenser, Jumbo-roll	Bobriok Frost	B-2802 168	9" dual-roll, s.s. finish. 13" single-roll, white epoxy finish. Surface-mounted.
E	Sanitary Napkin Disposal	Bobriok Frost	B-271 VW-0652-5H	c.u. integral shelf
F	Electric Hand Dryer	Bobriok Frost	B-706 1181	Surface mounted
G	Liquid Soap Dispenser	Frost Bobriok Various	B-8220	Millwork mounted
H	Grab Bar	Bobriok Frost	B-5909 1001D	Rein. grip. Refer to interior elevations & details for locations. 600mm long behind toilet; 8' over urinals, 900mm wide beside toilet.
I	Robe Hook	Bobriok Frost	B-6707 1138-SS	Surface-mounted @1400 A.F.F.
J	Towel Dispenser	Frost Bobriok	103-1 B-263-180	Standard single-fold and roll

ACCESSORIES SCHEDULE

Room No.	Room Name	Accessories Code	Remarks
100	M.P.R.		
101	Corridor		
102	Corridor		
103	Kitchen	O, J	
104	Bar	J	
105	Female Washroom	A, B, G, D, E, F, O, H, I, K	
106	Male Washroom	A, D, F, O, H, I, K	
107	Storage Rm.		
108	Mechanical Rm.		
109	Mechanical Rm.		


ROOM FINISH SCHEDULE

Room	Floor	Walls	Ceiling	Remarks
100	Polished Concrete	C.M.C. / C.F.	C.M.C. / C.F.	See Schedule of Ceiling Plan for locations.
101	Concrete	C.M.C. / C.F.	C.M.C. / C.F.	See Schedule of Ceiling Plan for locations.
102	Concrete	C.M.C. / C.F.	C.M.C. / C.F.	See Schedule of Ceiling Plan for locations.
103	Concrete	C.M.C. / C.F.	C.M.C. / C.F.	See Schedule of Ceiling Plan for locations.
104	Concrete	C.M.C. / C.F.	C.M.C. / C.F.	See Schedule of Ceiling Plan for locations.
105	Concrete	C.M.C. / C.F.	C.M.C. / C.F.	See Schedule of Ceiling Plan for locations.
106	Concrete	C.M.C. / C.F.	C.M.C. / C.F.	See Schedule of Ceiling Plan for locations.
107	Concrete	C.M.C. / C.F.	C.M.C. / C.F.	See Schedule of Ceiling Plan for locations.
108	Concrete	C.M.C. / C.F.	C.M.C. / C.F.	See Schedule of Ceiling Plan for locations.
109	Concrete	C.M.C. / C.F.	C.M.C. / C.F.	See Schedule of Ceiling Plan for locations.


DOOR SCHEDULE

No.	View	Door	Material	Finish	Frame	ULC	Glass	Hardware	Remarks
101	2'-10 1/2" x 2'-10 1/2"	B	ALU W/SL	ALU D	2	ALU W/SL	ALU D	-	See Spec. (Door sizes to suit cabinet wall)
102	2'-10 1/2" x 2'-10 1/2"	B	ALU W/SL	ALU D	2	ALU W/SL	ALU D	-	See Spec. (Door sizes to suit cabinet wall)
103	3'-6" x 2'-6"	A	ALU W/SL	ALU D	1	ALU W/SL	ALU D	-	See Spec. (Door sizes to suit cabinet wall)
104	3'-6" x 2'-6"	A	ALU W/SL	ALU D	1	ALU W/SL	ALU D	-	See Spec. (Door sizes to suit cabinet wall)
105	3'-6" x 2'-6"	A	ALU W/SL	ALU D	1	ALU W/SL	ALU D	-	See Spec. (Door sizes to suit cabinet wall)
106	3'-6" x 2'-6"	A	ALU W/SL	ALU D	1	ALU W/SL	ALU D	-	See Spec. (Door sizes to suit cabinet wall)
107	3'-6" x 2'-6"	A	ALU W/SL	ALU D	1	ALU W/SL	ALU D	-	See Spec. (Door sizes to suit cabinet wall)
108	3'-6" x 2'-6"	A	ALU W/SL	ALU D	1	ALU W/SL	ALU D	-	See Spec. (Door sizes to suit cabinet wall)
109	3'-6" x 2'-6"	A	ALU W/SL	ALU D	1	ALU W/SL	ALU D	-	See Spec. (Door sizes to suit cabinet wall)

DOOR TYPES

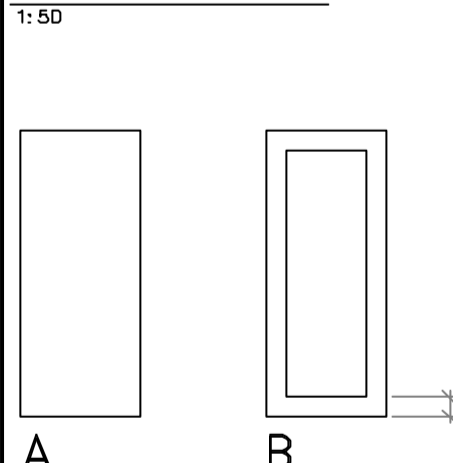


DOOR FRAME TYPES

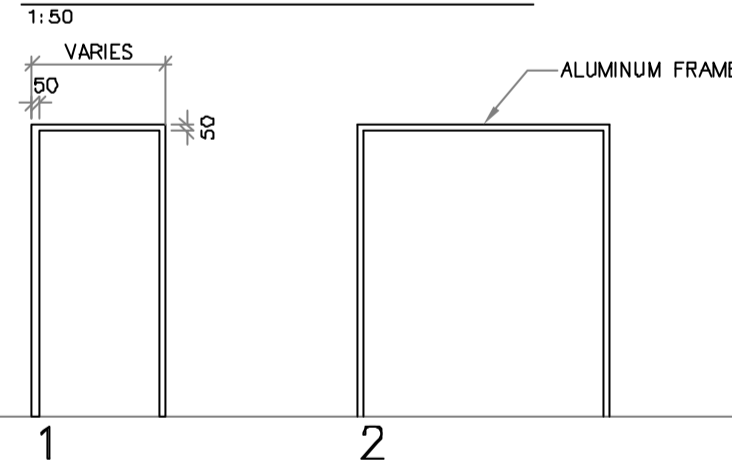


EQUIPMENT SCHEDULE

ITEM DESCRIPTION	ELECTRICAL				PLUMBING			PROPANE		COMMENTS
	VOLTS	PH	AMPS	LOAD	HOT	COLD	WASTE	BTU		
1 HAND SINK (QUANTITY OF 2)					12.7	12.7	38.1			
2 STAINLESS STEEL PREP TABLE (QTY OF 2)										
3 WALL SHELVES										
4 3 COMPARTMENT SINK WITH GRABBOARD					12.7	12.7	50.8			
5 STAINLESS STEEL CLEAN DISH TABLE										
6 DISHWASHER	208/240	3	23.9	1 HP	19.05		50.8			
BUILT-IN BOOSTER FOR ITEM 6	208	3	36.1	13KW	19.05					
7 PRE-RINSE SINK C/W PRE-RINSE FAUCET ASSEMBLY					12.7	12.7	38.1			
8 STAINLESS STEEL DIRTY DISH TABLE										
9 RACK SHELF										
10 ICE MACHINE	115	1	15.2		6.35+15.88		DRN TO HUB			
11 CONDENSATE HOOD										
12 WIRE SHELVING										
13 SINGLE DOOR FREEZER	115	1	8.5	1/3 HP						
14 FRYER	208	3								
15 8 BURNER RANGE WITH 12" HOT TOP	120X2	1	3.4X2	1/3HPX2				248,000 60,000	10.0" WC 11" WG	2 CONVECTION OVENS
16 24" BROILER										
17 EXHAUST CANOPY										
18 WAITRESS PICK-UP SHELF W/ SHELVES BELOW										TENANT SUPPLIED ITEM
19 CASH										
20 UNDER COUNTER REF.	115	1	5	1/5 HP						
21 2 WELL STEAM TABLE	120	1	8	960W						
22 60" REF. SANDWICH TABLE (QTY OF 2)	115X2	1	6.5X2	1/4HPX2						
23 WAITRESS STATION										
24 WALK-IN COOLER	230	1	14	3/4 HP						
25 TWO DOOR COOLER	115	1	10.5	1/2 HP						
26 COCKTAIL STATION W/SINK					12.7	12.7	38.1+ HUB DRN			ISOLATED GROUND RECEPTACLE
27 DASH	120	1	15							
28 CAPPUCCINO	110	1	20	.12KW		9.5	HUB DRN			
29 COFFEE GRINDER	120	1	15							
30 GARBURATOR	208	1	4.5	1 1/4 HP		12.7	38.1			
31 SLICER	120	1	1	1/2 HP						
32 MIXER	120	1	1	1/2 HP						
33 COFFEE BREWER	120/208	1	30	3900W		12.7				

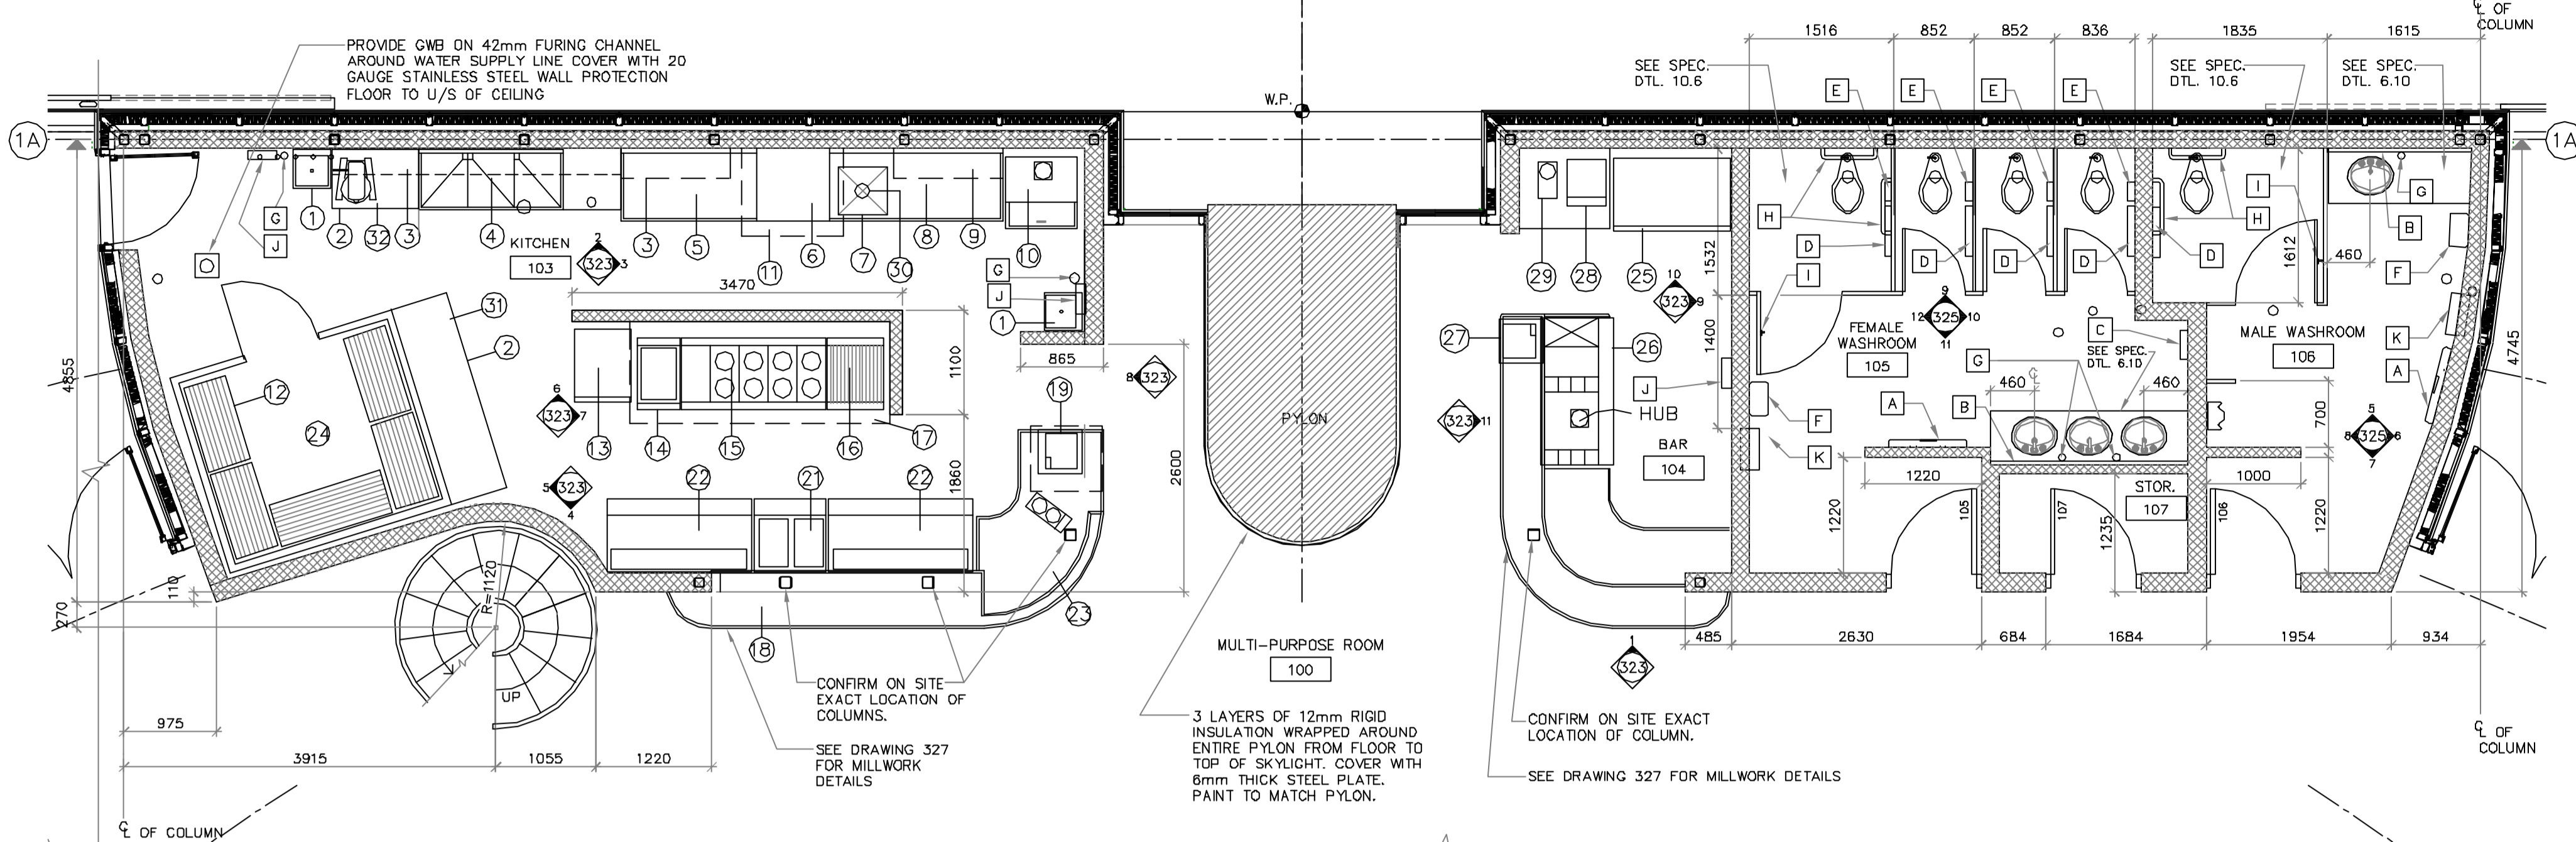

1 ENLARGED KITCHEN AND WASHROOM FLOOR PLANS

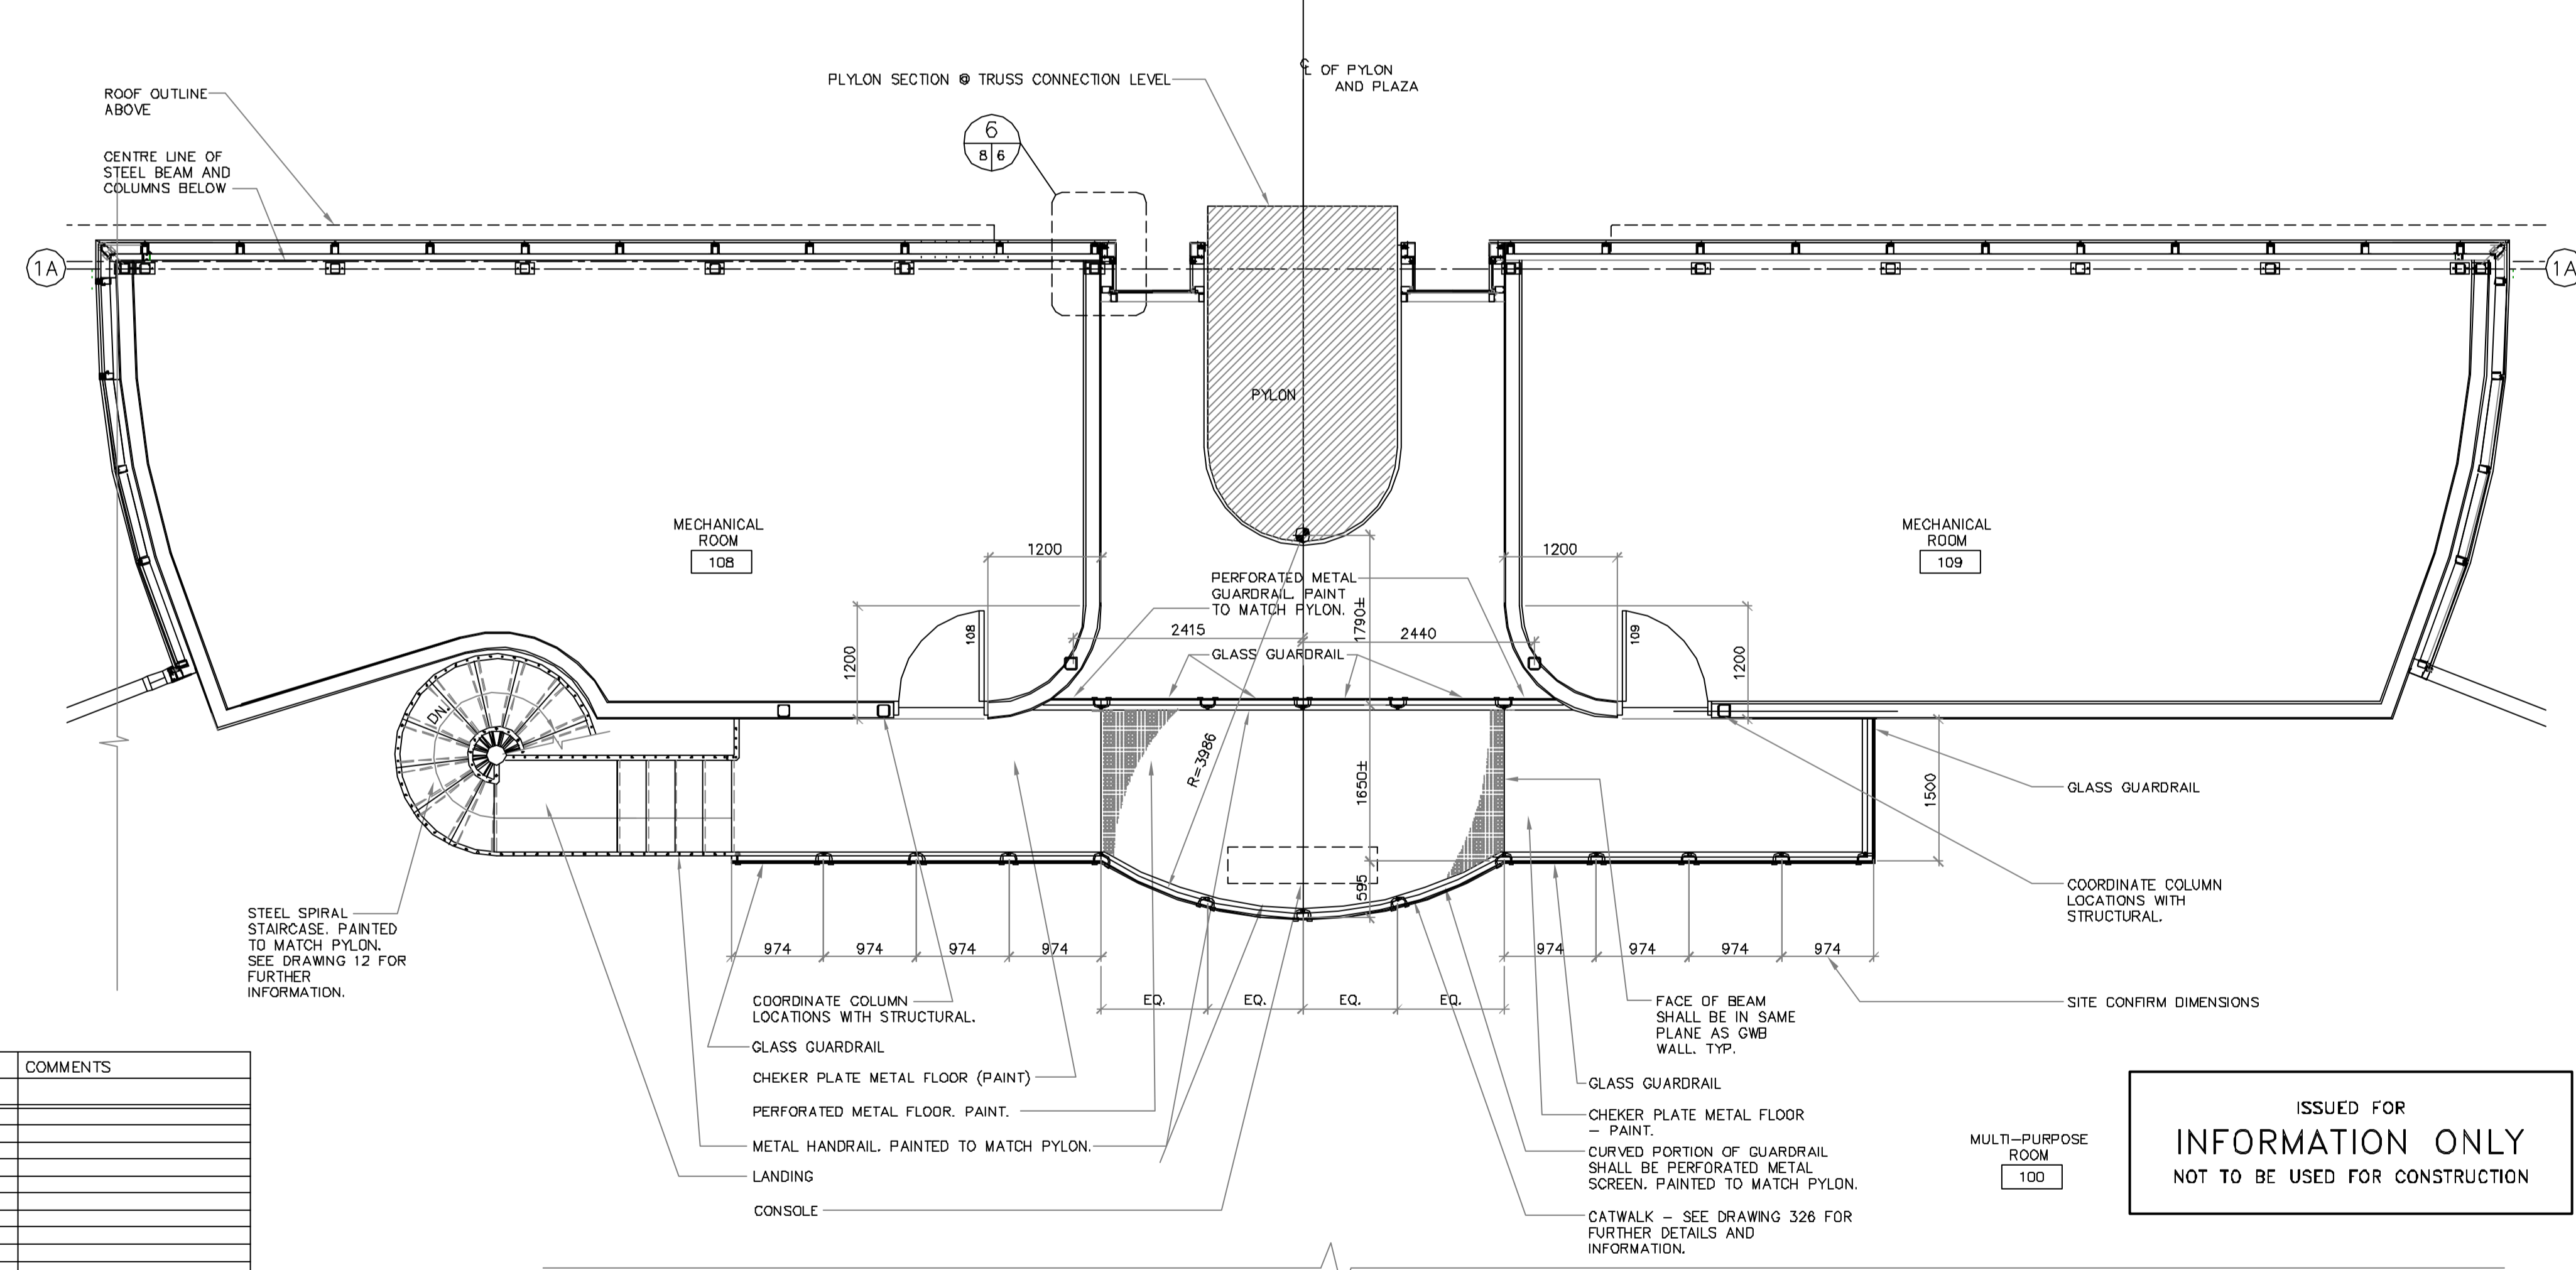

2 ENLARGED MECHANICAL ROOM FLOOR PLANS

Gaboury
Préfontaine
Perry
architect.e.s

WARDROP Engineering Inc.

DESIGNED BY: E.J.G. Y.L. CHECKED BY: E.J.G.

DRAWN BY: C.B. H.V. Y.L. APPROVED BY: R.V.G.

1 ISSUED FOR CONSTRUCTION 03.08.11 E.J.L.

0 ISSUED FOR PCN 25 03.07.24

NO. REVISIONS DATE BY

THE CITY OF WINNIPEG
PUBLIC WORKS DEPARTMENT
ENGINEERING DIVISION

PROVENCHER PAIRED BRIDGES PROJECT
PEDESTRIAN BRIDGE

CITY DRAWING NUMBER
SHEET OF

CENTRE PLAZA ENCLOSURE
ENLARGED PLANS, AND SCHEDULES

322

ISSUED FOR INFORMATION ONLY
NOT TO BE USED FOR CONSTRUCTION