



1 WALL SECTION  
A103 A104 1 : 10

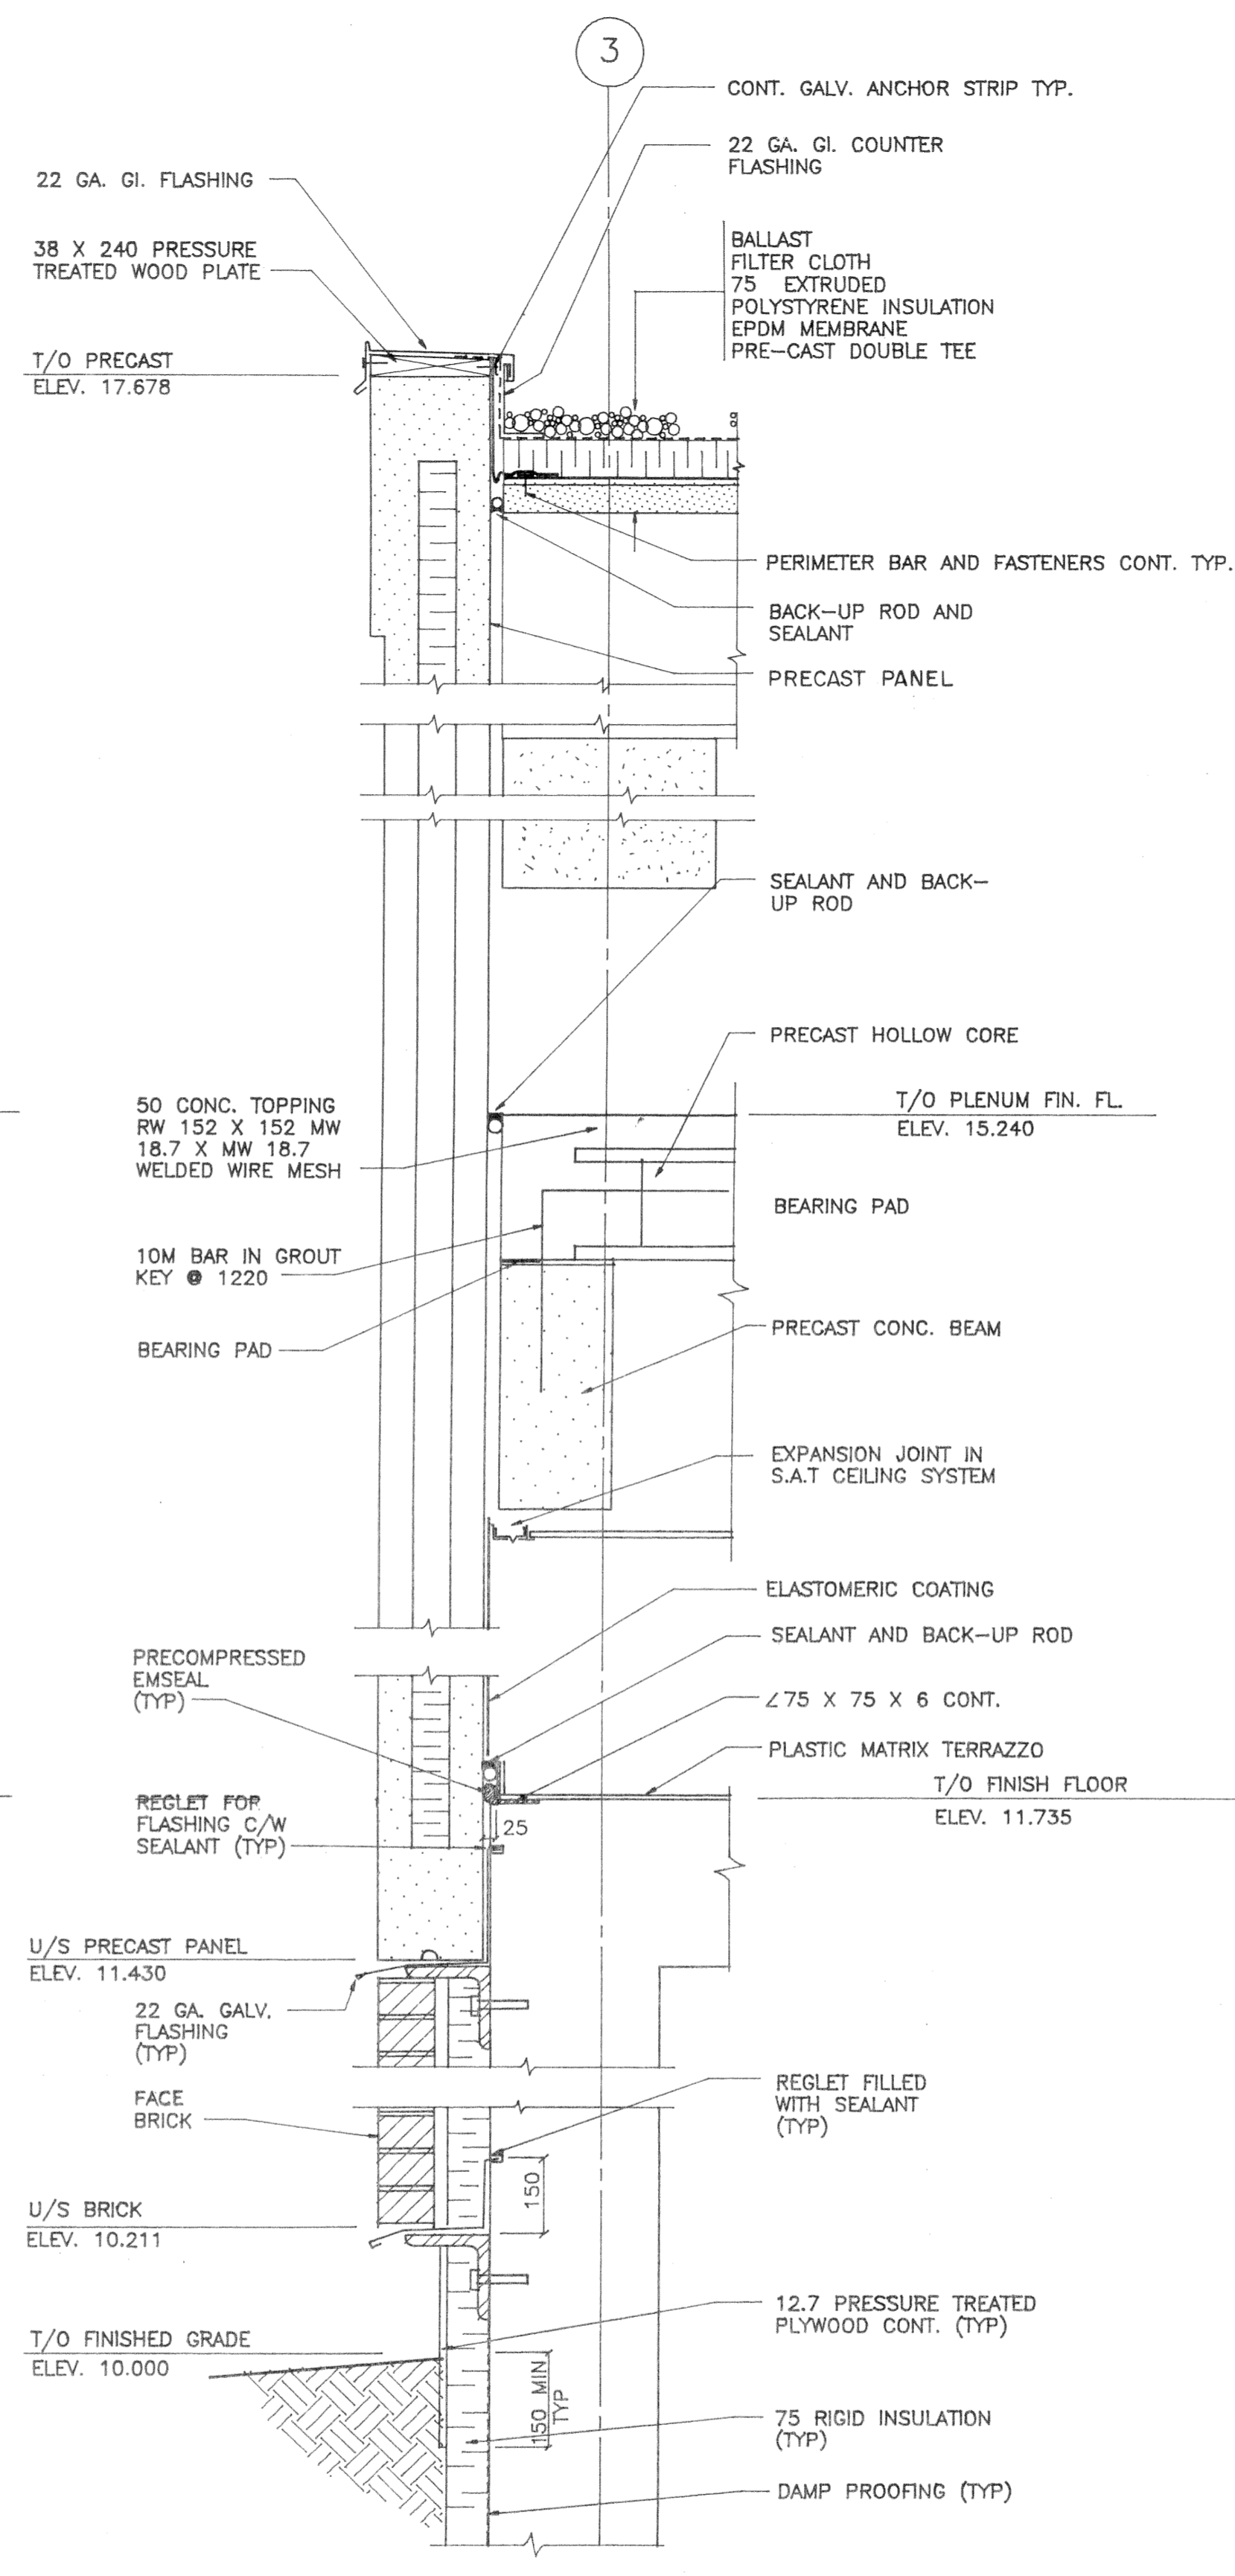

2 WALL SECTION  
A102 A103 A104 1 : 10

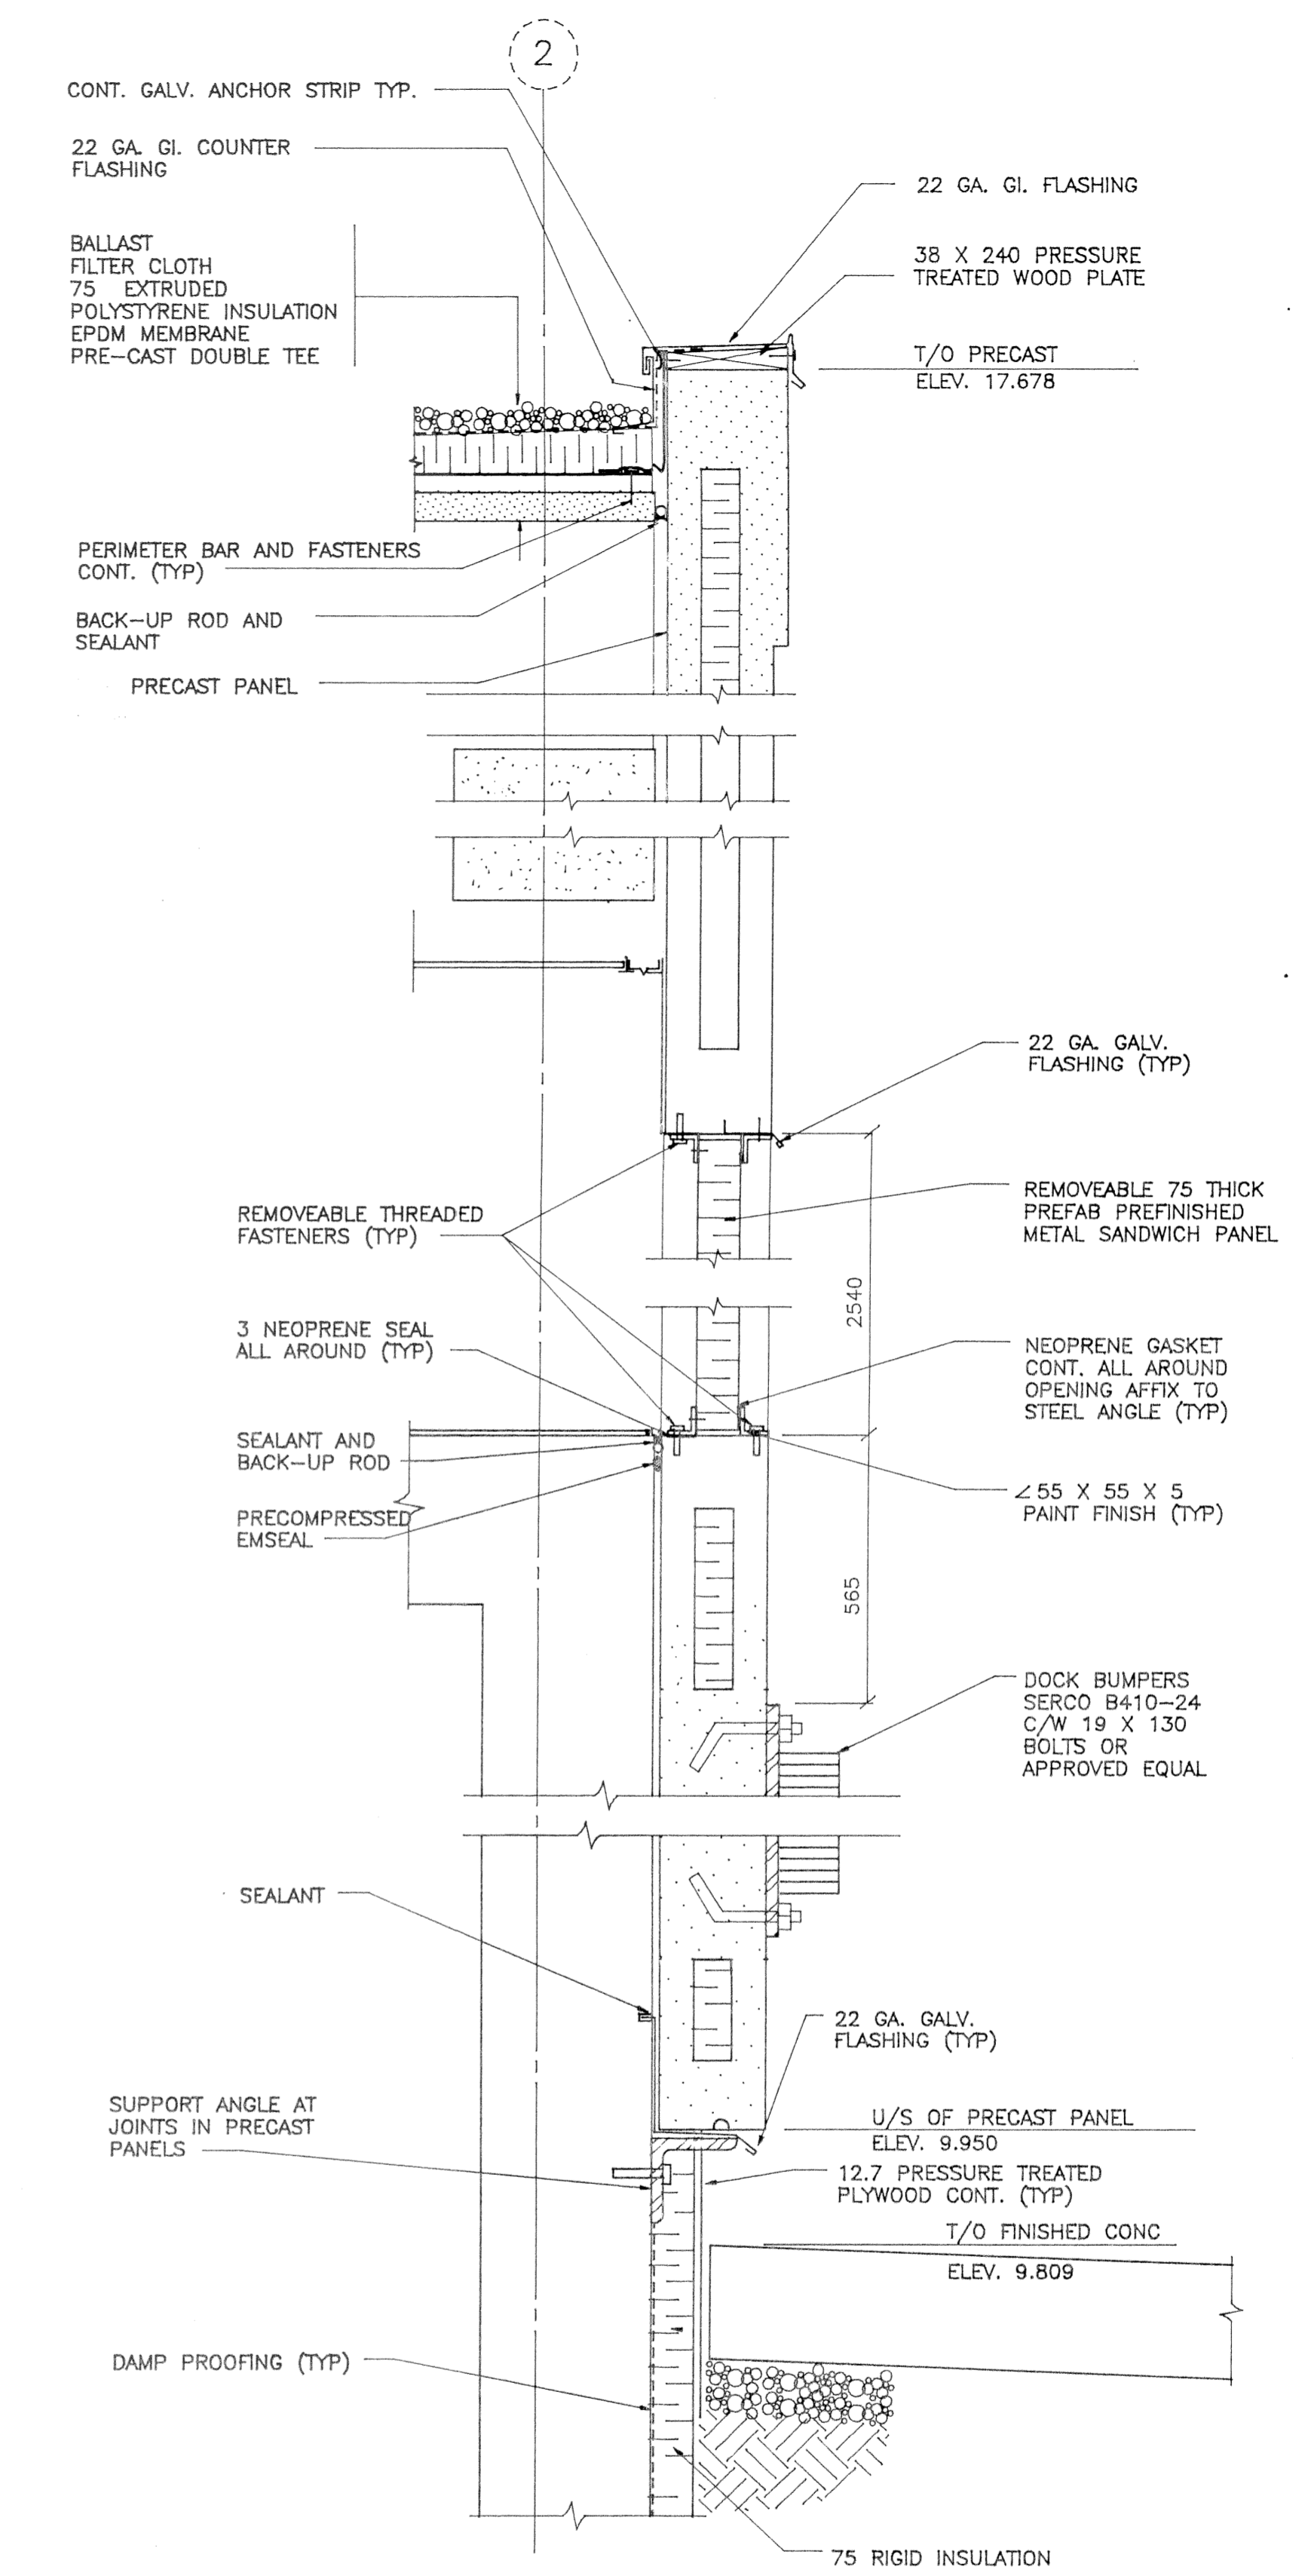

3 WALL SECTION  
A103 A104 1 : 10

APPROVED  
DATE  
CHECKED BY

<b>Wardrop-MacLaren</b> ENGINEERING CONSULTANTS		ENGINEERS 		<b>THE CITY OF WINNIPEG</b> WORKS AND OPERATIONS DIVISION WATERWORKS, WASTE AND DISPOSAL DEPARTMENT	
DESIGNED DRM BY	CHECKED BY	DESIGNED DRM BY	CHECKED BY	NORTH END WATER POLLUTION CONTROL CENTRE PRE-TREATMENT BUILDING - ARCHITECTURAL	
DRAWN GRA BY	APPROVED BY	DRAWN GRA BY	APPROVED BY	WALL SECTIONS NEP 1555	
1 AS CONSTRUCTED	AUG 88	0 ISSUED FOR TENDER	880917	CONSULTANT'S REGISTRATION NO. 870012-05-02-A104	
HOR SCALE 1 : 100 VERTICAL UNLESS NOTED		RELEASED FOR CONSTRUCTION DATE SEPTEMBER 1988		CITY ENGINEER'S OFFICE DATE	

NEP-1555

NR11743