
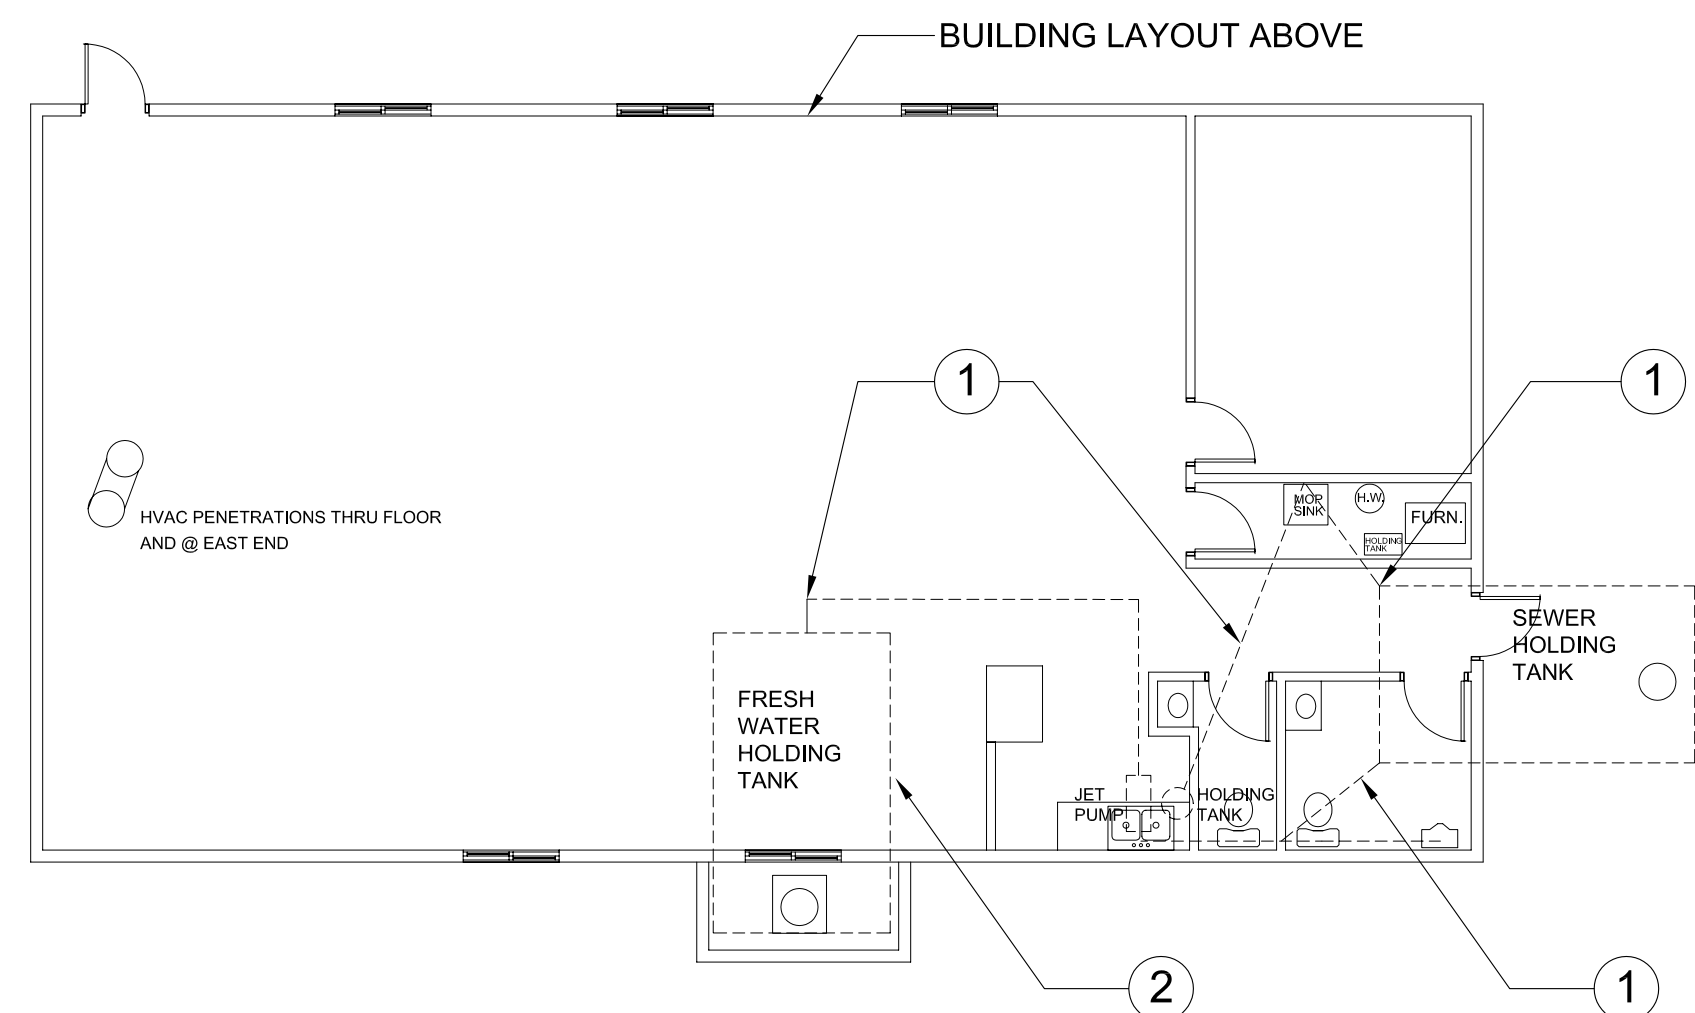
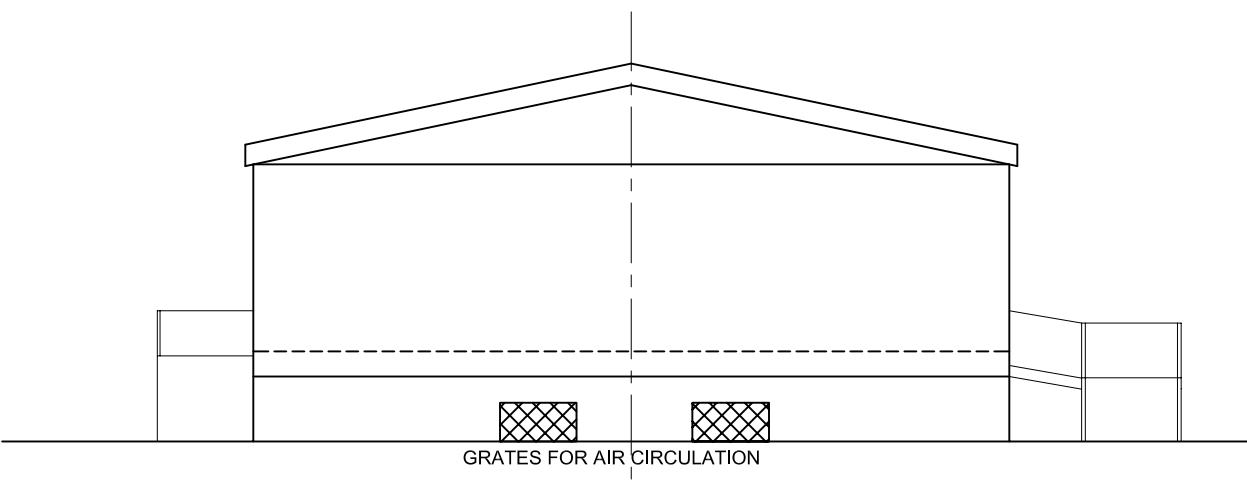
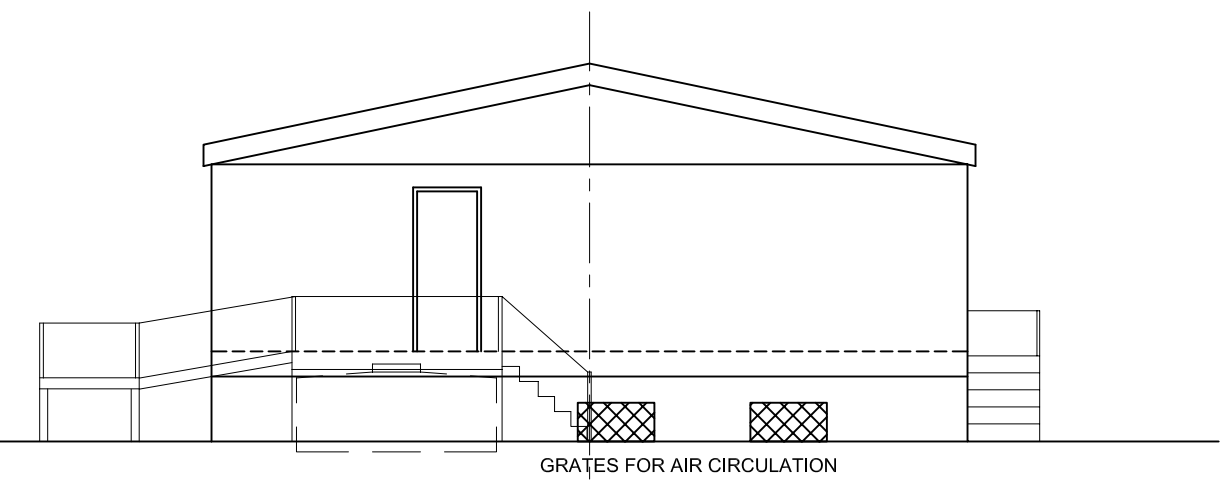


File Name 2003067V1.M1.dwg Date 2004.06.14 Description Mech. Plan & Elevations Project No. 2003-067 Address 341 Cadboro Rd.

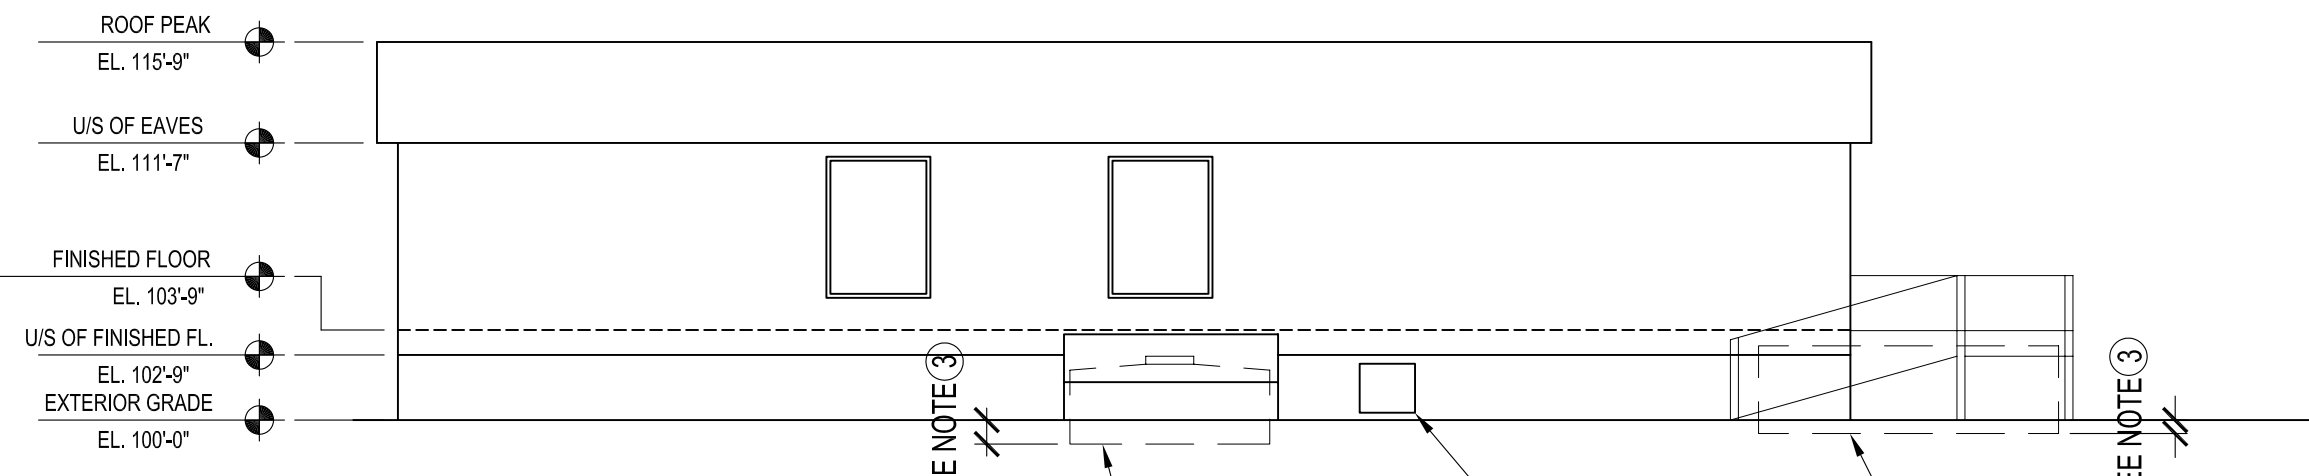

- HVAC & PLUMBING NOTES**
- 1 PROVIDE NEW DRAIN & PUMP LINES & CONNECTORS AND CONNECT TO NEWLY RELOCATED BUILDING & HOLDING TANKS AS REQUIRED.
 - 2 FRESH WATER HOLDING TANK TO BE ISOCYANURATE INSULATED.
 - 3 TANKS ARE LOCATED BELOW GRADE ON COMPACTED BASE. DEPTH TO BE DETERMINED

- NOTES :**
1. THE CONTRACTOR SHALL VISIT THE SITE AND SATISFY ONESELF THAT ALL DIMENSIONS, DATUM AND DETAILED INFORMATION SHOWN ARE CORRECT.
 2. ALL PRODUCTS AND MATERIALS TO BE USED AND INSTALLED SHALL CONFORM WITH MANUFACTURER'S SPECIFICATIONS AND ALL WORK SHALL BE DONE TO APPLICABLE CODES.
 3. THE CONTRACTOR SHALL BE RESPONSIBLE TO PATCH AND MAKE GOOD ALL EXISTING CONSTRUCTION AFFECTED BY THE REMOVAL OF ALL ITEMS FORMING THE PART OF THE RENOVATION WORK.

ORIGINAL SEALED BY:
D.A. Paley P. Eng.
Date: 2004/06/18

NO.	REVISION/DESCRIPTION	BY	DATE
SEALS			

DRAWN BY	CHECKED BY	APPROVED
MMK		
DATE	USER APPROVAL	
2004.06.14		

CITY OF WINNIPEG
PLANNING, PROPERTY & DEVELOPMENT DEPARTMENT
CIVIC ACCOMMODATIONS DIVISION
300 - 65 GARRY ST. R3C 4K4

PROJECT
Wpg. Police Services -Bridgewater Park
Foundation Upgrading
341 CADBORO ROAD -Police Firing Range

SHEET TITLE
Mechanical Plan & Elevations

SCALE	PROJECT NO.	SHEET NO.
Noted	2003-067	M-1