


**GENERAL NOTES:**

• SURVEY SOURCE: SHEPHERD & STEVENS 04168015

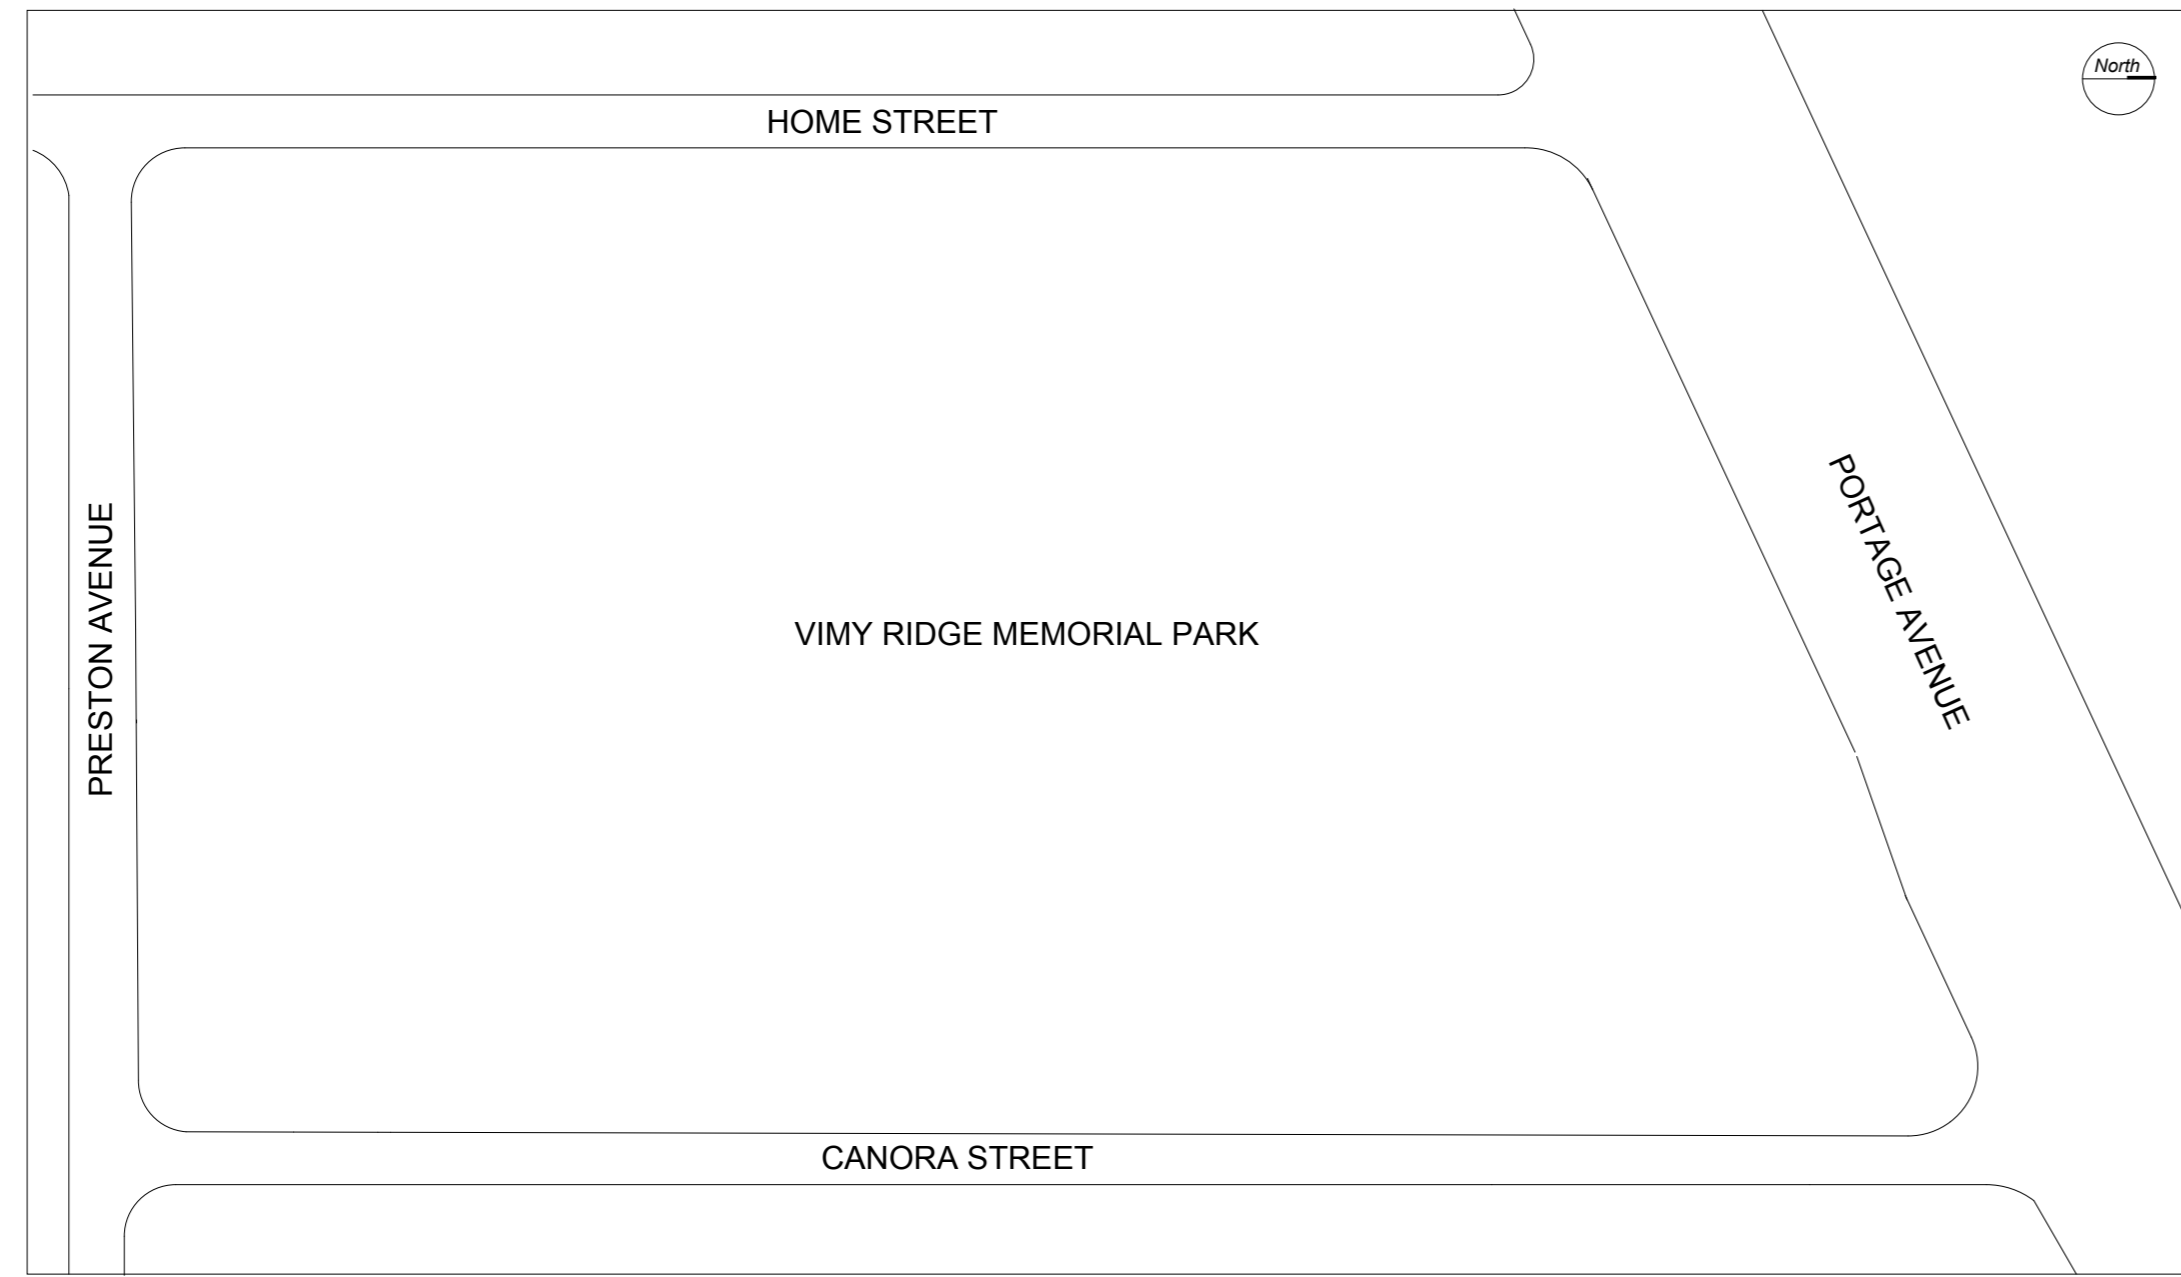

**LOCATION PLAN**

SCALE: 1:1000

**DRAWING INDEX:**

L-01	DEMOLITION PLAN
L-02	SITE LAYOUT & PLANTING PLAN
L-03	GRADING PLAN
L-04	LAYOUT PLAN WATERPLAY AREA
L-05	JUNIOR PLAY AREA LAYOUT
L-06	SENIOR PLAY AREA LAYOUT
L-07	WATERPLAY AREA GRADING DETAIL
L-08	CONSTRUCTION DETAILS
L-09	CONSTRUCTION & PLANTING DETAILS
L-10	CONSTRUCTION DETAILS
M-1	LAYOUT PLAN WATERPLAY AREA MECHANICAL
M-2	DETAILS
M-3	PUMP ROOM & WATER QUALITY MANAGEMENT DETAILS
E-1	LIGHTING AND POWER LAYOUT

**PREPARED FOR:**



**THE CITY OF WINNIPEG**  
PUBLIC WORKS DEPARTMENT  
PARKS DIVISION

**PREPARED BY:**

**HILDERMAN  
THOMAS  
FRANK  
CRAM**

Landscape Architecture • Planning  
500-115 Kenapee Avenue East, Winnipeg, Manitoba, R3B 0R3  
Tel: 204 • 944 • 9907 Fax: 204 • 957 • 1407



**CONSULTANTS:**

**Faraci Engineering**  
19 Mager Drive  
Winnipeg, Manitoba R2M 0R8  
(204) 949-1000

**P.C. Engineering Ltd.**  
F-103 Scurfield Boulevard  
Winnipeg, Manitoba R3Y 1M6  
(204) 487-1951

No.	Revision	Date
7	ISSUED FOR TENDER	FEB 24/06
6	PRE-TENDER REVIEW	JAN 13/06
5	PRE-TENDER REVIEW	DEC 21/05
4	ISSUED FOR TENDER	SEP 15/05
3	MATERIALS NOT SUBMISSION	AUG 20/05
2	95% CD SUBMISSION	JULY 14/05
1	90% CD SUBMISSION	OCT 21/04

THIS DRAWING MUST NOT BE SCALED.  
THE CONTRACTOR SHALL VERIFY ALL DIMENSIONS, DATUMS AND LEVELS PRIOR TO COMMENCEMENT OF WORK. ALL ERRORS AND OMISSIONS TO BE REPORTED IMMEDIATELY TO THE CONTRACT ADMINISTRATOR.  
VARIATIONS & MODIFICATIONS TO WORK SHOWN ON THESE DRAWINGS SHALL NOT BE CARRIED OUT WITHOUT WRITTEN PERMISSION FROM THE CONTRACT ADMINISTRATOR.  
THIS DRAWING IS THE EXCLUSIVE PROPERTY OF THE CONTRACT ADMINISTRATOR AND CAN BE REPRODUCED ONLY WITH THE PERMISSION OF THE CONTRACT ADMINISTRATOR, IN WHICH CASE THE REPRODUCER MUST BEAT THEIR NAME AS CONTRACT ADMINISTRATOR.

# VIMY RIDGE MEMORIAL PARK REVITALIZATION

CONSULTANT PROJECT NUMBER: 04-032  
CITY OF WINNIPEG BID OPPORTUNITY NUMBER: 216-2005

ISSUED TO MATERIALS MANAGEMENT: FEBRUARY 24, 2006

VIMY RIDGE MEMORIAL PARK

Project Title

COVER SHEET

Drawing Title

Drawn	TG/MB	Approved	HC
Scale	AS NOTED	Date	3/3/06
Job	04   032	Drawing	L-00