


**LOWER POWER AND LIGHTING PLAN**  
SCALE: 1:50

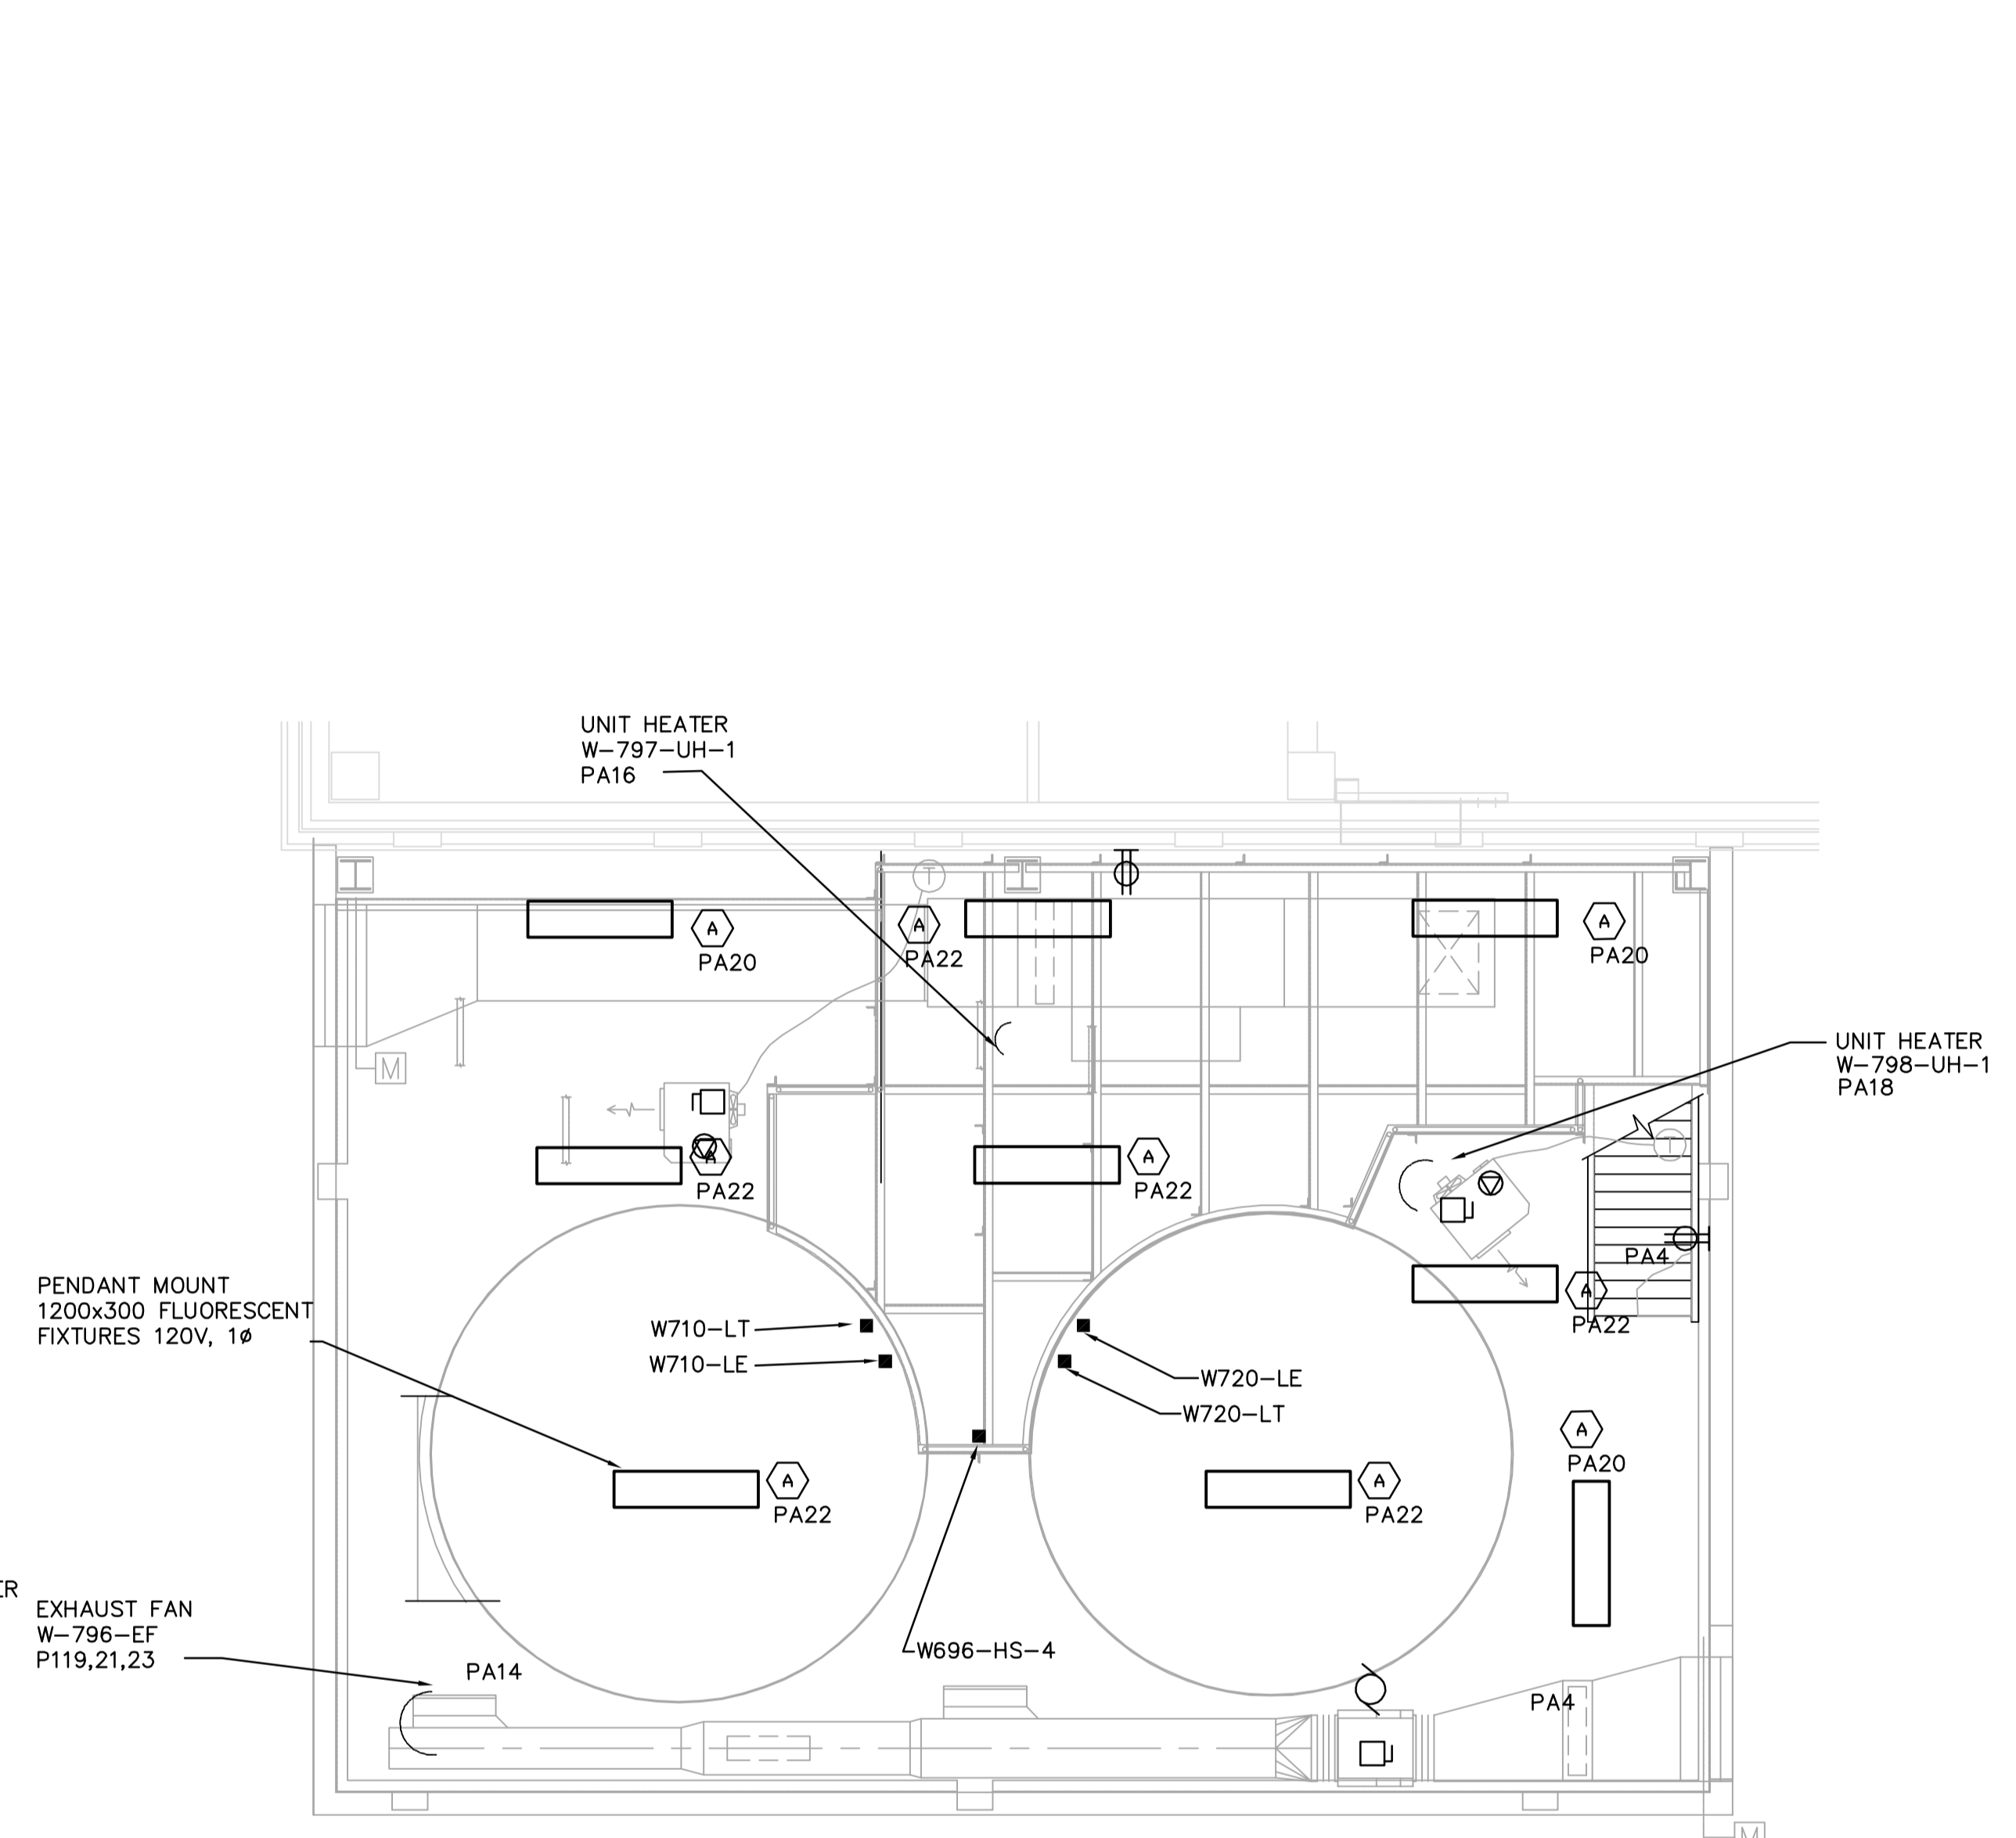

**UPPER LIGHTING AND POWER PLAN**  
SCALE: 1:50



B.M. ELEV.			
DESIGNED BY	DC/BL	CHECKED BY	SWT
DRAWN BY	DC	APPROVED BY	D. TANIGUCHI
SCALE:	1:50	RELEASED FOR CONSTRUCTION BY:	K. MARTENS
NO.	ISSUED FOR TENDER	DATE	05/12/2
00	ISSUED FOR TENDER	DATE	05/12/2
NO.	REVISIONS	DATE	BY
		2005/09/21	



ENGINEER'S SEAL  
ORIGINAL SIGNED BY  
S.W. TORMEY  
2005/12/02  
CONSULTANT DRAWING NO.  
C15.02

**THE CITY OF WINNIPEG**  
WATER AND WASTE DEPARTMENT  
ENGINEERING DIVISION

NEWPCC CENTRATE NUTRIENT TREATMENT  
PHOSPHORUS REMOVAL FACILITY  
CONTRACT No. 1

CITY FILE NUMBER  
SHEET OF  
CITY DRAWING NUMBER  
1-010F-A-A0002-001-00-D