



EAST ELEVATION
SCALE : 1:50

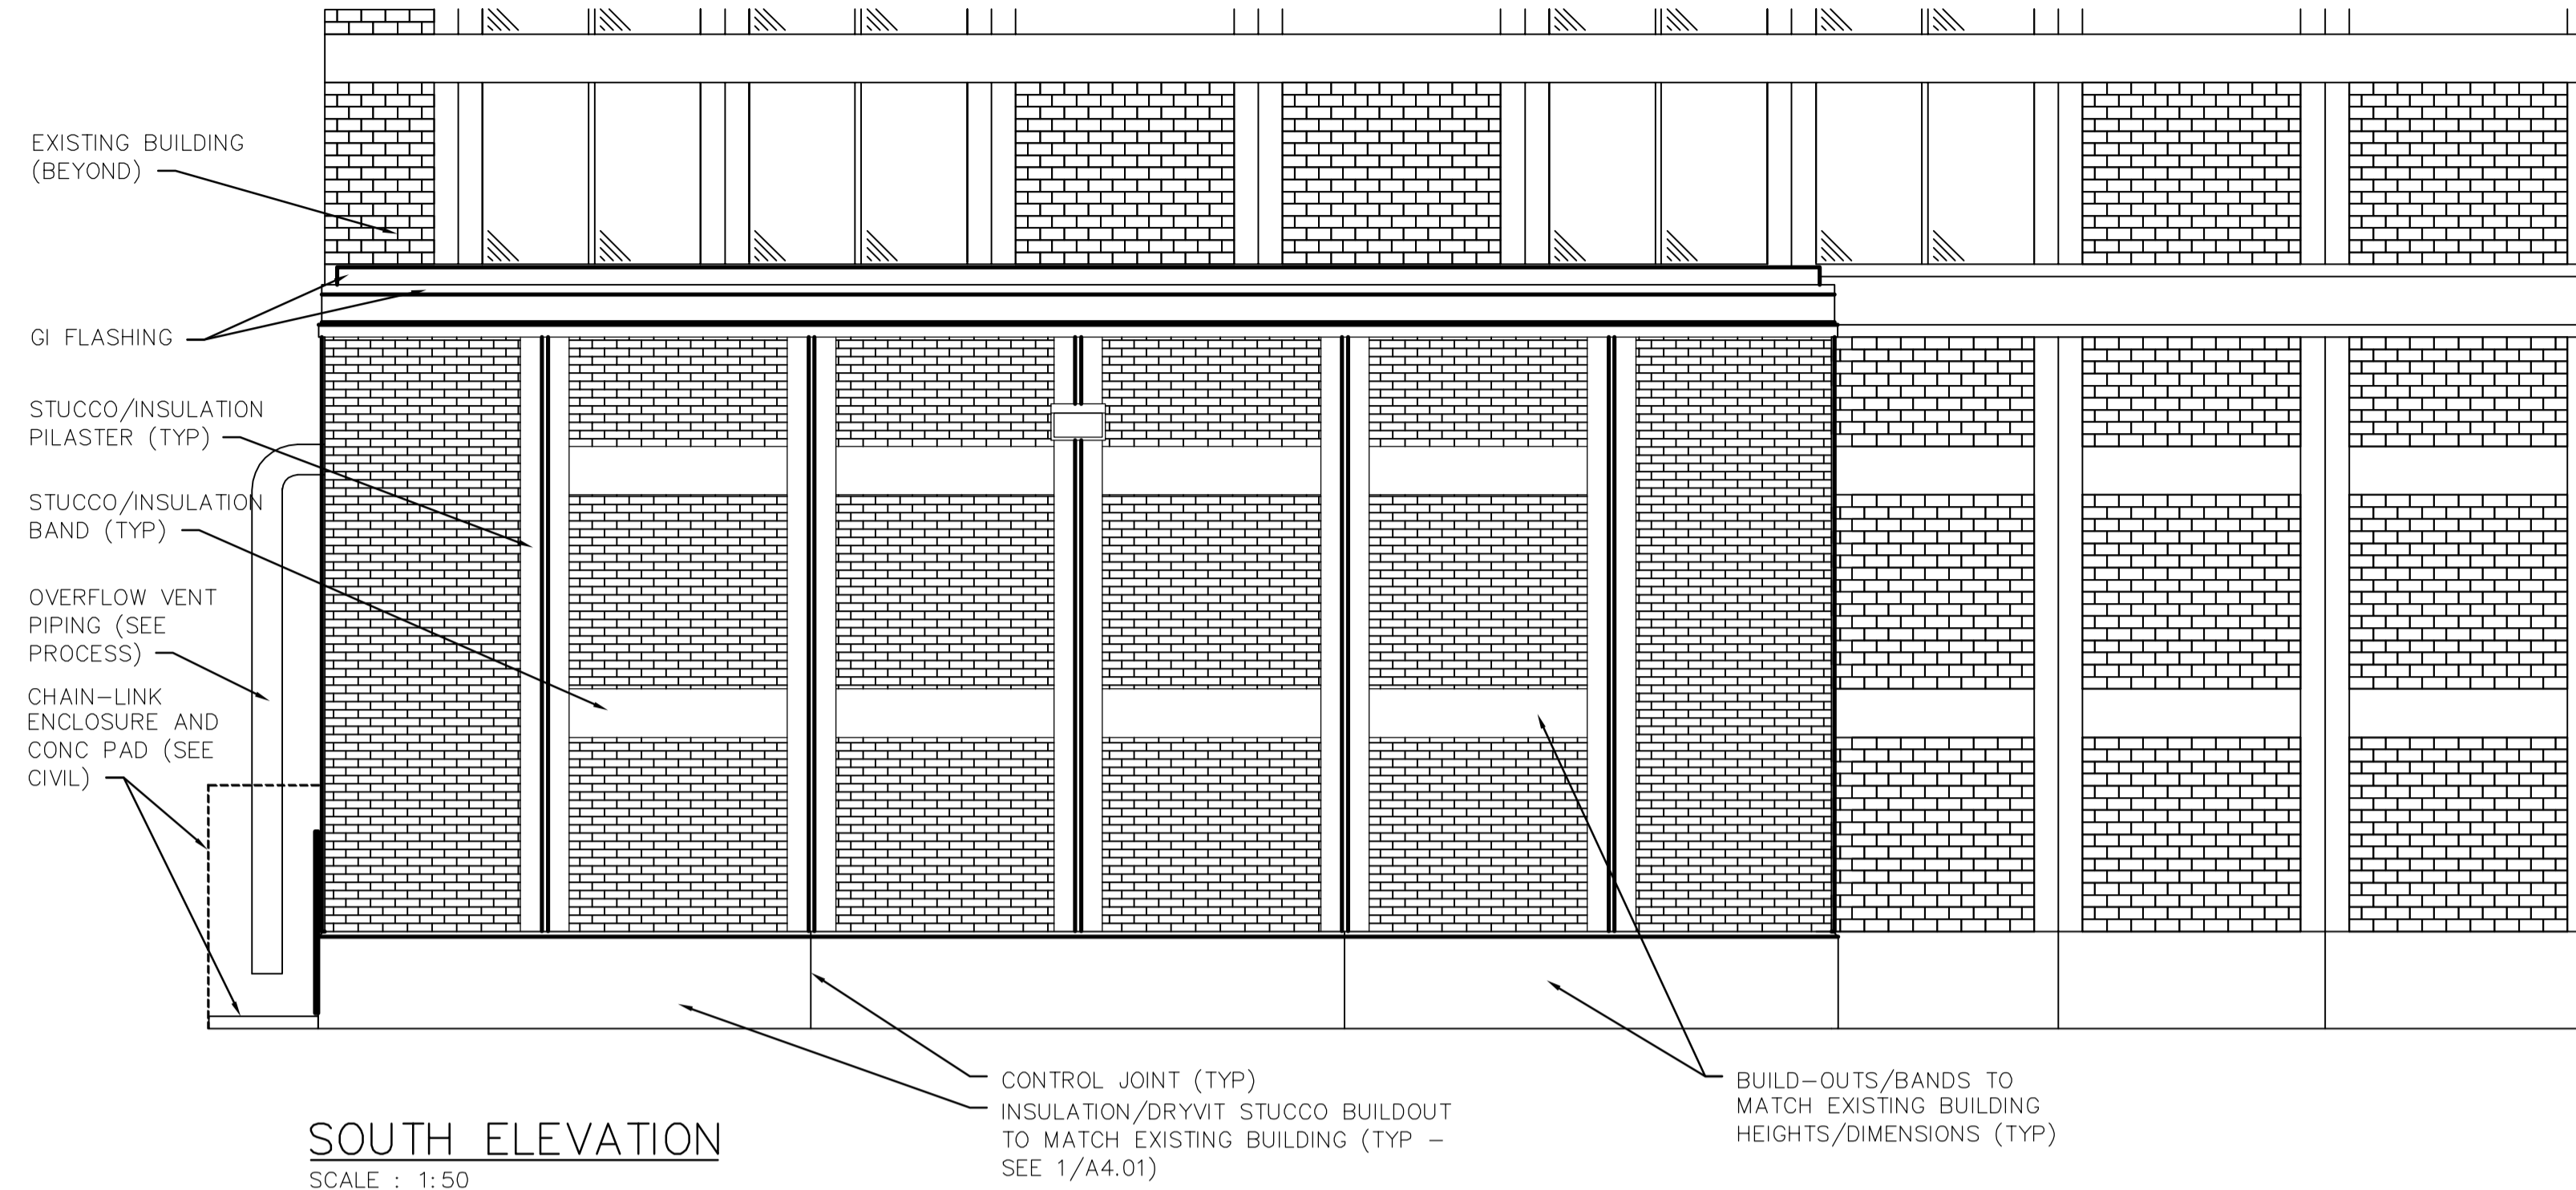

SOUTH ELEVATION
SCALE : 1:50

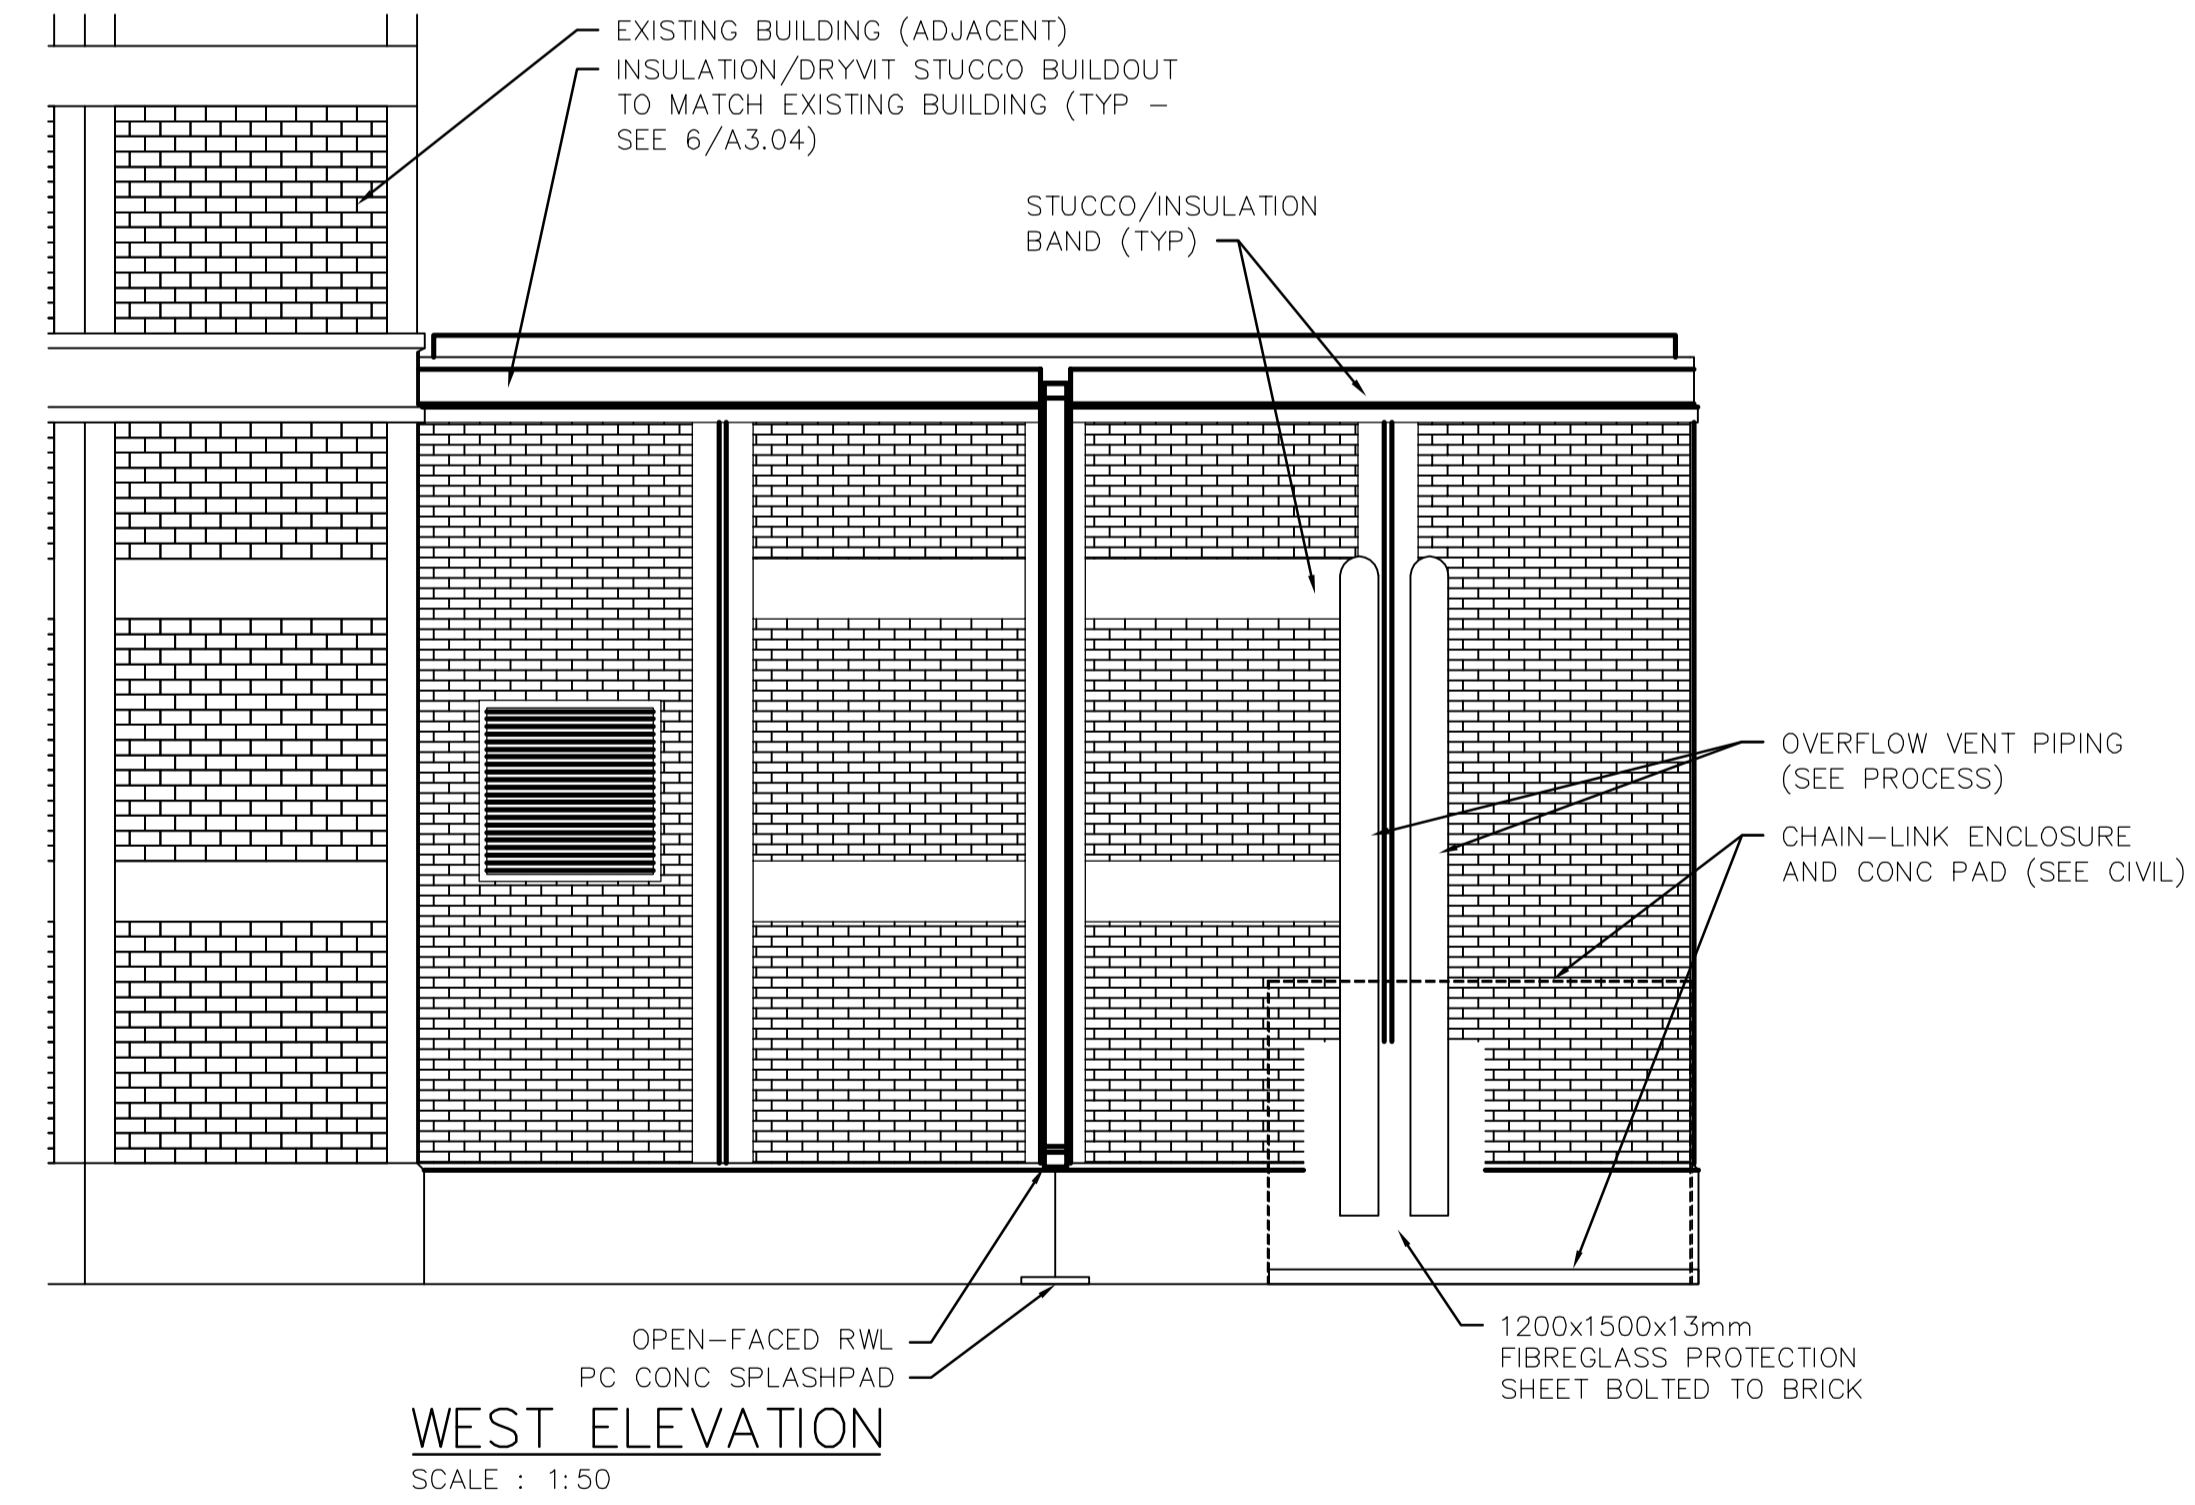

WEST ELEVATION
SCALE : 1:50



B.M. ELEV.			
DESIGNED BY	NC	CHECKED BY	NC
DRAWN BY	LK	APPROVED BY	D. TANIGUCHI
SCALE:	AS SHOWN	RELEASED FOR CONSTRUCTION BY:	K. MARTENS
NO.	ISSUED FOR TENDER	DATE	05/12/2
REVISIONS		DATE	2005/09/16
		BY	LK
		DATE	05/12/02



THE CITY OF WINNIPEG
WATER AND WASTE DEPARTMENT
ENGINEERING DIVISION

NEWPCC CENTRATE NUTRIENT TREATMENT
PHOSPHORUS REMOVAL FACILITY
CONTRACT No. 1

ARCHITECTURAL
CHEMICAL STORAGE BUILDING
EXTERIOR ELEVATIONS

CITY FILE NUMBER
SHEET 2 OF 4
CITY DRAWING NUMBER
1-0101F-A-80006-001-00-D

CONSULTANT DRAWING NO.
CA3.02