


EXTERIOR WALL CONSTRUCTION

- W1** MASONRY VENEER
240mm CONCRETE BLOCK
AIR/VAPOUR MEMBRANE
75mm RIGID INSULATION
25mm AIR SPACE
BRICK VENEER - GIANT
- W2** STANDING SEAM METAL
240mm CONCRETE BLOCK - PAINTED
AIR/VAPOUR MEMBRANE
75mm RIGID INSULATION
STANDING SEAM METAL
- W3** CONCRETE BLOCK-PAINTED

PARTITION TYPES

- P1** LIGHTWEIGHT CONCRETE BLOCK-PAINTED

BUILDING CLASSIFICATION: GROUP F, DIVISION 2,
NBC ARTICLE 3.2.2.71 (2) COMBUSTIBLE OR
NON-COMBUSTIBLE CONSTRUCTION: (a) FLOOR ASSEMBLIES
SHALL BE FIRE SEPARATIONS AND IF OF COMBUSTIBLE
CONSTRUCTION, SHALL HAVE A FIRE RESISTANCE RATING
OF NOT LESS THAN 45 MIN.
3.4.4.1 ...EVERY EXIT SHALL BE SEPARATED FROM THE
REMAINDER OF THE BUILDING BY A FIRE SEPARATION
HAVING A FIRE RESISTANCE RATING OF NOT LESS THAN
REQUIRED BY SUBSECTION 3.2.2
BUILDING AREA: 126 SM

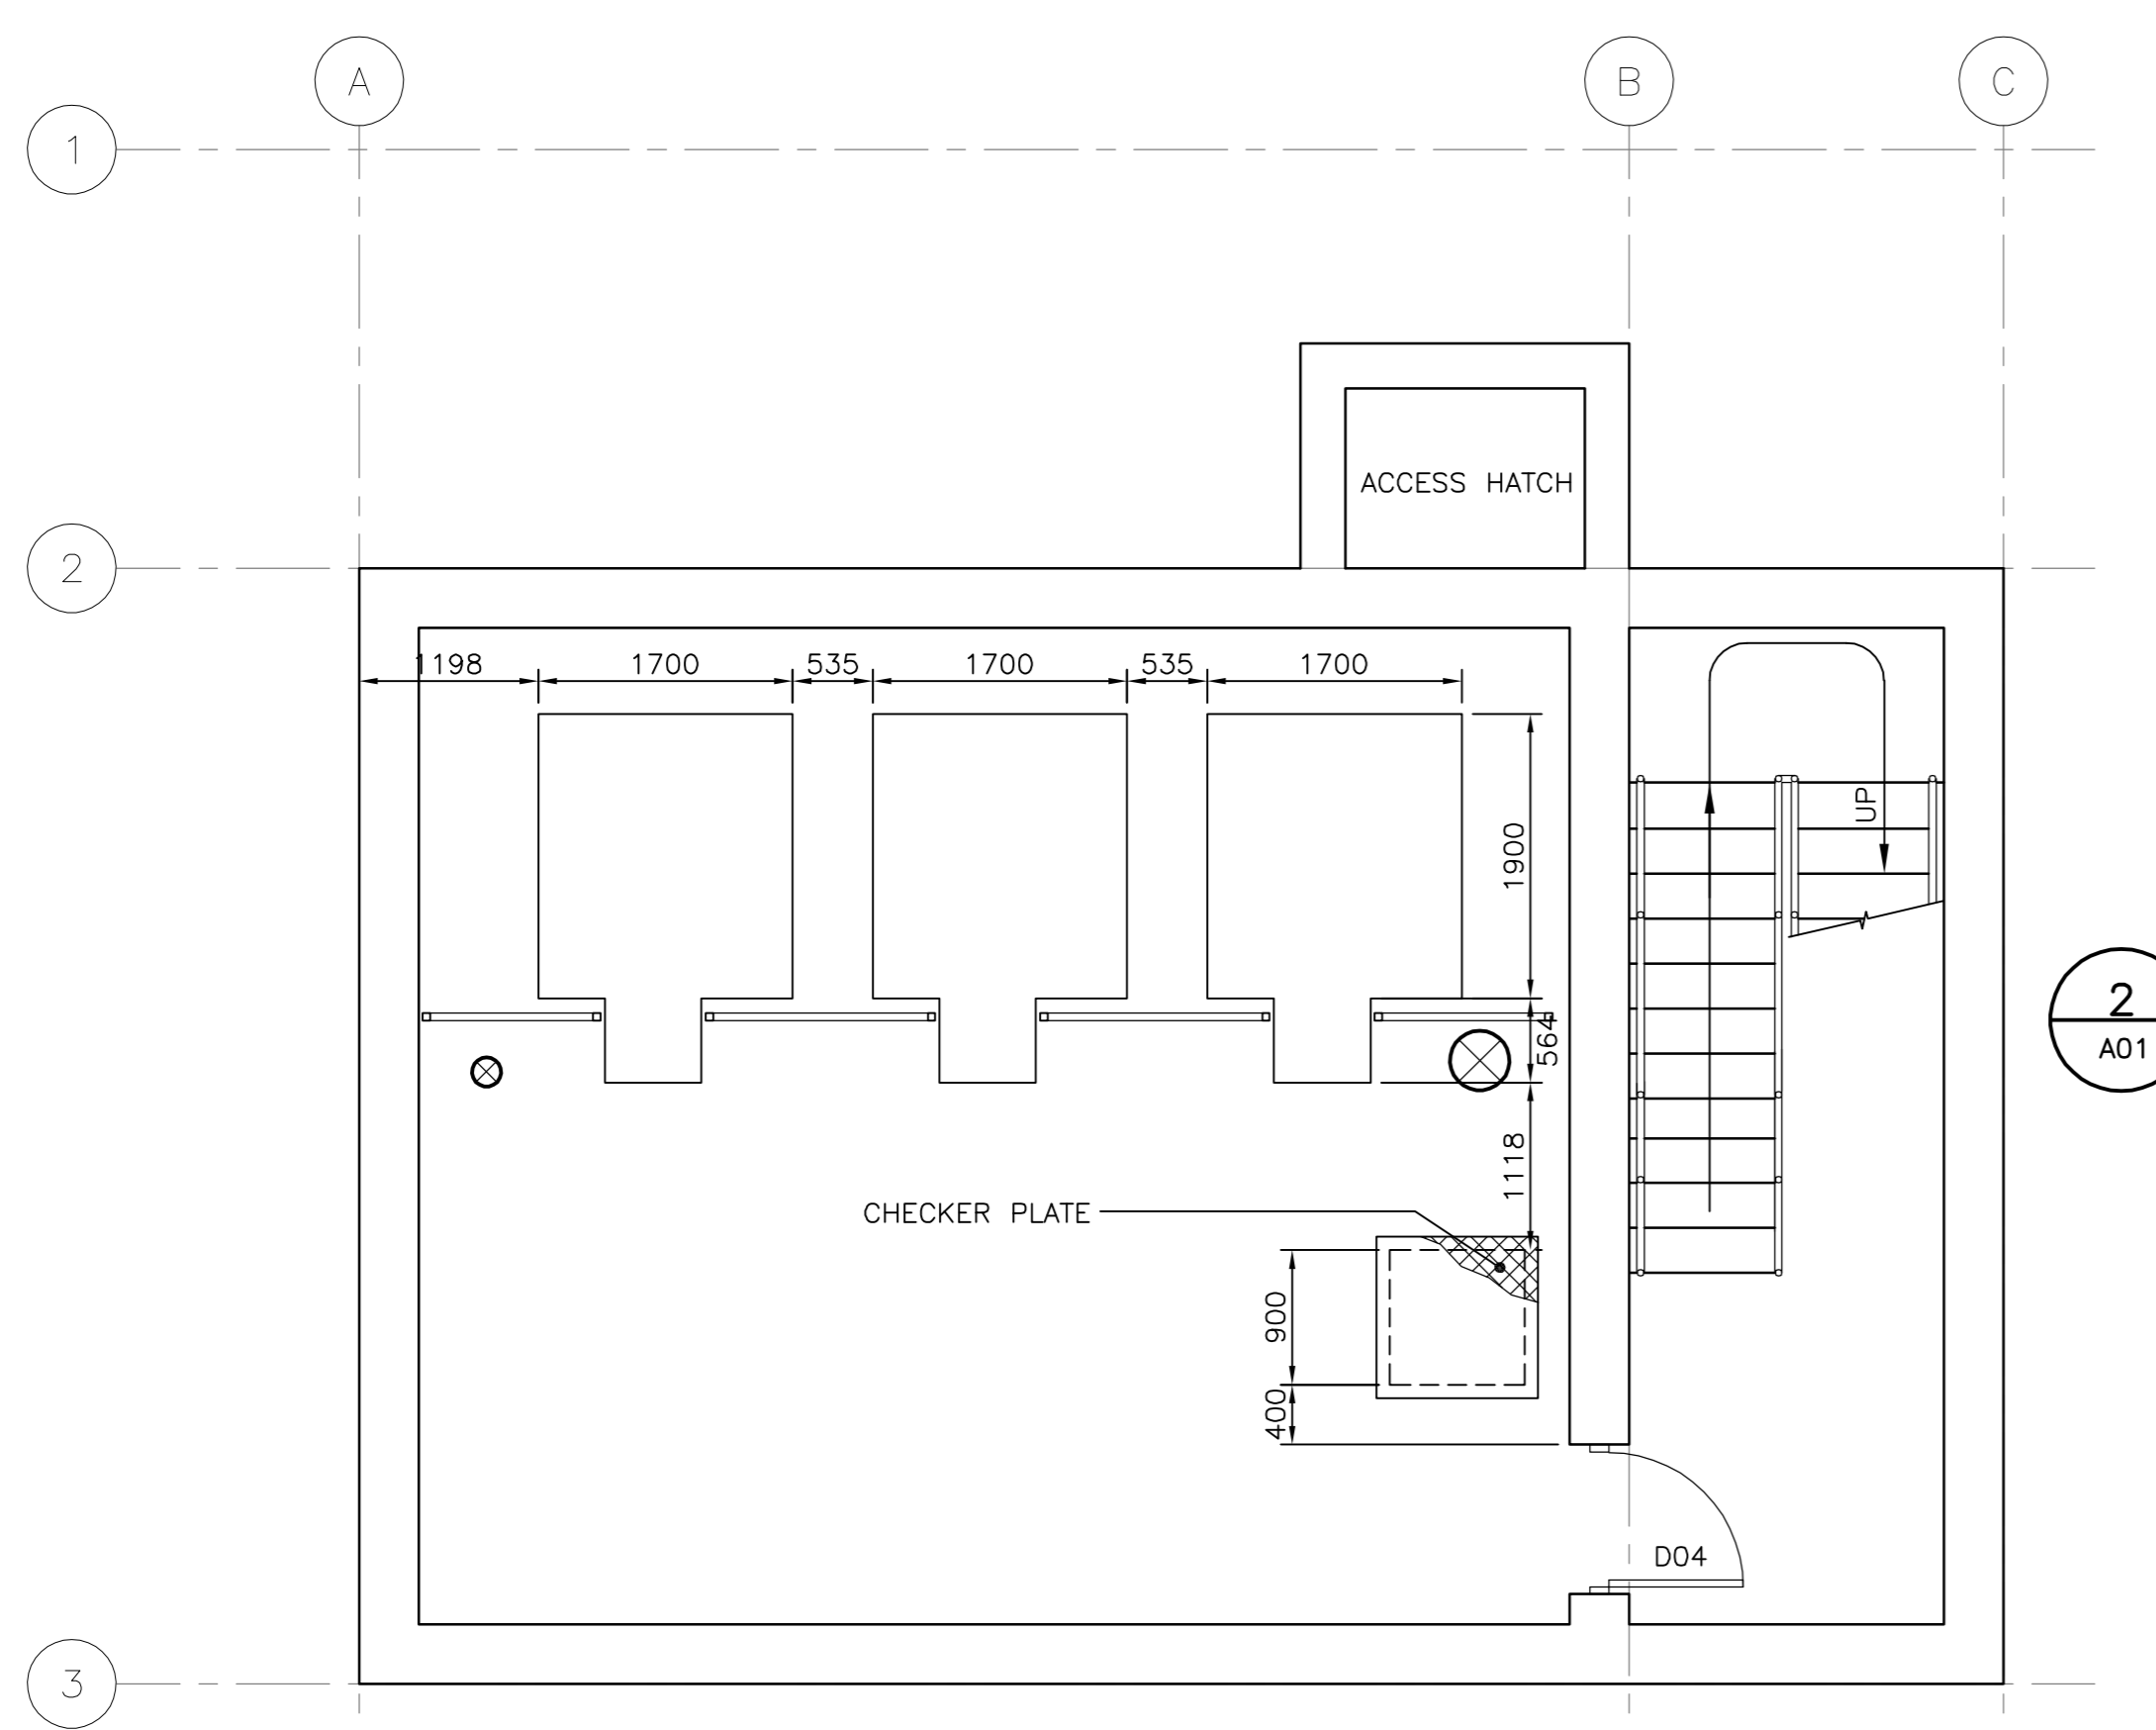

METRIC
WHOLE NUMBERS INDICATE MILLIMETRES
DECIMALIZED NUMBERS INDICATE METRES

LOCATION APPROVED UNDERGROUND STRUCTURES		B.M. ELEV.
SUPV. U/G STRUCTURES COMMITTEE	DATE	
NOTE: LOCATION OF UNDERGROUND STRUCTURES AS SHOWN ARE BASED ON THE BEST INFORMATION AVAILABLE BUT NO GUARANTEE IS GIVEN THAT ALL EXISTING UTILITIES ARE SHOWN OR THAT THE GIVEN LOCATIONS ARE EXACT. CONFIRMATION OF EXISTENCE AND EXACT LOCATION OF ALL SERVICES MUST BE OBTAINED FROM THE INDIVIDUAL UTILITIES BEFORE PROCEEDING WITH CONSTRUCTION.		
2	ISSUED FOR TENDER	05.12.09 RD
1	ISSUED FOR CLIENT REVIEW	05.11.24 RD
0	ISSUED FOR CLIENT REVIEW	05.10.19 RD
NO.	REVISIONS	DATE BY

Stantec Consulting Ltd.
905 Waverley Street, Winnipeg, Manitoba
Tel 204-489-5900 Fax 204-453-9012

DESIGNED BY	RD	CHECKED BY	AJR
DRAWN BY	MI/BJM/BL	APPROVED BY	AJR
HOR. SCALE:	AS SHOWN	AUTHORIZED BY:	R. FINGAS 05.12.09
VERTICAL:		R. FINGAS, P. ENG.	BRIDGE PROJECTS ENGINEER
DATE	05.10.13		

ENGINEER'S SEAL
ORIGINAL SEALED BY
Verne Reimer
ARCHITECT
05.12.09

THE CITY OF WINNIPEG
PUBLIC WORKS DEPARTMENT
ENGINEERING DIVISION

Winnipeg

KENASTON UNDERPASS
KENASTON UNDERPASS PUMPING STATION

ARCHITECTURAL - MAIN FLOOR PLAN AND SECTION

SHEET **II** OF **25**
CAD FILE DRAWING NUMBER
113703042-A01.dwg
CITY DRAWING NUMBER
P-3256-155

CONSULTANT DRAWING NO.
113703042-A01