


NOTES:

- REFER TO SPECIFICATION SECTION 16622 - POWER GENERATION DETAIL FOR SIZING AND NUMBER OF GENERATORS.

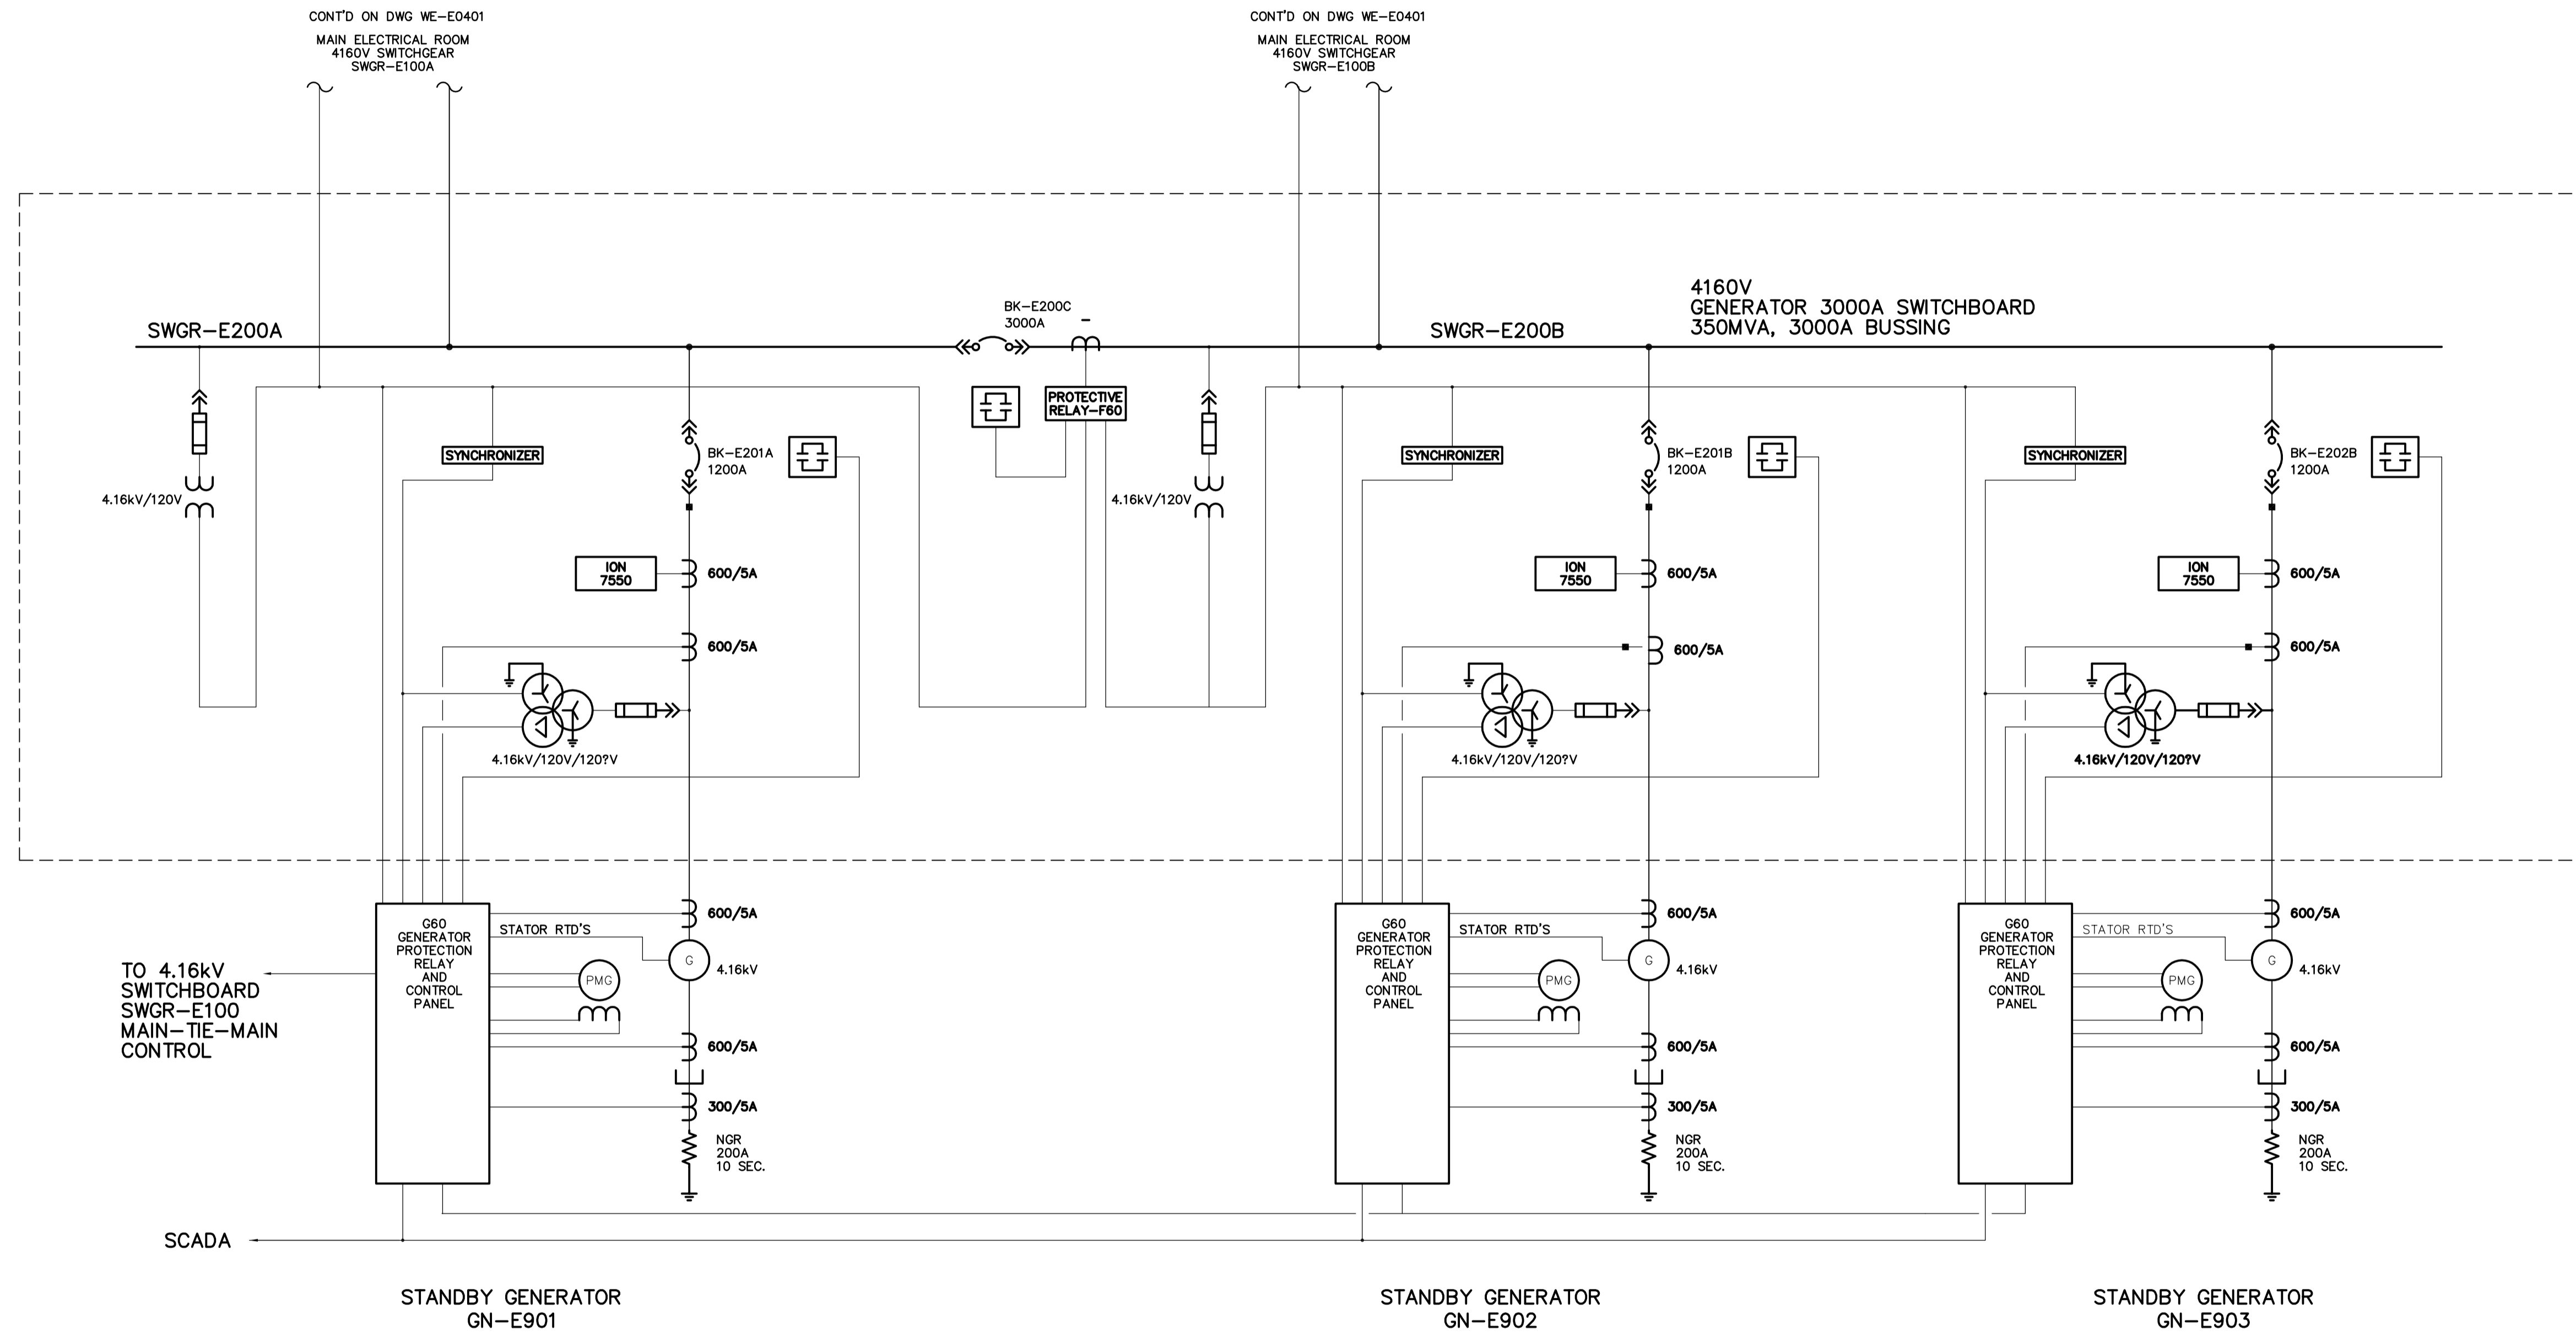

FOR INFORMATION ONLY - NOT IN CONTRACT

APEGM
 Certificate of Authorization
 Earth Tech Canada Inc.
 No. 730 Expiry: April 30, 2006

B.M. ELEV.			
C FOR INFORMATION ONLY	05-11-29	ERC	
B FOR CLIENT REVIEW	05-11-09	ERC	
A FOR CLIENT REVIEW	05-11-02		
NO. REVISIONS	DATE	BY	DATE
	2005/10/03		

CH2M HILL Frederickson Cooper ARCHITECTS	EarthTech A Type International Ltd. Company
DESIGNED BY: BLM	CHECKED BY: PS
DRAWN BY: ERC	APPROVED BY:
SCALE: NTS	RELEASED FOR CONSTRUCTION BY:
DATE: 2005/10/03	DATE:

ENGINEER'S SEAL
PRELIMINARY
 NOT FOR CONSTRUCTION
 CONSULTANT DRAWING NO.
 WG-E0402

THE CITY OF WINNIPEG
 WATER AND WASTE DEPARTMENT
 ENGINEERING DIVISION
 WATER TREATMENT PLANT
 SUPPLY OF STANDBY GENERATOR
 AND 5kV SWITCHGEAR
 ELECTRICAL
 SINGLE LINE DIAGRAM
 GENERATOR SWITCHBOARD

CITY FILE NUMBER
 SHEET OF
 CITY DRAWING NUMBER