


ROOF PLAN
1:100

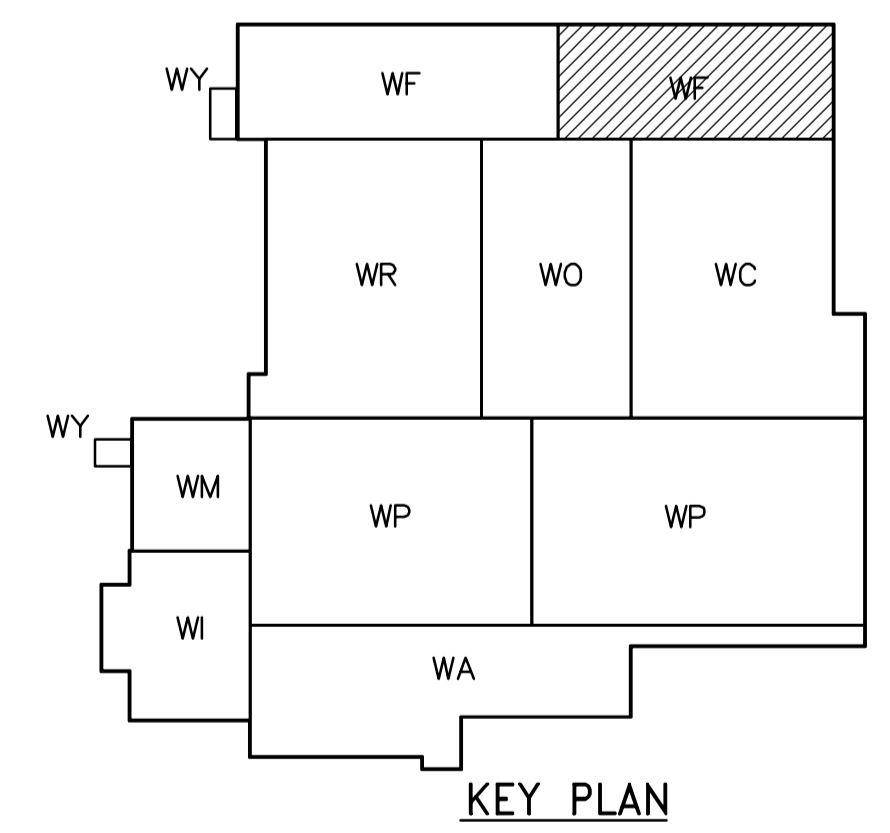

| | | | | | | |
|--|---|--|--|--|---|--|
| <p>APEGN Certificate of Authorization CH2M HILL Canada Ltd. No. 1441 Expiry: April 30, 2007</p> | <p>Frederickson Cooper ARCHITECTS</p> | | <p>EarthTech A Tyco International Ltd. Company</p> | | ENGINEER'S SEAL ORIGINAL SIGNED BY D. KRUGER 2006/04/28 | <p>THE CITY OF WINNIPEG WATER AND WASTE DEPARTMENT ENGINEERING DIVISION</p> |
| | DESIGNED BY: DK CHECKED BY: AP | | DRAWN BY: PM APPROVED BY: AHL | | WATER TREATMENT PLANT FILTRATION MECHANICAL AND ELECTRICAL | |
| | SCALE: 1:100 | | RELEASED FOR CONSTRUCTION BY: R. SOROKOWSKI | | | |
| | B.M. ELEV. | | DATE: 2005/08/10 | | STRUCTURAL FILTRATION AREA 2 ROOF PLAN | |