



- NOTES:
- SEE MCC 4A & 4B SINGLE LINE DIAGRAMS AND DISTRIBUTION PANEL SCHEDULE DP-F32 FOR 600V POWER DISTRIBUTION
 - SEE DWG WB-E0403 FOR FILTER WIRING DETAILS

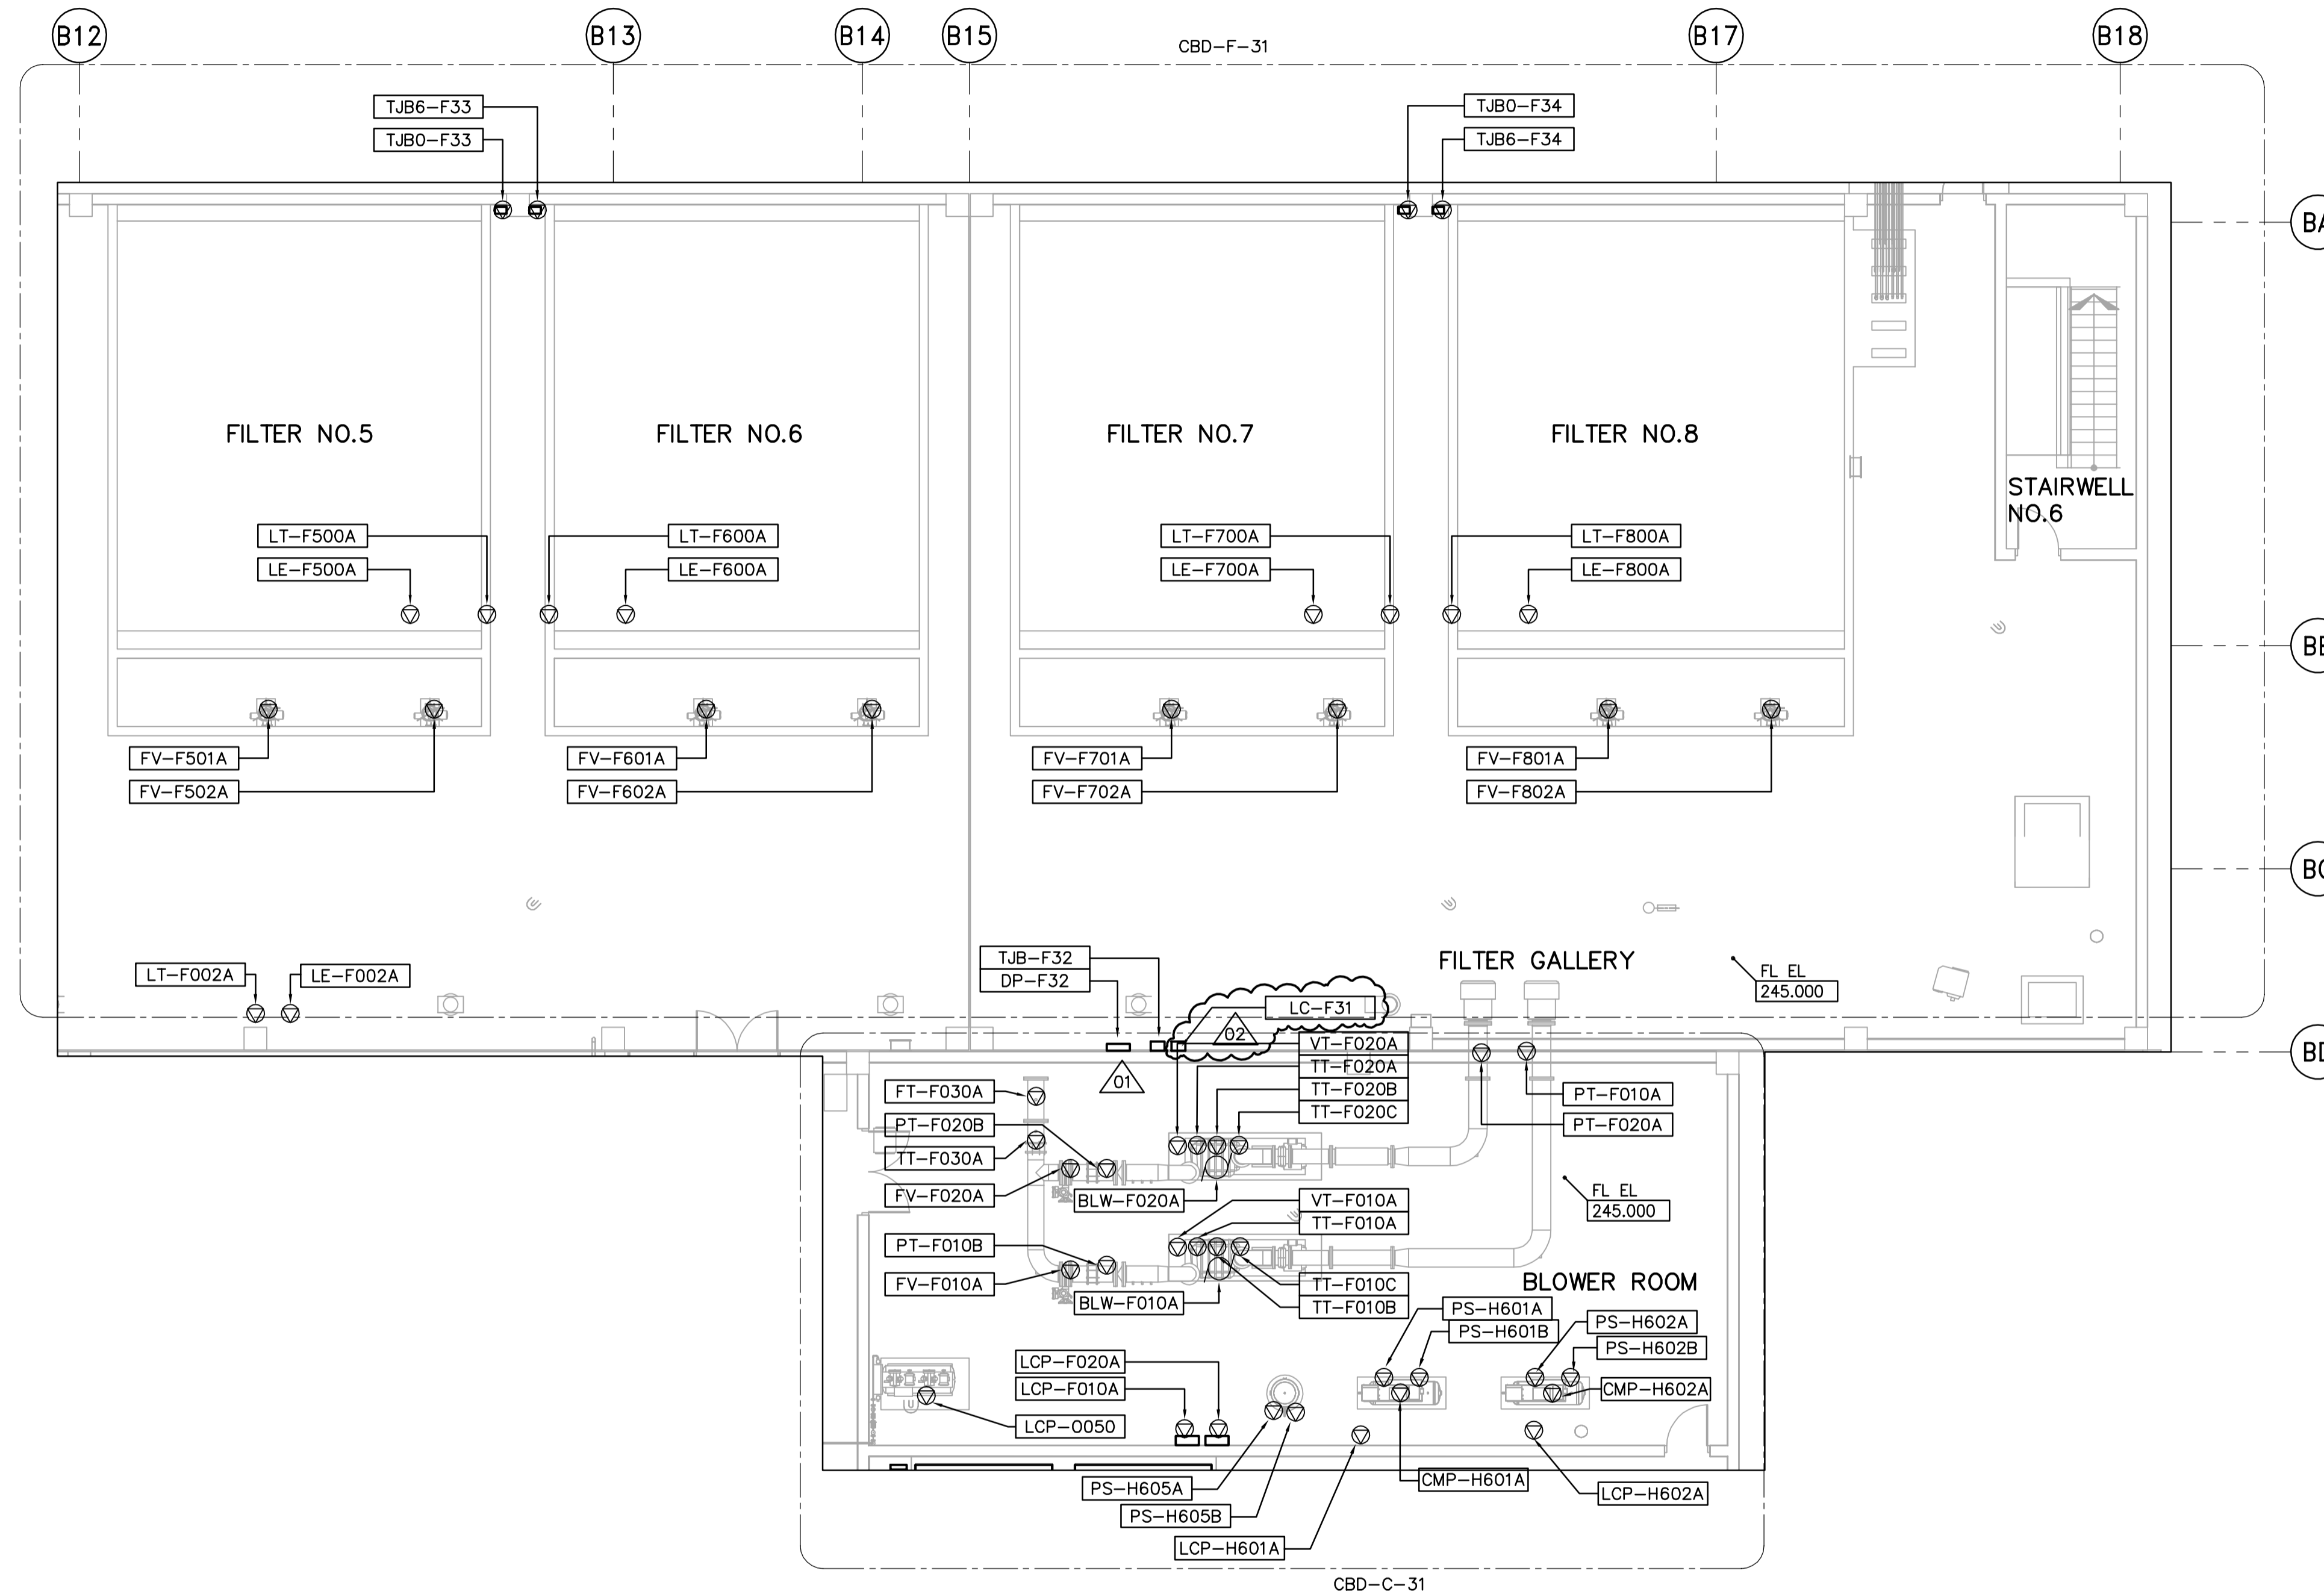

THIRD FLOOR PROCESS PLAN (AREA 2)
1:100

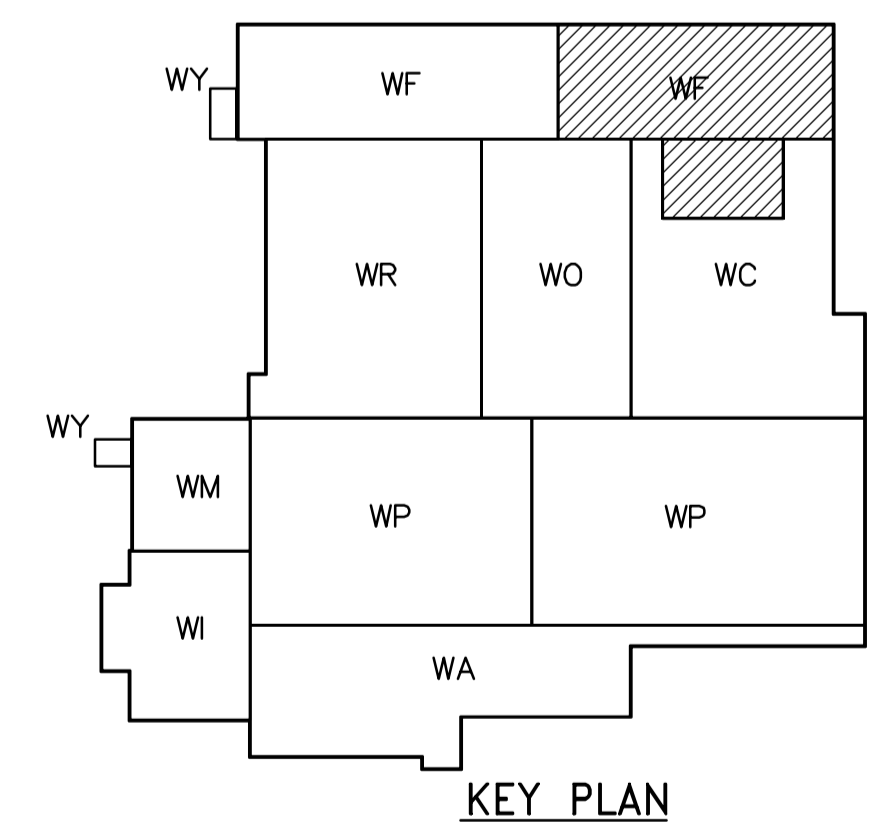

<p>APEGN Certificate of Authorization CH2M HILL Canada Ltd. No. 1441 Expiry: April 30, 2007</p>	B.M. ELEV.	<p>Frederickson Cooper ARCHITECTS</p>	<p>EarthTech A Tyco International Ltd. Company</p>	ENGINEER'S SEAL	<p>THE CITY OF WINNIPEG WATER AND WASTE DEPARTMENT ENGINEERING DIVISION</p>																					
				DESIGNED BY LL		CHECKED BY ND	ORIGINAL SIGNED BY L.D. LLEWELLYN																			
		DRAWN BY PS	APPROVED BY AHL	2006/03/29		WATER TREATMENT PLANT FILTRATION MECHANICAL AND ELECTRICAL																				
	<table border="1"> <tr> <th>NO.</th> <th>REVISIONS</th> <th>DATE</th> <th>BY</th> </tr> <tr> <td>02</td> <td>742-2005 ADDENDUM 5</td> <td>06/05/19</td> <td>LL</td> </tr> <tr> <td>01</td> <td>742-2005 ADDENDUM 3</td> <td>06/05/05</td> <td>LL</td> </tr> <tr> <td>00</td> <td>ISSUED FOR TENDER</td> <td>06/03/29</td> <td>LL</td> </tr> </table>	NO.	REVISIONS	DATE		BY	02	742-2005 ADDENDUM 5	06/05/19	LL	01	742-2005 ADDENDUM 3	06/05/05	LL	00	ISSUED FOR TENDER	06/03/29	LL	SCALE: 1:100	RELEASED FOR CONSTRUCTION BY: R. SOROKOWSKI	CONSULTANT DRAWING NO. WF-E0134	<table border="1"> <tr> <td>CITY FILE NUMBER</td> <td></td> </tr> <tr> <td>SHEET OF</td> <td></td> </tr> <tr> <td>CITY DRAWING NUMBER</td> <td>1-0601F-A-E0134-001-02D</td> </tr> </table>	CITY FILE NUMBER		SHEET OF	
NO.	REVISIONS	DATE	BY																							
02	742-2005 ADDENDUM 5	06/05/19	LL																							
01	742-2005 ADDENDUM 3	06/05/05	LL																							
00	ISSUED FOR TENDER	06/03/29	LL																							
CITY FILE NUMBER																										
SHEET OF																										
CITY DRAWING NUMBER	1-0601F-A-E0134-001-02D																									
	DATE 2005/07/13	DATE 2006/03/29		ELECTRICAL FILTRATION AREA 2 THIRD FLOOR PROCESS PLAN																						