



- NOTES:
1. ALL 120V AND 208V LOADS ARE FED FROM LP-P31
 2. SEE DRAWINGS WB-E0402 AND WB-E0403 FOR LUMINAIR MOUNTING DETAILS

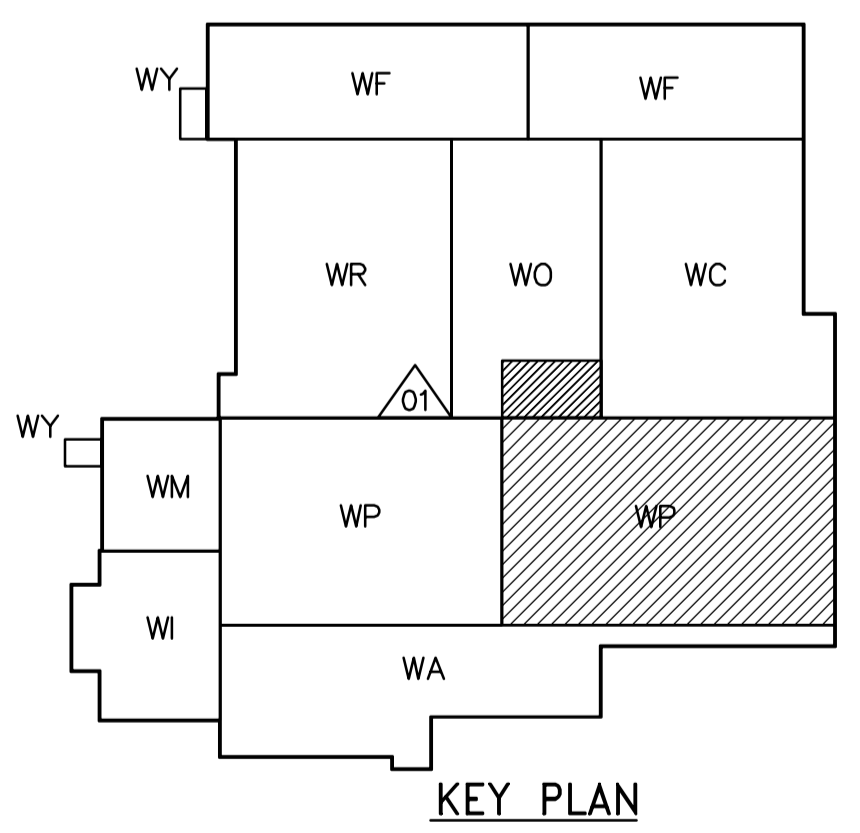

THIRD FLOOR POWER AND LIGHTING PLAN (AREA 2)
1:100

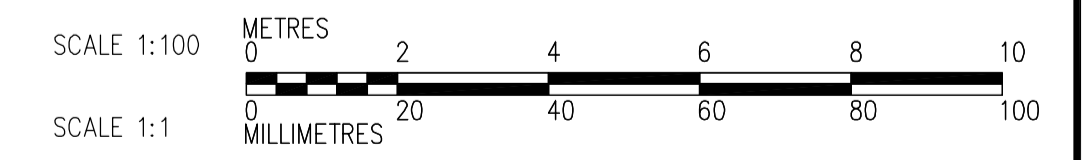

<p>APEGN Certificate of Authorization CH2M HILL Canada Ltd. No. 1441 Expiry: April 30, 2007</p>	B.M. ELEV.	<p>Frederickson Cooper ARCHITECTS</p>	<p>EarthTech A Tyco International Ltd. Company</p>	ENGINEER'S SEAL	<p>THE CITY OF WINNIPEG WATER AND WASTE DEPARTMENT ENGINEERING DIVISION</p>																					
				DESIGNED BY LL		CHECKED BY ND	ORIGINAL SIGNED BY L.D. LLEWELLYN																			
		DRAWN BY TLL	APPROVED BY AHL	2006/03/29		WATER TREATMENT PLANT FLOCCULATION AND DAF MECHANICAL AND ELECTRICAL																				
	<table border="1"> <tr> <td>02</td> <td>742-2005 ADDENDUM 5</td> <td>06/05/19</td> <td>LL</td> </tr> <tr> <td>01</td> <td>742-2005 ADDENDUM 3</td> <td>06/05/05</td> <td>LL</td> </tr> <tr> <td>00</td> <td>ISSUED FOR TENDER</td> <td>06/03/29</td> <td>LL</td> </tr> <tr> <td>NO.</td> <td>REVISIONS</td> <td>DATE</td> <td>BY</td> </tr> </table>	02	742-2005 ADDENDUM 5	06/05/19		LL	01	742-2005 ADDENDUM 3	06/05/05	LL	00	ISSUED FOR TENDER	06/03/29	LL	NO.	REVISIONS	DATE	BY	SCALE: 1:100	RELEASED FOR CONSTRUCTION BY: R. SOROKOWSKI	CONSULTANT DRAWING NO. WP-E0136	<table border="1"> <tr> <td>CITY FILE NUMBER</td> <td></td> </tr> <tr> <td>SHEET OF</td> <td></td> </tr> <tr> <td>CITY DRAWING NUMBER</td> <td>1-0601P-A-E0136-001-020</td> </tr> </table>	CITY FILE NUMBER		SHEET OF	
02	742-2005 ADDENDUM 5	06/05/19	LL																							
01	742-2005 ADDENDUM 3	06/05/05	LL																							
00	ISSUED FOR TENDER	06/03/29	LL																							
NO.	REVISIONS	DATE	BY																							
CITY FILE NUMBER																										
SHEET OF																										
CITY DRAWING NUMBER	1-0601P-A-E0136-001-020																									