
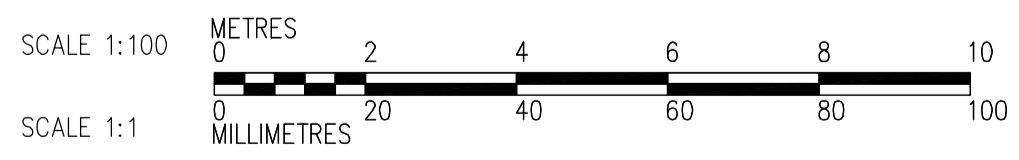


- NOTES:**
1. PROVIDE STAIRWELL SMOKE DETECTORS AS SHOWN ON FIRE PROTECTION DRAWINGS
 2. SEE PANEL SCHEDULES DP-R21 & DP-R22 FOR 600V POWER DISTRIBUTION
 3. CABLE TRAY TAGGING SEE DET. WB-E0455

SECOND FLOOR FACILITY PLAN
1:100

CABLE TRAY TAGGING
SEE DETAIL
3
WB-E0455

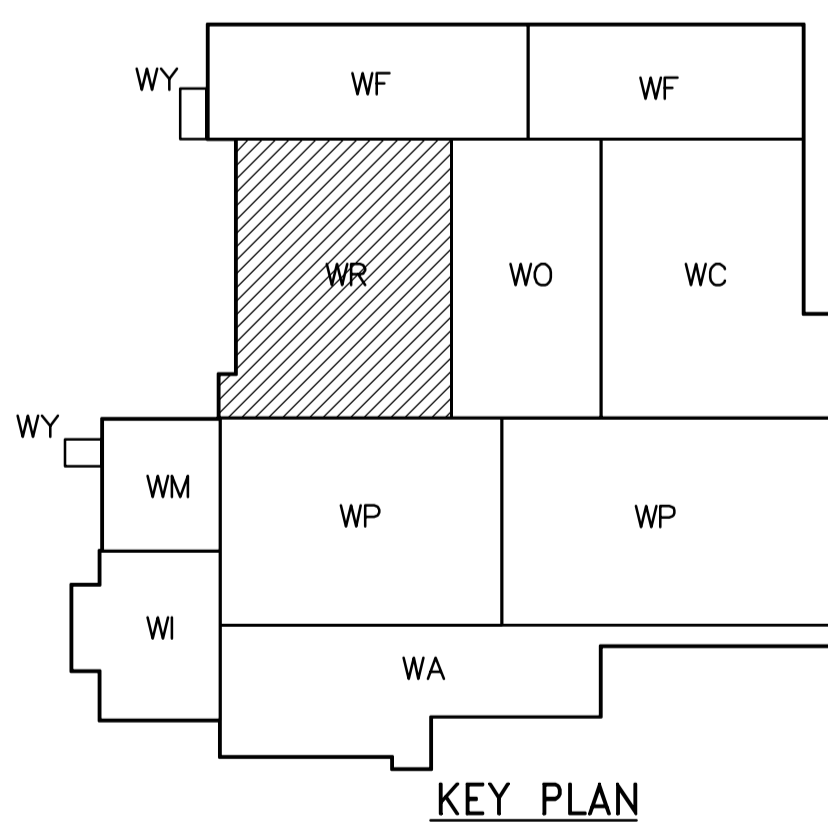

<p>Certificate of Authorization CH2M HILL Canada Ltd. No. 1441 Expiry: April 30, 2007</p>	B.M. ELEV.	<p>Frederickson Cooper ARCHITECTS</p>	<p>A Terra International Ltd. Company</p>	ENGINEER'S SEAL	<p>THE CITY OF WINNIPEG WATER AND WASTE DEPARTMENT ENGINEERING DIVISION</p>	
	DESIGNED BY: LL			CHECKED BY: ND		ORIGINAL SIGNED BY: L.D. LLEWELLYN
	DRAWN BY: TL			APPROVED BY: AHL		2006/03/29
	SCALE: 1:100			RELEASED FOR CONSTRUCTION BY: R. SOROKOWSKI		CONSULTANT DRAWING NO. WR-E0121
NO. REVISIONS	DATE BY	DATE	DATE	DATE	<p>WATER TREATMENT PLANT RESIDUALS HANDLING MECHANICAL AND ELECTRICAL</p> <p>ELECTRICAL RESIDUALS HANDLING AREA SECOND FLOOR FACILITY PLAN</p>	
03	742-2005 ADDENDUM 5	06/05/19	LL		CITY FILE NUMBER	
02	742-2005 ADDENDUM 4	06/05/12	LL		SHEET OF	
01	742-2005 ADDENDUM 3	06/05/05	LL		CITY DRAWING NUMBER	
00	ISSUED FOR TENDER	06/03/29	LL		1-0601R-A-E0121-001-03D	