


FIRST FLOOR PLAN
1:100

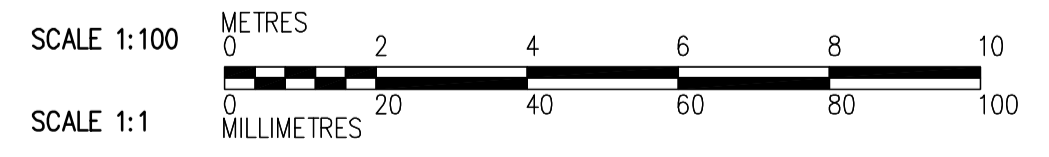

<p>APEGN Certificate of Authorization CH2M HILL Canada Ltd. No. 1441 Expiry: April 30, 2007</p>	B.M. ELEV.	<p>Frederickson Cooper ARCHITECTS</p>	<p>EarthTech A Tyco International Ltd. Company</p>	ENGINEER'S SEAL	<p>THE CITY OF WINNIPEG WATER AND WASTE DEPARTMENT ENGINEERING DIVISION</p>		
				DESIGNED BY TT		CHECKED BY DL	ORIGINAL SIGNED BY D.K. CUDDINGTON
				DRAWN BY AM		APPROVED BY AHL	2006/03/29
				SCALE: 1:100		RELEASED FOR CONSTRUCTION BY: R. SOROKOWSKI	CONSULTANT DRAWING NO. WI-H0111
	01 742-2005 ADDENDUM 6 06/05/26 TT	DATE 2005/07/04	DATE 2006/03/29		<p>WATER TREATMENT PLANT INLET WORKS AND RAW WATER PUMPING MECHANICAL AND ELECTRICAL</p> <p>HVAC RAW WATER PUMP STATION AREA FIRST FLOOR PLAN</p>		
	00 ISSUED FOR TENDER 06/03/29 TT				CITY FILE NUMBER		
	NO. REVISIONS	DATE	BY		SHEET OF		
					CITY DRAWING NUMBER		
					1-06011-A-H0111-001-010		