

**NOTES:**


- SEE DWGS WM-S0111 TO WM-S0146 FOR SLAB REINFORCING, UNO.
- SEE DWG WM-S0515 FOR BEAM AND COLUMN SCHEDULES.
- FOR TYPICAL WALL CORNER REINF SEE 4 WB-S0452

**LEGEND:**

NOT IN CONTRACT

**C SECTION**  
WM-S0111 1:50  
WM-S0146  
WM-F0105

**INFORMATION ONLY**

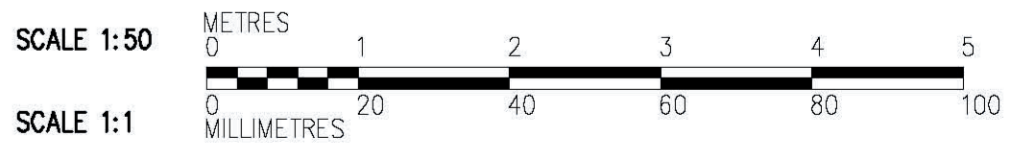

 <b>APEGM</b> Certificate of Authorization CH2M HILL Canada Ltd. No. 1441 Expiry: April 30, 2006	B.M. ELEV.	 Frederickson Cooper ARCHITECTS	 EarthTech A Geo International Ltd. Company	ENGINEER'S SEAL  ORIGINAL SIGNED BY D. KRUGER 2006/02/06	 <b>THE CITY OF WINNIPEG</b> WATER AND WASTE DEPARTMENT ENGINEERING DIVISION  WATER TREATMENT PLANT GENERAL PLANT SERVICES/MISCELLANEOUS FOUNDATIONS AND CONCRETE STRUCTURES  STRUCTURAL ELECTRICAL ROOM SECTION
	DESIGNED BY: MH DRAWN BY: RL SCALE: 1:50	CHECKED BY: AP APPROVED BY: DJT RELEASED FOR CONSTRUCTION BY: R. SOROKOWSKI 2006/02/08	CITY FILE NUMBER SHEET OF CITY DRAWING NUMBER <b>1-060M-A-80203-01-0D</b>		
NO. REVISIONS 01 583-2005 ADDENDUM 3 06/03/06 EL 00 ISSUED FOR TENDER 06/02/03 MH	DATE BY 2005/09/16	CONSULTANT DRAWING NO. WM-S0203			