

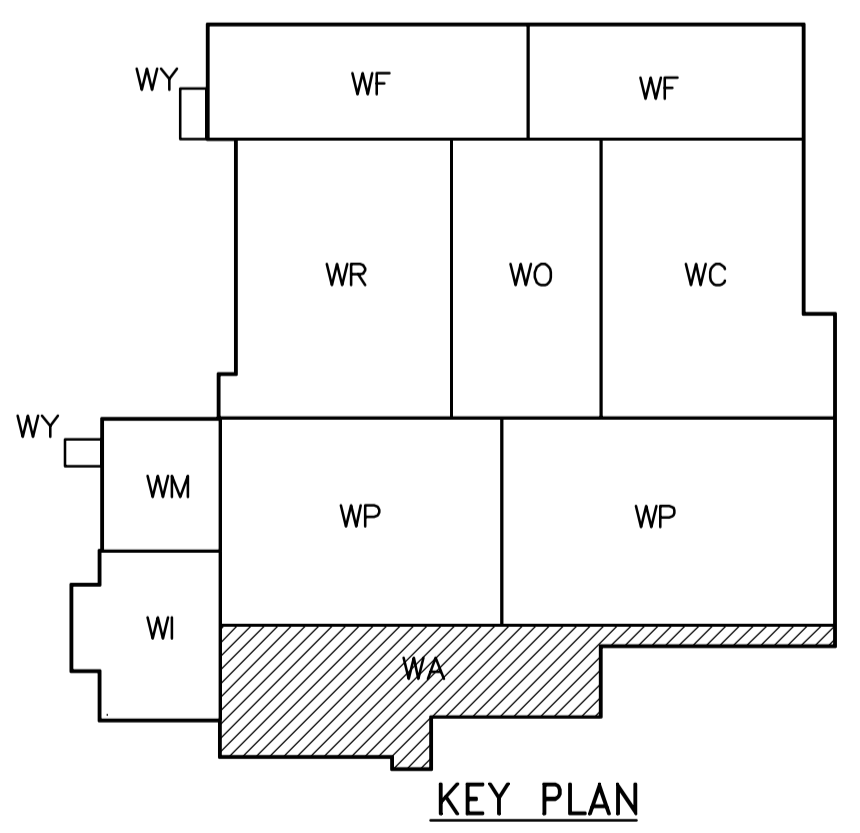


- NOTES:**
- ALL 120V AND 208V LOADS ARE FED FROM LP-A11.
  - EMERGENCY LIGHTING EM-X-1, -2 ETC ARE FED FROM BATTERY PACK EM-X.
  - MOUNT TYPE A LUMINAIRE 3m ABOVE FINISHED FLOOR.
  - MOUNT TYPE E LUMINAIRE 7m ABOVE FINISHED FLOOR.

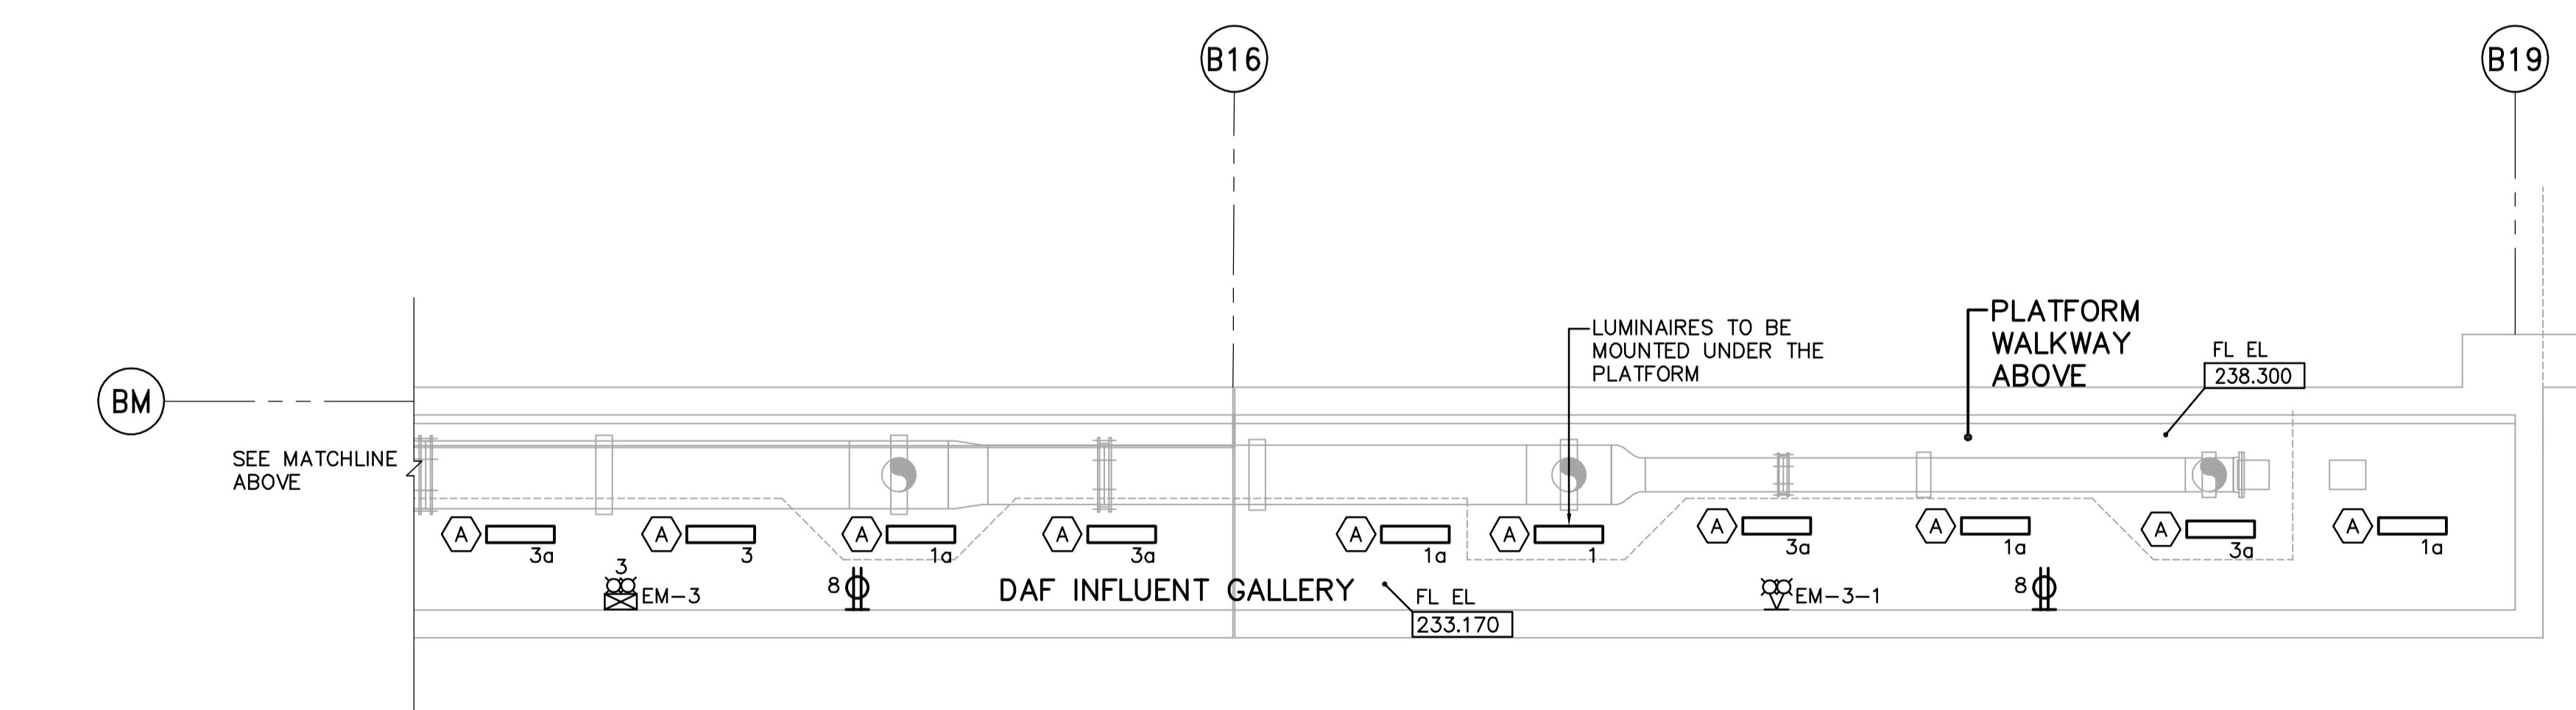

**LOWER LEVEL POWER AND LIGHTING PLAN**  
1:100

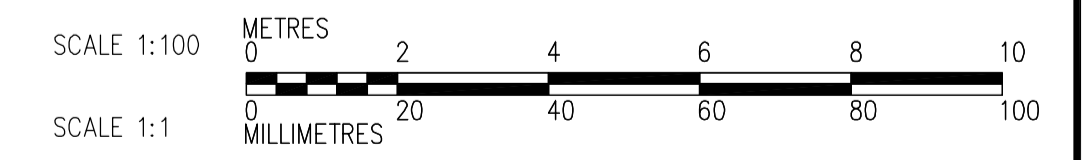

 <b>APEGN</b> Certificate of Authorization CH2M HILL Canada Ltd. No. 1441 Expiry: April 30, 2006	B.M. ELEV.	 Frederickson Cooper ARCHITECTS	 A 100 International Ltd. Company	ENGINEER'S SEAL  ORIGINAL SIGNED BY L.D. LLEWELLYN 2006/03/29	 <b>THE CITY OF WINNIPEG</b> WATER AND WASTE DEPARTMENT ENGINEERING DIVISION  WATER TREATMENT PLANT ADMINISTRATION AREA MECHANICAL AND ELECTRICAL  ELECTRICAL ADMINISTRATION AREA LOWER LEVEL POWER AND LIGHTING PLAN	CITY FILE NUMBER
	00 ISSUED FOR TENDER 06/03/29 LL NO. REVISIONS DATE BY	DESIGNED BY JT CHECKED BY ND DRAWN BY KJ APPROVED BY AHL SCALE: 1:100 RELEASED FOR CONSTRUCTION BY: R. SOROKOWSKI DATE 2005/08/18 DATE 2006/03/29	CONSULTANT DRAWING NO. WA-E0103	SHEET OF  CITY DRAWING NUMBER 1-0601A-A-E0103-001-000		