
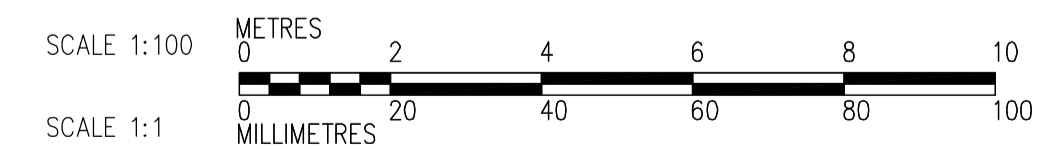


- NOTES:
1. ALL 120V AND 208V LOADS ARE FED FROM LP-A31 UNLESS OTHERWISE NOTED.
 2. EMERGENCY LIGHTING EM-X-1 ARE FED FROM BATTERY PACK EM-X.
 3. MOUNT TYPE LUMINARIES T-BAR.

THIRD FLOOR POWER AND LIGHTING PLAN
1:100

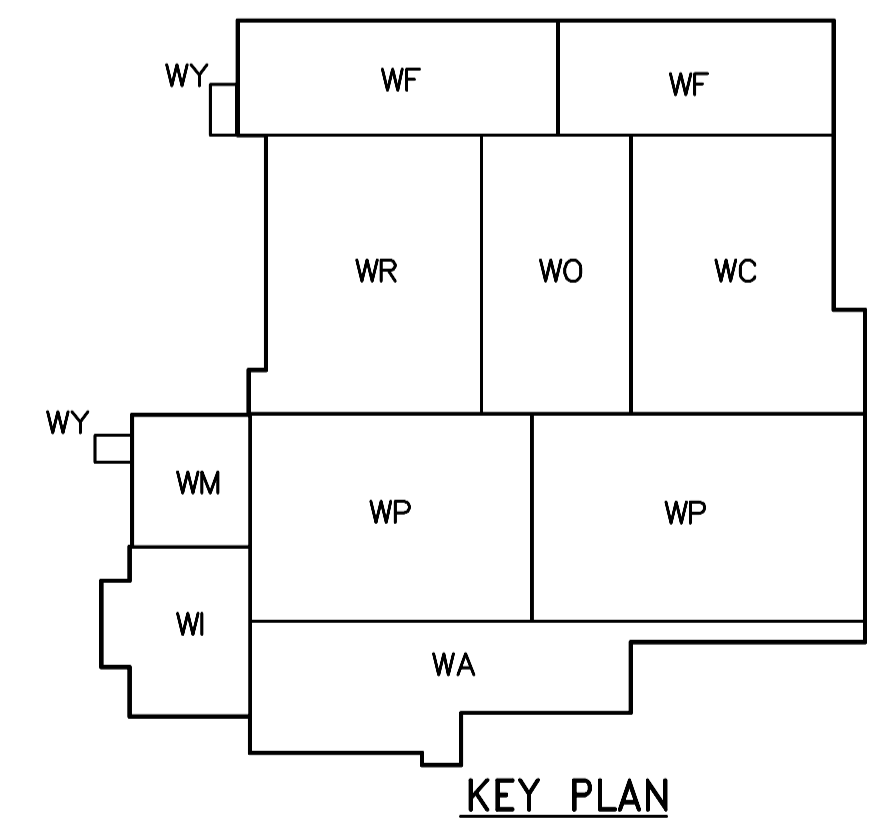

<p>APEGN Certificate of Authorization CH2M HILL Canada Ltd. No. 1441 Expiry: April 30, 2006</p>	<p>Frederickson Cooper ARCHITECTS</p>	<p>A Geo International Ltd. Company</p>	ENGINEER'S SEAL	<p>THE CITY OF WINNIPEG WATER AND WASTE DEPARTMENT ENGINEERING DIVISION</p>		
			DESIGNED BY LL		CHECKED BY ND	ORIGINAL SIGNED BY L.D. LLEWELLYN
			DRAWN BY TL		APPROVED BY AHL	2006/03/29
			SCALE: 1:100		RELEASED FOR CONSTRUCTION BY: R. SOROKOWSKI	CONSULTANT DRAWING NO. WA-E0133
00 ISSUED FOR TENDER	06/03/29	LL		<p>WATER TREATMENT PLANT ADMINISTRATION MECHANICAL AND ELECTRICAL</p> <p>ELECTRICAL ADMINISTRATION AREA THIRD FLOOR POWER AND LIGHTING PLAN</p>		
NO. REVISIONS	DATE	BY	DATE	<p>CITY FILE NUMBER</p> <p>SHEET OF</p> <p>CITY DRAWING NUMBER</p> <p>1-0601A-A-E0133-001-000</p>		
			2005/08/18			
			2006/03/29			