
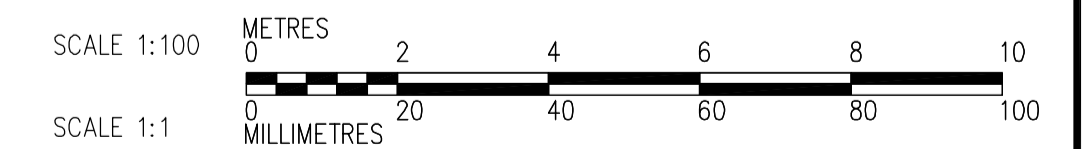


- NOTES:
 1. ALL 120V AND 208V LOADS ARE FED FROM LP-A31.
 2. MOUNT TYPE LUMINAIRES IN T-BAR.

ROOF POWER AND LIGHTING PLAN
 1:100

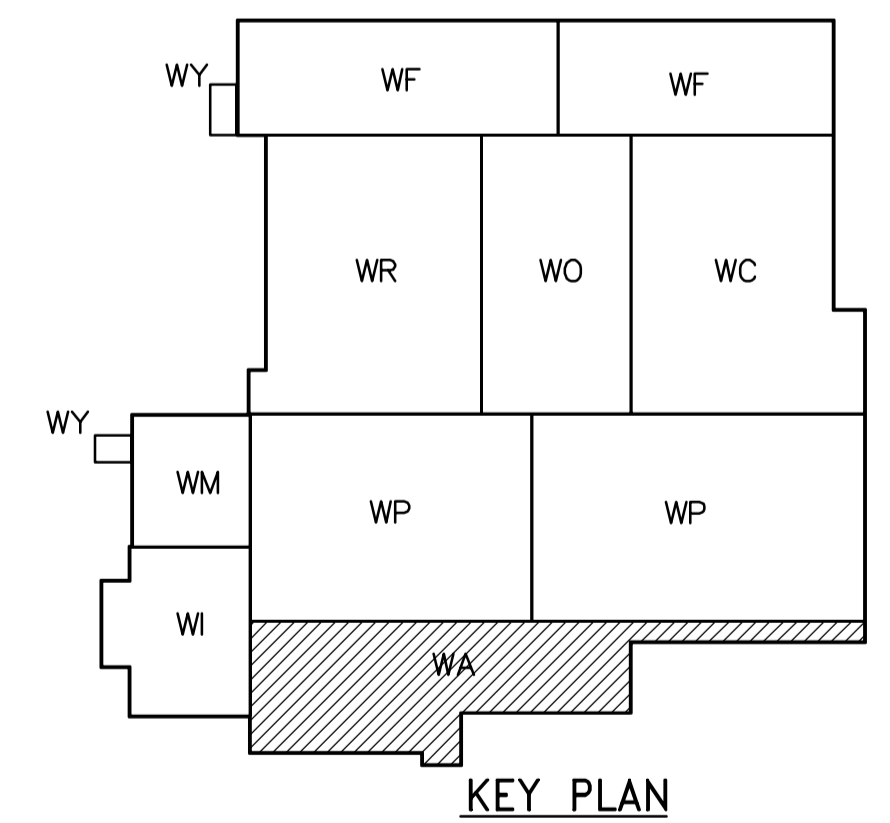

 Certificate of Authorization CH2M HILL Canada Ltd. No. 1441 Expiry: April 30, 2006	 Frederickson Cooper ARCHITECTS	 A Geo International Ltd. Company	ENGINEER'S SEAL	 THE CITY OF WINNIPEG WATER AND WASTE DEPARTMENT ENGINEERING DIVISION	CITY FILE NUMBER
			DESIGNED BY: LL CHECKED BY: ND DRAWN BY: TL APPROVED BY: AHL SCALE: 1:100 RELEASED FOR CONSTRUCTION BY: R. SOROKOWSKI		ORIGINAL SIGNED BY: L.D. LLÉWELLYN DATE: 2006/03/29 CONSULTANT DRAWING NO.: WA-E0147
B.M. ELEV.	00 ISSUED FOR TENDER 06/03/29 LL NO. REVISIONS DATE BY	DATE 2005/08/18 DATE 2006/03/29	ELECTRICAL ADMINISTRATION AREA ROOF POWER AND LIGHTING PLAN	CITY DRAWING NUMBER 1-0601A-A-E0147-001-000	