


BM

B11


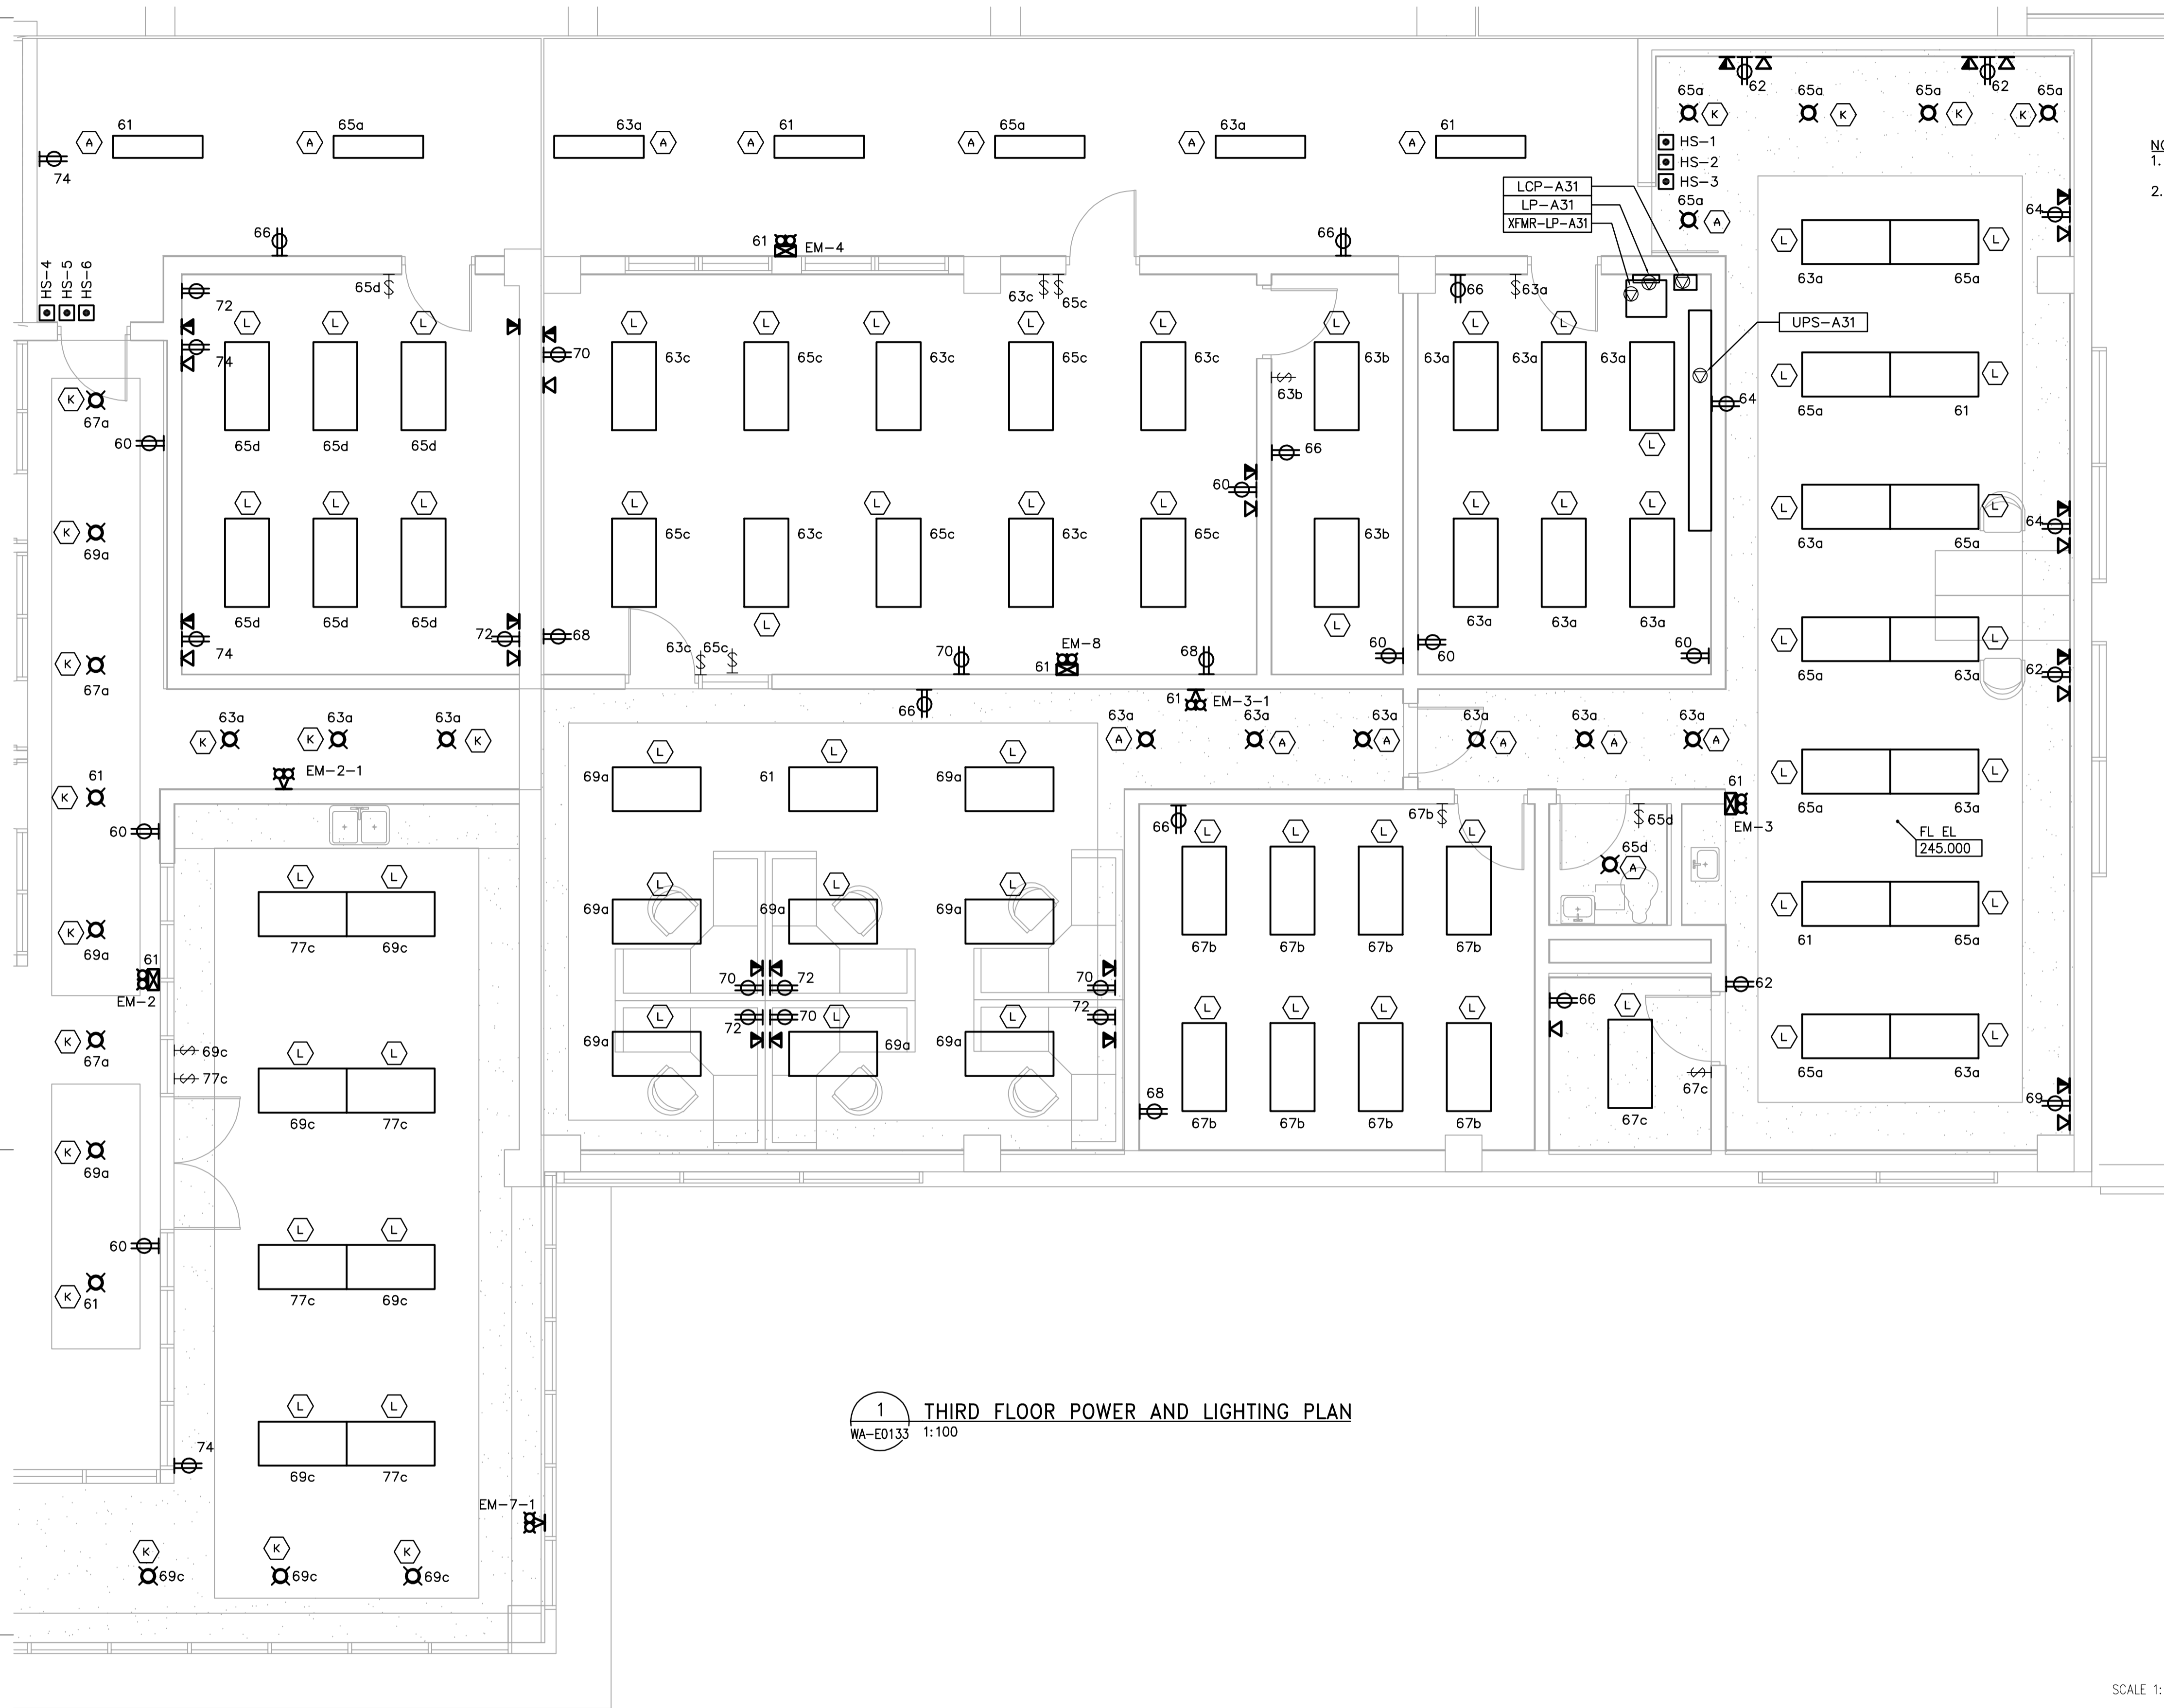


- NOTES:
1. ALL 120V AND 208V LOADS ARE FEED FROM LP-A31 UNLESS OTHERWISE NOTED.
  2. EMERGENCY LIGHTING EM-X-1 ARE FEED FROM BATTERY PACK EM-X.

BN

BP

1 THIRD FLOOR POWER AND LIGHTING PLAN  
WA-E0133 1:100

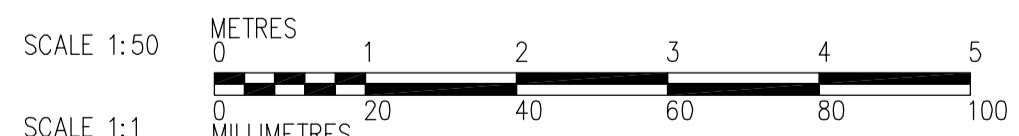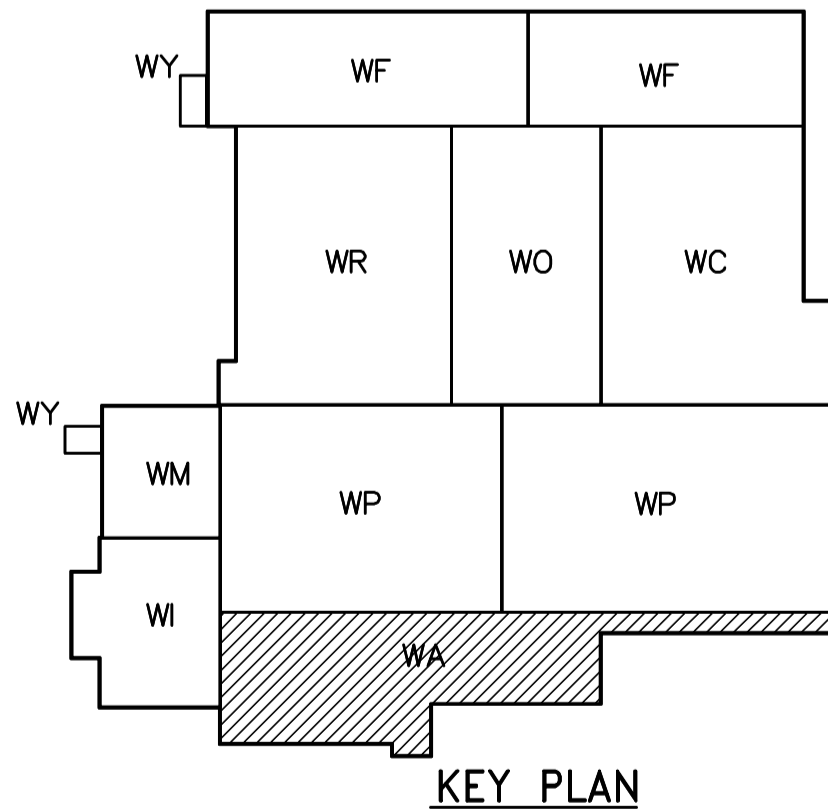

<p><b>APEGN</b> Certificate of Authorization CH2M HILL Canada Ltd. No. 1441 Expiry: April 30, 2006</p>	<p>Frederickson Cooper ARCHITECTS</p>	<p>A You International Ltd. Company</p>	ENGINEER'S SEAL	<p><b>THE CITY OF WINNIPEG</b> WATER AND WASTE DEPARTMENT ENGINEERING DIVISION</p>
			DESIGNED BY: LL CHECKED BY: ND DRAWN BY: TL APPROVED BY: AHL SCALE: 1:50 RELEASED FOR CONSTRUCTION BY: R. SOROKOWSKI DATE: 2006/03/10	