
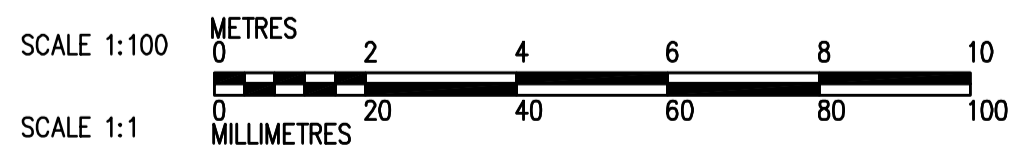


FIRST FLOOR PLAN
1:100

1 PIPING DETAIL
1:50

FIRST FLOOR PLAN (CONTINUATION)
1:100

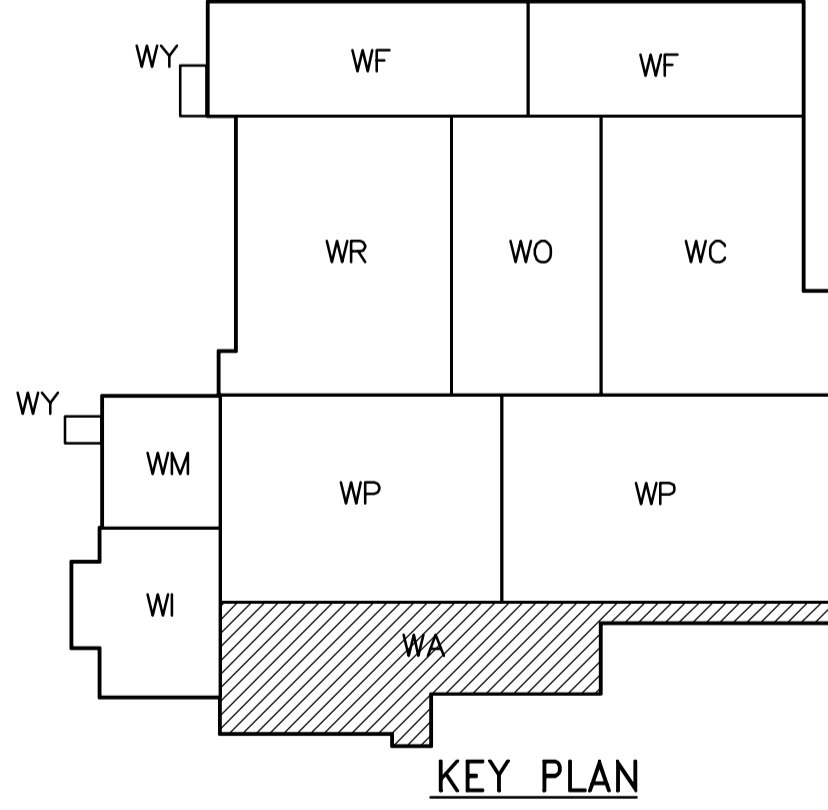

APECA
Certificate of Authorization
CH2M HILL Canada Ltd.
No. 1441 Expiry: April 30, 2006

B.M. ELEV.			
00 ISSUED FOR TENDER	06/03/29	SW	
NO. REVISIONS	DATE	BY	DATE
	2005/07/15		2006/03/29

CH2MHILL
Frederickson Cooper ARCHITECTS

EarthTech
A Tyco International Ltd. Company

DESIGNED BY: JZ/SW
DRAWN BY: JMcP
SCALE: 1:100

CHECKED BY: DL
APPROVED BY: AHL
RELEASED FOR CONSTRUCTION BY: R. SOROKOWSKI
DATE: 2006/03/29

ENGINEER'S SEAL
ORIGINAL SIGNED BY: D.K. CUDDINGTON
2006/03/29
CONSULTANT DRAWING NO.: WA-H0112

THE CITY OF WINNIPEG
WATER AND WASTE DEPARTMENT
ENGINEERING DIVISION

WATER TREATMENT PLANT
ADMINISTRATION
MECHANICAL AND ELECTRICAL

PLUMBING
ADMINISTRATION AREA
FIRST FLOOR PLAN

CITY FILE NUMBER
SHEET OF
CITY DRAWING NUMBER
1-0601A-A-H0112-001-000