
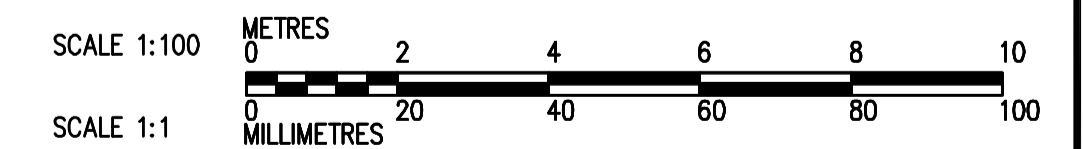


ROOF PLAN
1:100

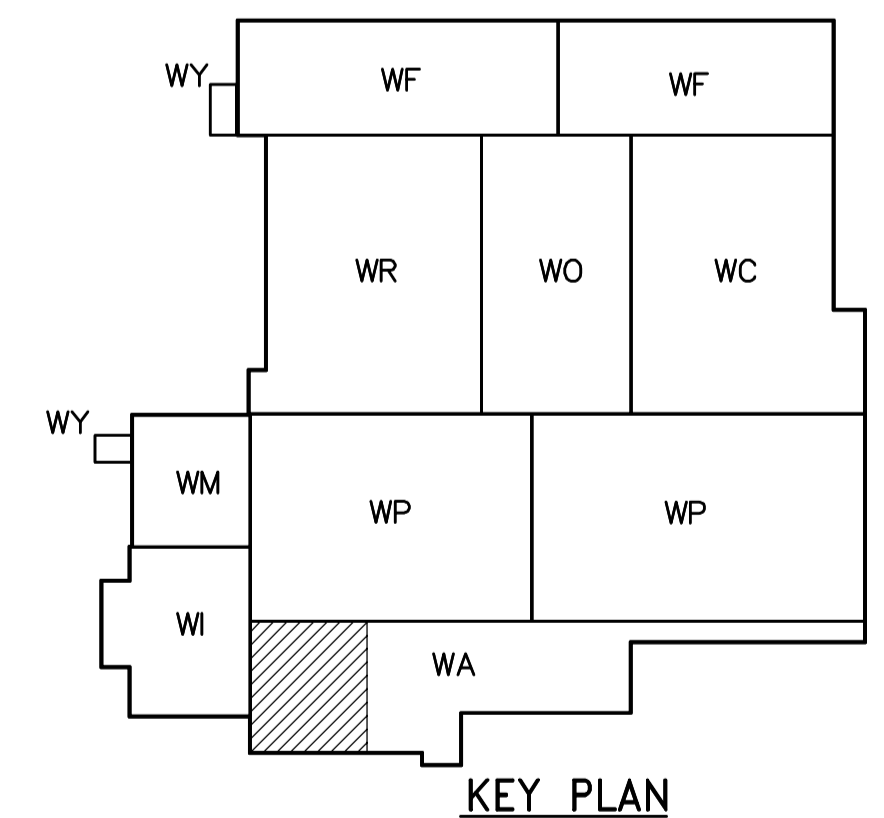

<p>APEGN Certificate of Authorization CH2M HILL Canada Ltd. No. 1441 Expiry: April 30, 2006</p>	<p>Frederickson Cooper ARCHITECTS</p>		<p>A Geo International Ltd. Company</p>		ENGINEER'S SEAL ORIGINAL SIGNED BY D.K. CUDDINGTON 2006/03/29	<p>THE CITY OF WINNIPEG WATER AND WASTE DEPARTMENT ENGINEERING DIVISION</p>	WATER TREATMENT PLANT ADMINISTRATION MECHANICAL AND ELECTRICAL	CITY FILE NUMBER SHEET OF
	DESIGNED BY JZ/SW CHECKED BY DL		DRAWN BY JMcP APPROVED BY AHL		CONSULTANT DRAWING NO. WA-H0146		PLUMBING ADMINISTRATION AREA ROOF PLAN	CITY DRAWING NUMBER 1-0601A-A-H0146-001-000
	SCALE: 1:100		RELEASED FOR CONSTRUCTION BY: R. SOROKOWSKI				NO. REVISIONS DATE BY	DATE 2005/07/15 DATE 2006/03/29
	00 ISSUED FOR TENDER 06/03/29 SW							