


LIMIT OF MECHANICAL AND ELECTRICAL CONTRACT 742-2005

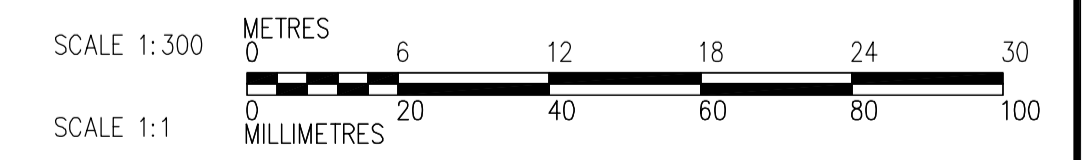

<p>APEGN Certificate of Authorization CH2M HILL Canada Ltd. No. 1441 Expiry: April 30, 2006</p>	<p>Frederickson Cooper ARCHITECTS</p>		<p>EarthTech A Geo International Ltd. Company</p>		ENGINEER'S SEAL ORIGINAL SIGNED BY L.D. LLEWELLYN 2006/03/29	<p>THE CITY OF WINNIPEG WATER AND WASTE DEPARTMENT ENGINEERING DIVISION</p>	
	DESIGNED BY LL CHECKED BY ND DRAWN BY TL APPROVED BY AHL		SCALE: 1:300 RELEASED FOR CONSTRUCTION BY: R. SOROKOWSKI		CONSULTANT DRAWING NO. WB-E0120		
	00 ISSUED FOR TENDER 06/03/29 LL NO. REVISIONS DATE BY		DATE 2005/06/29 DATE 2006/03/29		WATER TREATMENT PLANT MAIN BUILDING MECHANICAL AND ELECTRICAL		CITY FILE NUMBER SHEET OF
					ELECTRICAL OVERALL BUILDING SECOND FLOOR PLAN		CITY DRAWING NUMBER 1-0601B-A-E0120-001-000