


**THIRD FLOOR PLAN**  
1:300

--- LIMIT OF MECHANICAL AND ELECTRICAL CONTRACT 742-2005

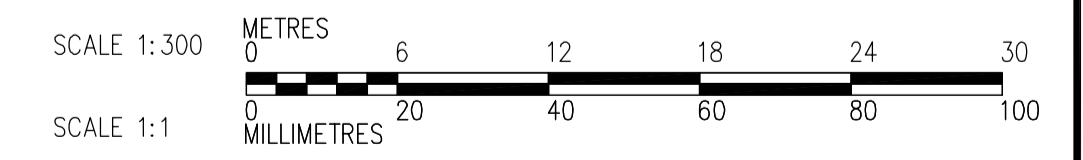

 <b>APEGN</b> Certificate of Authorization CH2M HILL Canada Ltd. No. 1441 Expiry: April 30, 2006	B.M. ELEV.	 Frederickson Cooper ARCHITECTS	 A Terra International Ltd. Company	ENGINEER'S SEAL  ORIGINAL SIGNED BY L.D. LLEWELLYN 2006/03/29	 <b>THE CITY OF WINNIPEG</b> WATER AND WASTE DEPARTMENT ENGINEERING DIVISION
	00 ISSUED FOR TENDER 06/03/29 LL			DESIGNED BY LL CHECKED BY ND DRAWN BY TL APPROVED BY AHL	
	NO. REVISIONS DATE BY DATE 2005/06/29 DATE 2006/03/29	SCALE: 1:300 RELEASED FOR CONSTRUCTION BY: R. SOROKOWSKI	CONSULTANT DRAWING NO. WB-E0130	CITY FILE NUMBER SHEET OF CITY DRAWING NUMBER 1-0601B-A-E0130-001-000	
				ELECTRICAL OVERALL BUILDING THIRD FLOOR PLAN	