


- NOTES:
1. REFER TO DWG WM-E0011 AND WM-H0001 FOR SYMBOL LEGENDS.
 2. REFER TO HVAC DRAWINGS FOR DUCT MOUNTED SMOKE DETECTOR LOCATIONS.

SECOND FLOOR PLAN
1:300

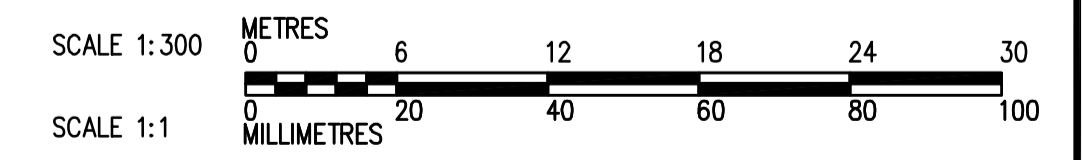

<p>APEGN Certificate of Authorization CH2M HILL Canada Ltd. No. 1441 Expiry: April 30, 2006</p>	<p>Frederickson Cooper ARCHITECTS</p>	<p>EarthTech A Tyco International Ltd. Company</p>	ENGINEER'S SEAL	<p>THE CITY OF WINNIPEG WATER AND WASTE DEPARTMENT ENGINEERING DIVISION</p>		
			DESIGNED BY DKC		CHECKED BY SW	ORIGINAL SIGNED BY D.K. CUDDINGTON
			DRAWN BY JMcP		APPROVED BY AHL	2006/03/29
			SCALE: 1:300		RELEASED FOR CONSTRUCTION BY: R. SOROKOWSKI	CONSULTANT DRAWING NO. WB-H0122
00 ISSUED FOR TENDER	06/03/29 DKC	2006/01/06	2006/03/29	<p>WATER TREATMENT PLANT MAIN BUILDING MECHANICAL AND ELECTRICAL</p> <p>CITY FILE NUMBER</p> <p>SHEET OF</p> <p>CITY DRAWING NUMBER</p> <p>1-0601B-A-H0122-001-000</p>		