


NOT IN CONTRACT - FOR INFORMATION ONLY

**FIRST FLOOR PLAN**  
1:300

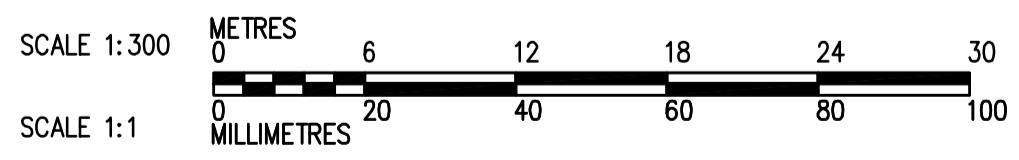

FOUNDATIONS AND CONCRETE STRUCTURES CONTRACT 583-2005

 <b>APEGN</b> Certificate of Authorization CH2M HILL Canada Ltd. No. 1441 Expiry: April 30, 2006	B.M. ELEV.	 Frederickson Cooper ARCHITECTS	 A Terra International Ltd. Company	ENGINEER'S SEAL  ORIGINAL SIGNED BY D.K. CUDDINGTON  2006/02/06	 <b>THE CITY OF WINNIPEG</b> WATER AND WASTE DEPARTMENT ENGINEERING DIVISION	CITY FILE NUMBER  SHEET OF
	DESIGNED BY: JZ/SW DRAWN BY: JMcP SCALE: 1:300 00 ISSUED FOR TENDER 2006/02/03 SW NO. REVISIONS DATE BY DATE 2005/07/15	CHECKED BY: DL APPROVED BY: DJT RELEASED FOR CONSTRUCTION BY: R. SOROKOWSKI DATE 2006/02/08	CONSULTANT DRAWING NO. WB-H9111	WATER TREATMENT PLANT MAIN BUILDING FOUNDATIONS AND CONCRETE STRUCTURES  PLUMBING PIPE EMBEDS OVERALL FIRST FLOOR PLAN	CITY DRAWING NUMBER <b>1-0601B-A-H9111-001-000</b>	