


NOT IN CONTRACT - FOR INFORMATION ONLY

FOUNDATIONS AND CONCRETE STRUCTURES CONTRACT 583-2005

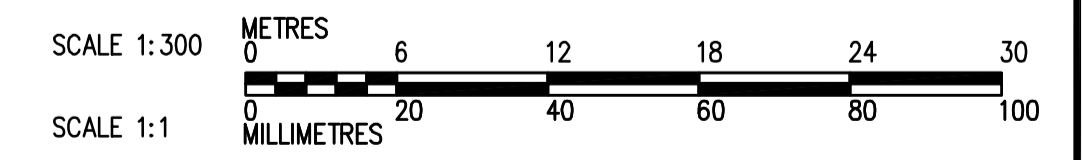

SECOND FLOOR PLAN
1:100

 APEGN Certificate of Authorization CH2M HILL Canada Ltd. No. 1441 Expiry: April 30, 2006	B.M. ELEV.	 Frederickson Cooper ARCHITECTS	 A Terra International Ltd. Company	ENGINEER'S SEAL	 THE CITY OF WINNIPEG WATER AND WASTE DEPARTMENT ENGINEERING DIVISION WATER TREATMENT PLANT MAIN BUILDING FOUNDATIONS AND CONCRETE STRUCTURES PLUMBING PIPE EMBEDS OVERALL SECOND FLOOR PLAN	CITY FILE NUMBER
				DESIGNED BY: JZ/SW DRAWN BY: JMcP SCALE: 1:300 INO. REVISIONS		CHECKED BY: DL APPROVED BY: DJT RELEASED FOR CONSTRUCTION BY: R. SOROKOWSKI DATE: 2006/02/08