



LCP-F020B

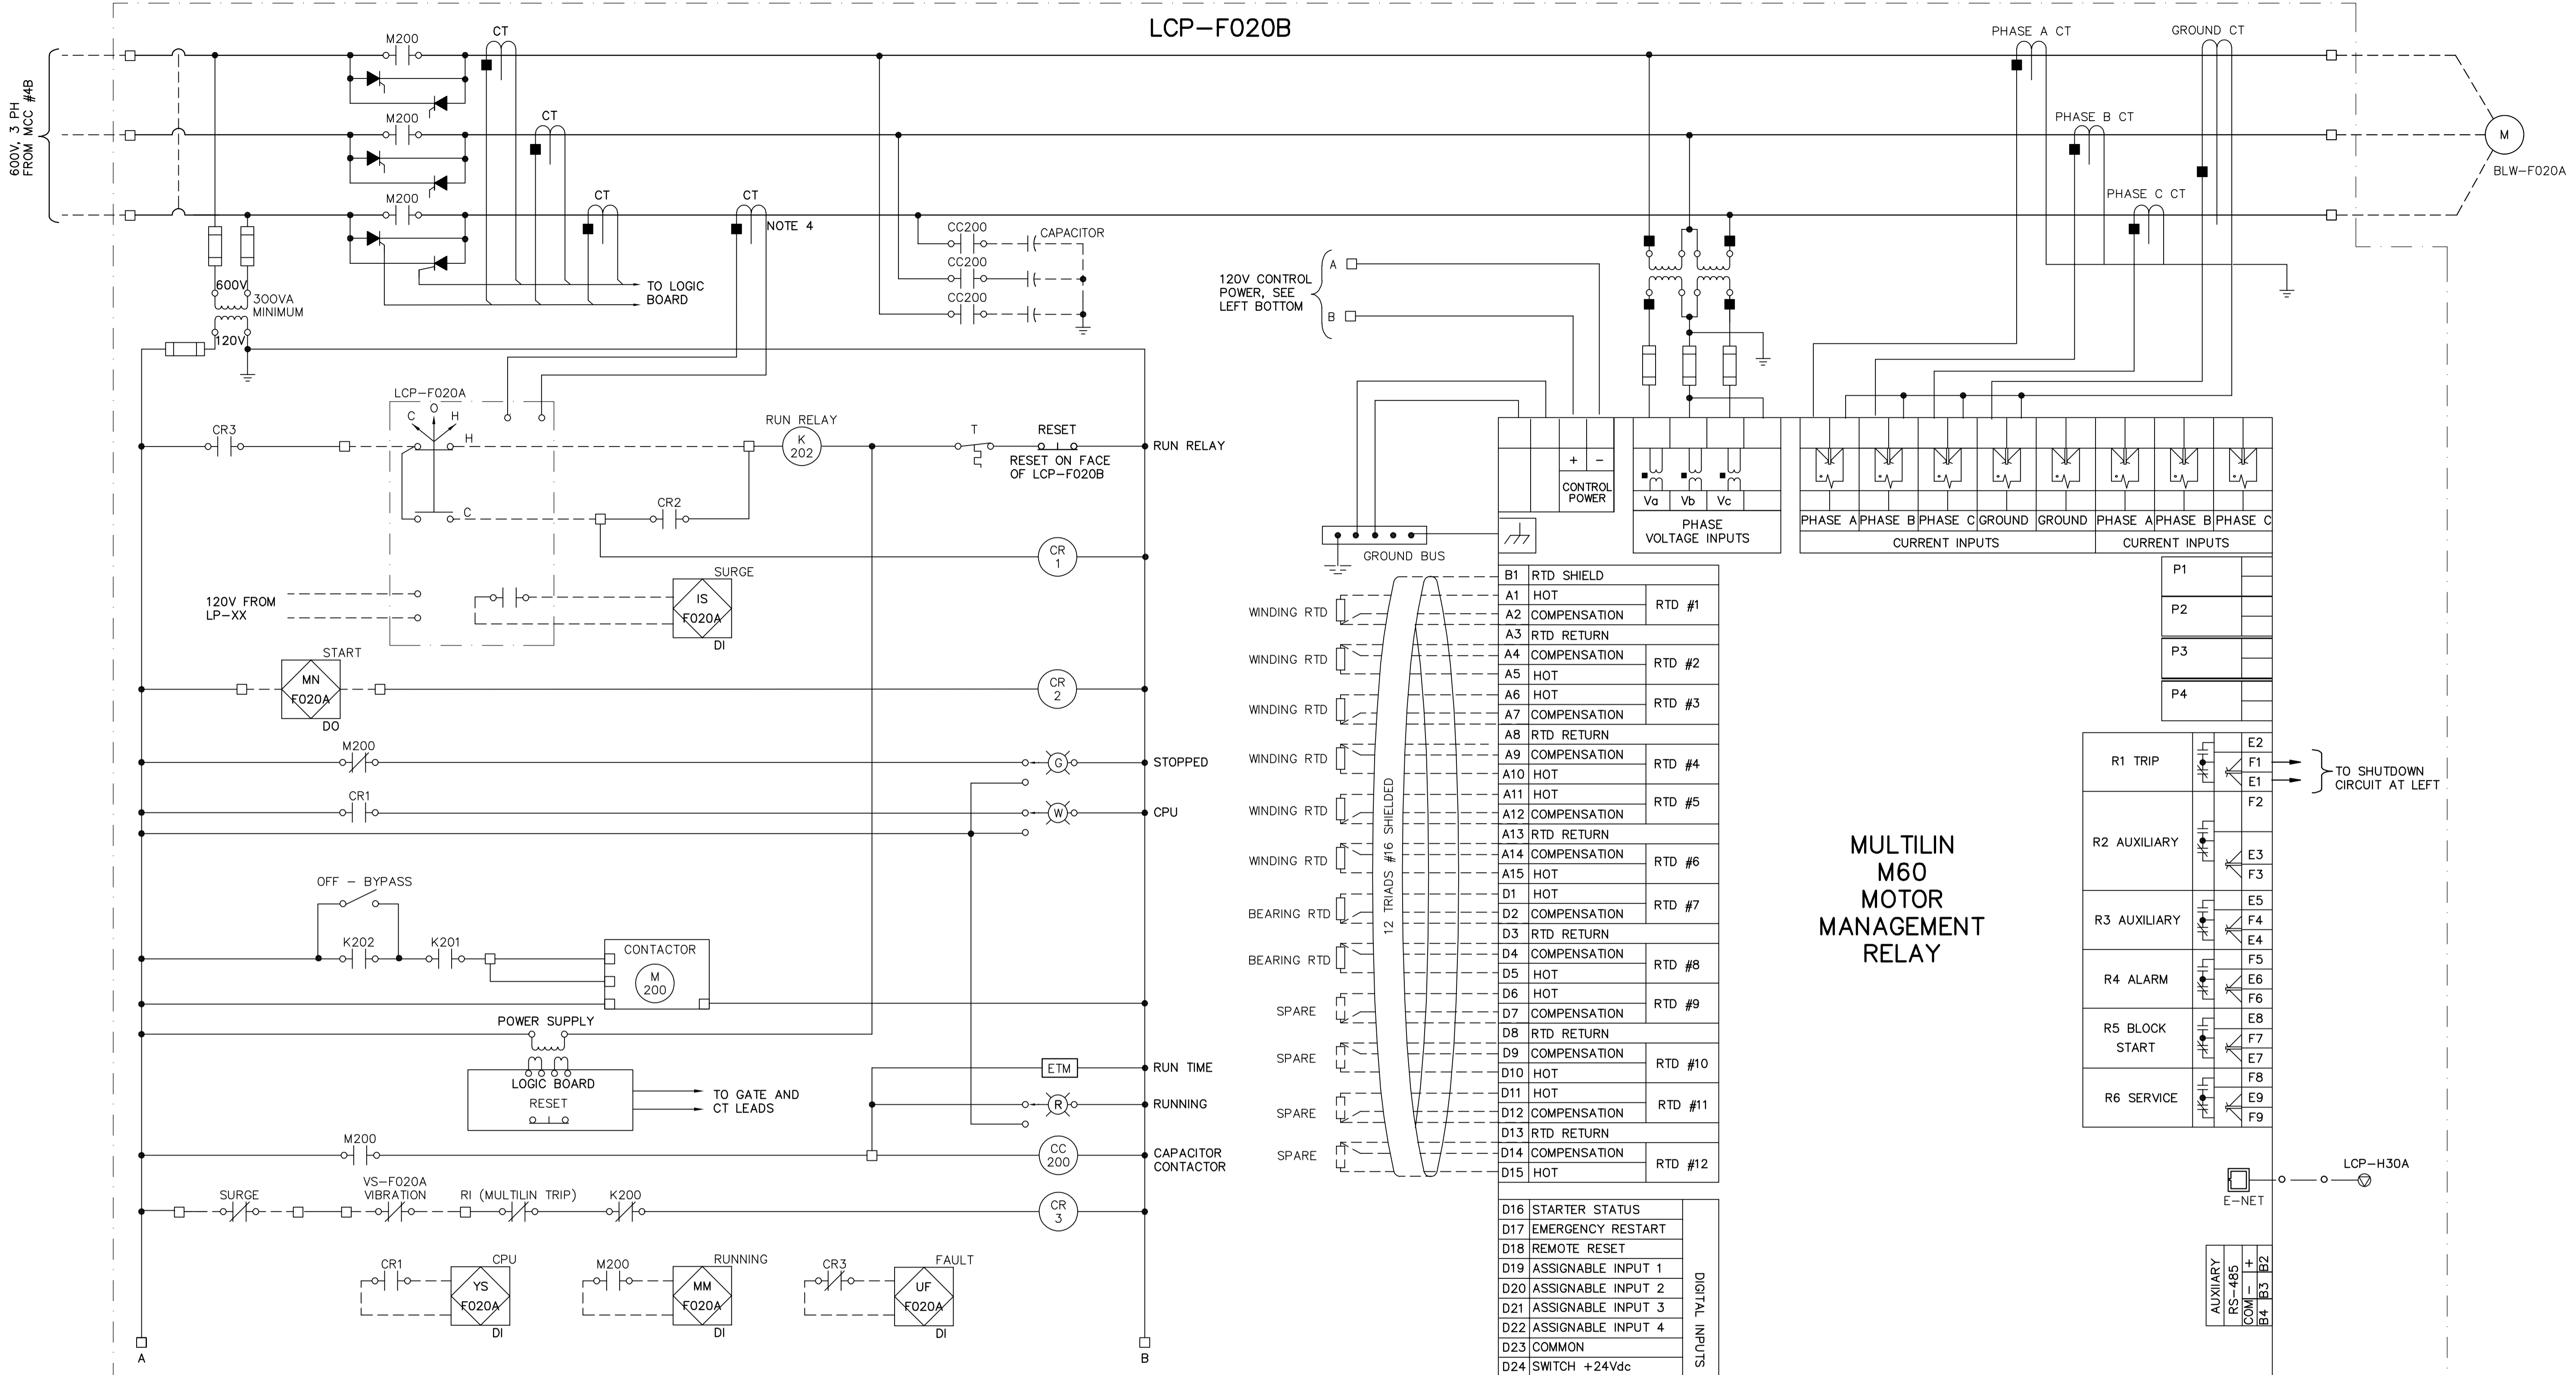

120V CONTROL POWER, SEE LEFT BOTTOM

WINDING RTD	B1 RTD SHIELD	
WINDING RTD	A1 HOT	RTD #1
WINDING RTD	A2 COMPENSATION	
WINDING RTD	A3 RTD RETURN	
WINDING RTD	A4 COMPENSATION	RTD #2
WINDING RTD	A5 HOT	
WINDING RTD	A6 HOT	RTD #3
WINDING RTD	A7 COMPENSATION	
WINDING RTD	A8 RTD RETURN	
WINDING RTD	A9 COMPENSATION	RTD #4
WINDING RTD	A10 HOT	
WINDING RTD	A11 HOT	RTD #5
WINDING RTD	A12 COMPENSATION	
WINDING RTD	A13 RTD RETURN	
WINDING RTD	A14 COMPENSATION	RTD #6
WINDING RTD	A15 HOT	
BEARING RTD	D1 HOT	RTD #7
BEARING RTD	D2 COMPENSATION	
BEARING RTD	D3 RTD RETURN	
BEARING RTD	D4 COMPENSATION	RTD #8
BEARING RTD	D5 HOT	
BEARING RTD	D6 HOT	RTD #9
BEARING RTD	D7 COMPENSATION	
BEARING RTD	D8 RTD RETURN	
BEARING RTD	D9 COMPENSATION	RTD #10
BEARING RTD	D10 HOT	
BEARING RTD	D11 HOT	RTD #11
BEARING RTD	D12 COMPENSATION	
BEARING RTD	D13 RTD RETURN	
BEARING RTD	D14 COMPENSATION	RTD #12
BEARING RTD	D15 HOT	

MULTILIN M60 MOTOR MANAGEMENT RELAY

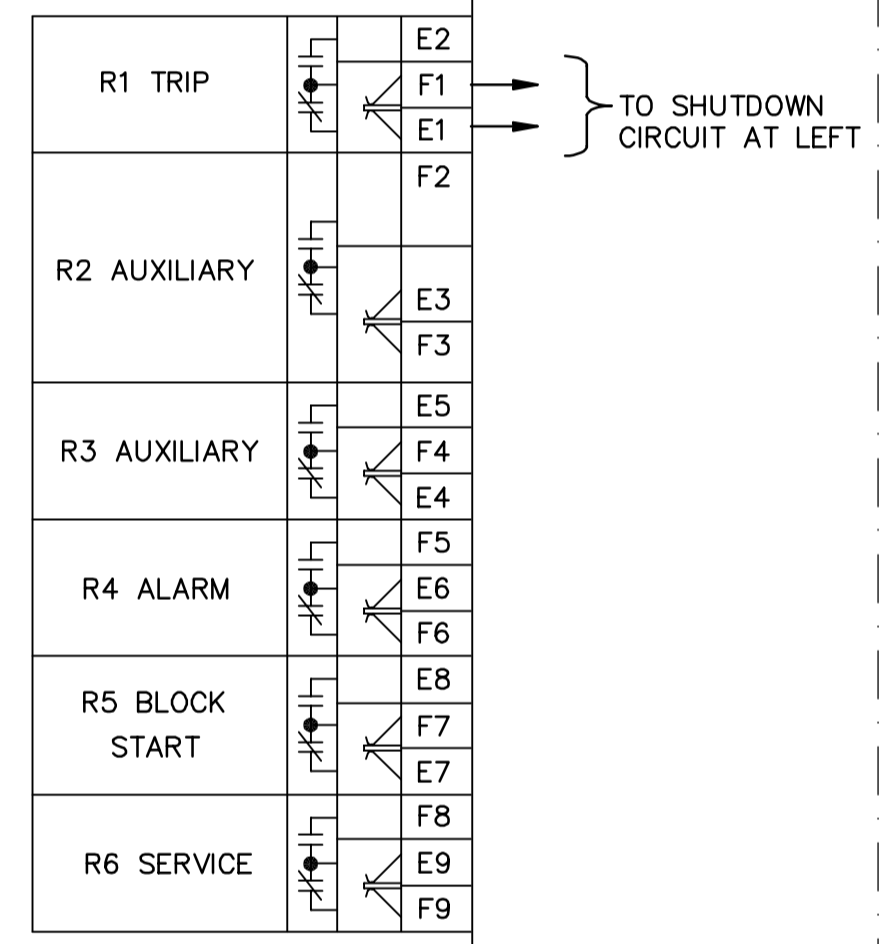

- NOTES:
1. END OF-RAMP RELAY (K201) AND TRIP RELAY (K200) ARE PART OF LOGIC BOARD.
  2. LCP-F020A - SUPPLIED BY BLOWER SUPPLIER
  3. REFER TO P&ID AND SPECIFICATION FOR ADDITIONAL WIRING BETWEEN MANUFACTURER SUPPLIED FIELD DEVICES AND LP-H31
  4. CT SUPPLIED BY BLOWER SUPPLIER, INSTALLED IN THE MCC.

FILTER AIR SCOUR BLOWER 1 (BLW-F020A)

<p>Certificate of Authorization CH2M HILL Canada Ltd. No. 1441 Expiry: April 30, 2006</p>	<p>Frederickson Cooper ARCHITECTS</p>	<p>A Terra International Ltd. Company</p>	ENGINEER'S SEAL ORIGINAL SIGNED BY L.D. LLEWELLYN 2006/03/29	<p>THE CITY OF WINNIPEG WATER AND WASTE DEPARTMENT ENGINEERING DIVISION</p>
			CONSULTANT DRAWING NO. WB-E0560	
DESIGNED BY JT CHECKED BY ND DRAWN BY KJ APPROVED BY AHL SCALE: NTS RELEASED FOR CONSTRUCTION BY: R. SOROKOWSKI		CITY FILE NUMBER SHEET OF CITY DRAWING NUMBER 1-0601B-H-E0560-001-000		
00 ISSUED FOR TENDER 06/03/29 LL NO. REVISIONS DATE BY		DATE 2005/11/08 DATE 2006/03/29		