

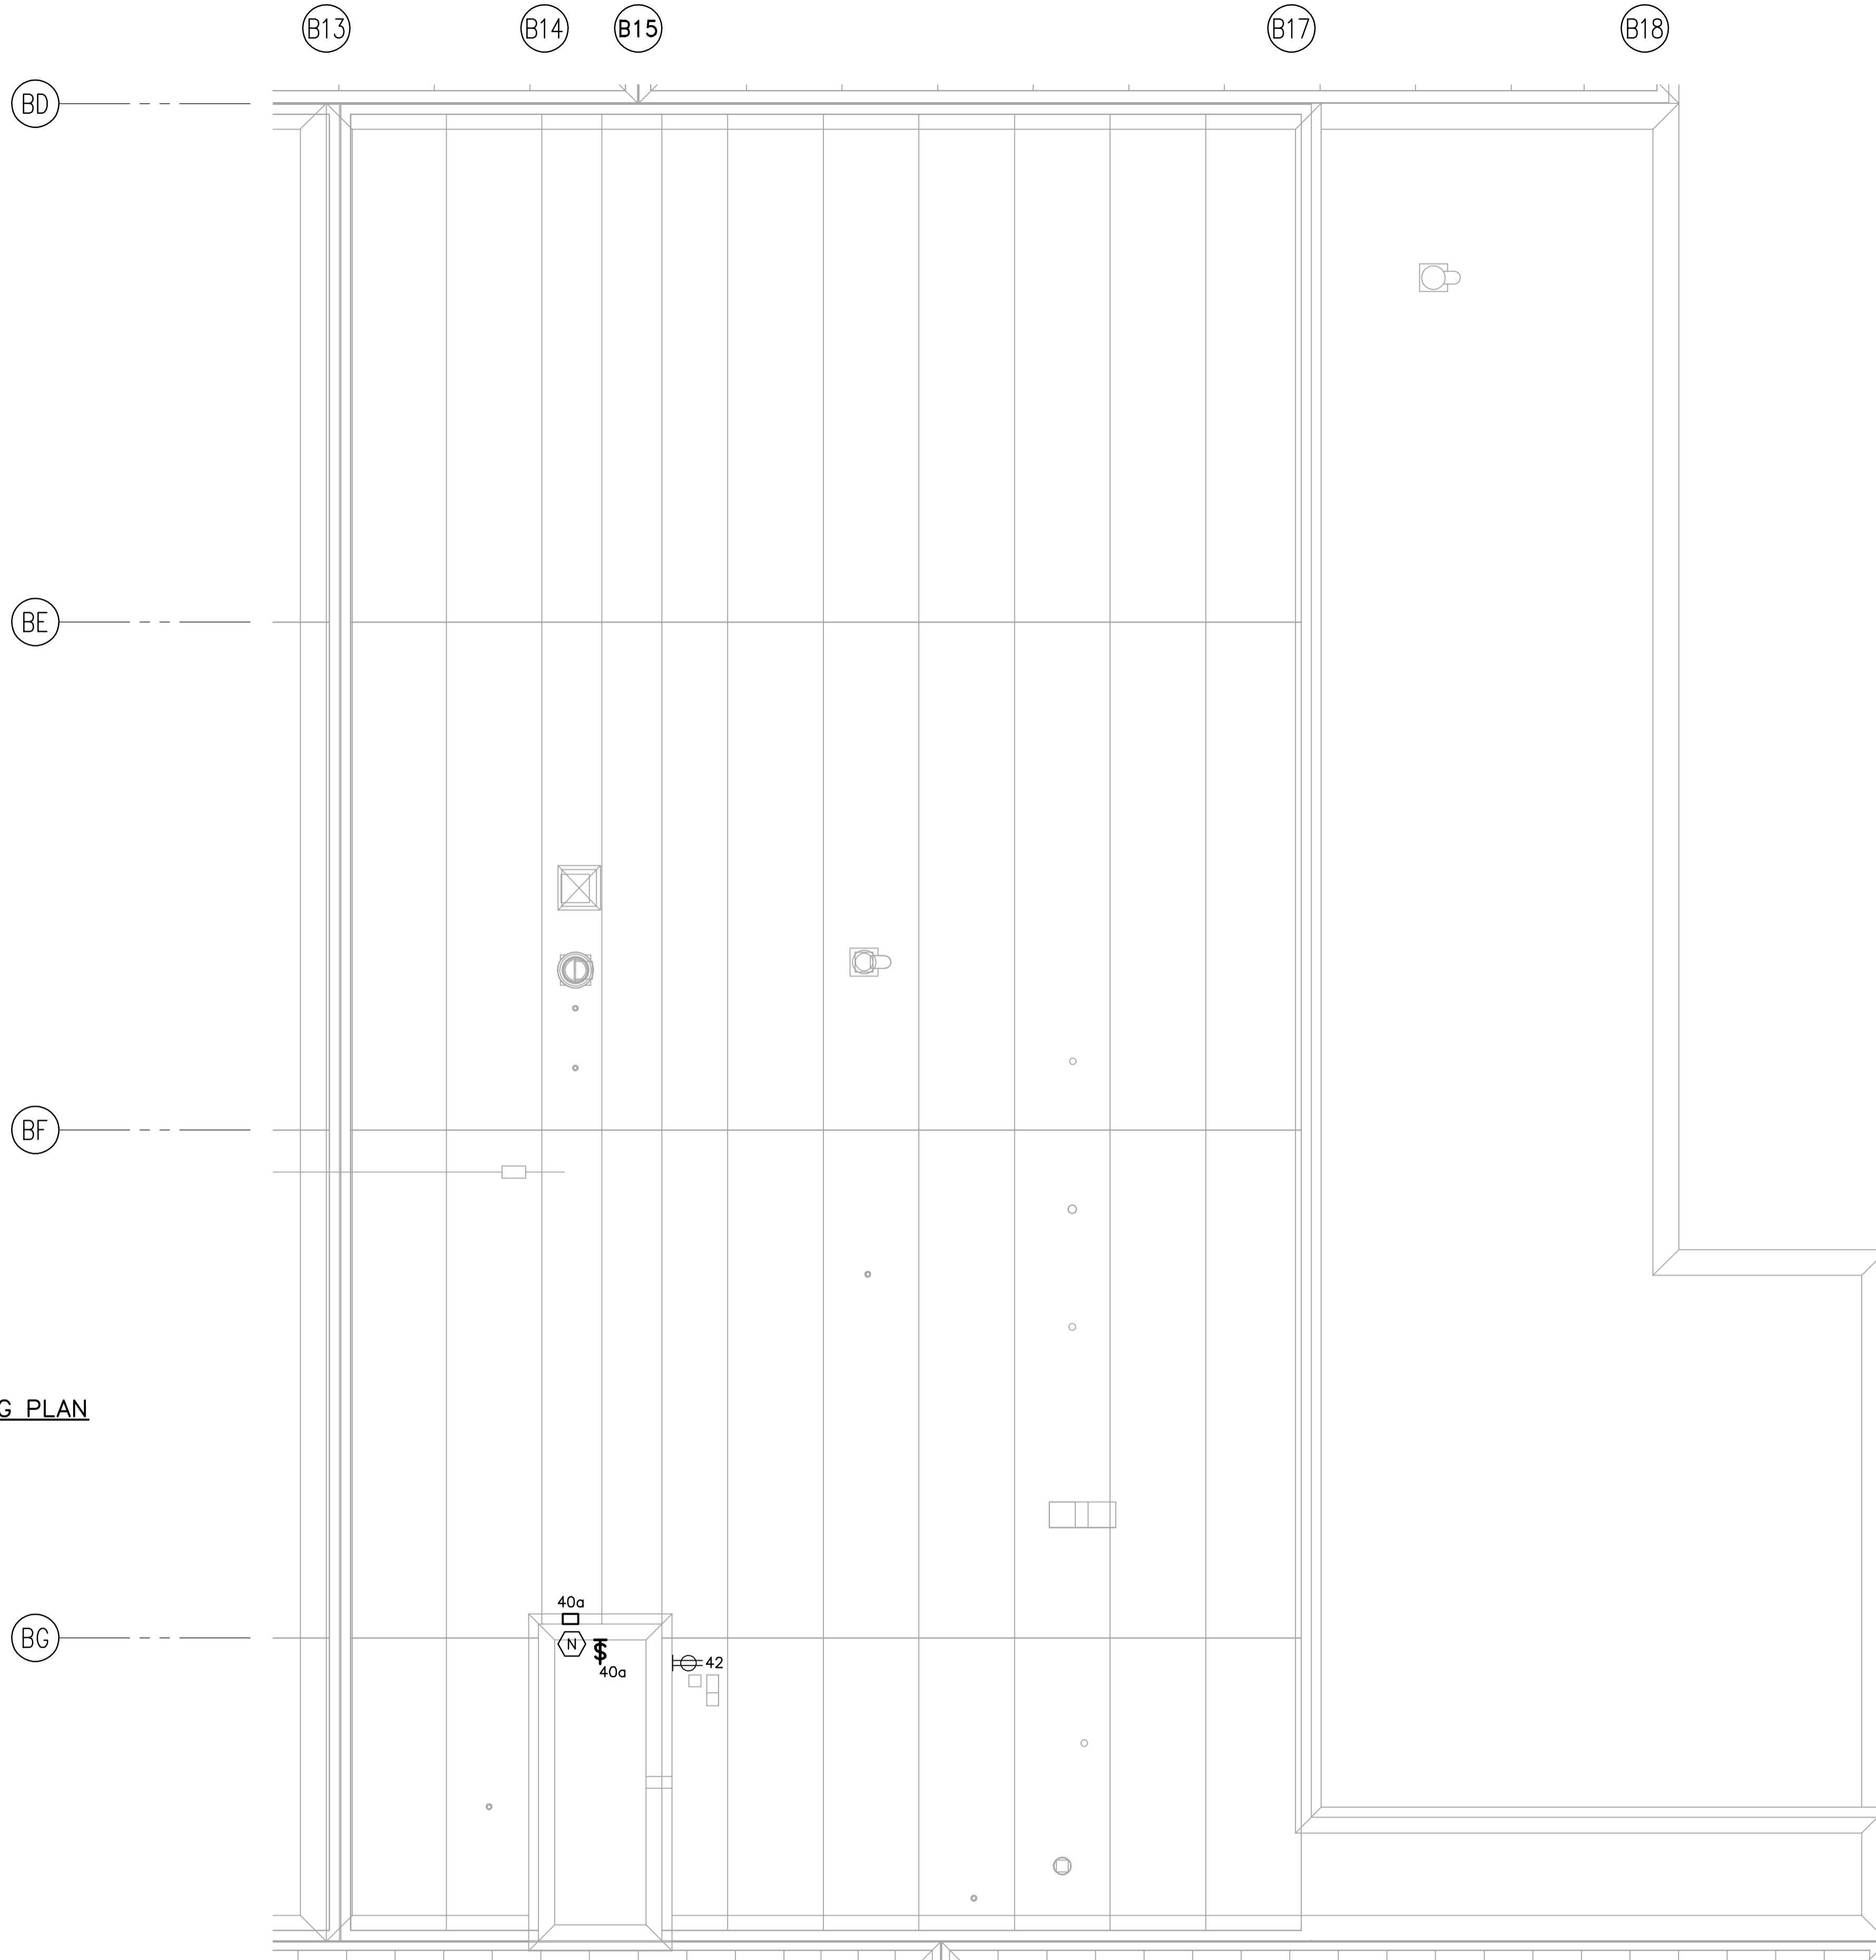


ROOF POWER AND LIGHTING PLAN
1:100

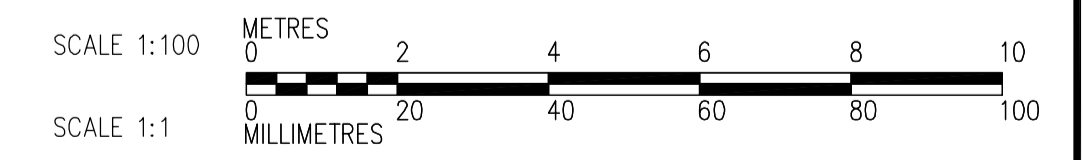

NOTES:
1. ALL 120V AND 208V LOADS ARE FED FROM LP-H31.

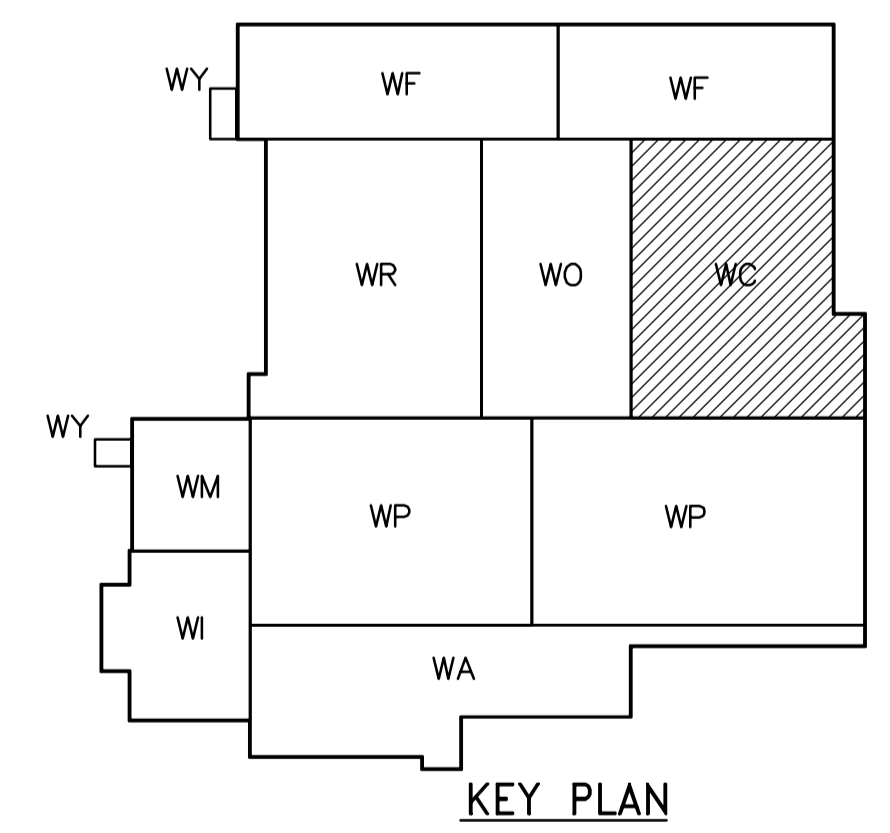

APECA
Certificate of Authorization
CH2M HILL Canada Ltd.
No. 1441 Expiry: April 30, 2006

B.M. ELEV.			
DESIGNED BY	LL	CHECKED BY	ND
DRAWN BY	TL	APPROVED BY	AHL
SCALE:	1:100	RELEASED FOR CONSTRUCTION BY:	R. SOROKOWSKI
00 ISSUED FOR TENDER	06/03/29	DATE	2006/02/11
NO. REVISIONS		DATE	2006/03/29

CH2MHILL
Frederickson Cooper
ARCHITECTS

EarthTech
A Tyco International Ltd. Company

DESIGNED BY: LL
DRAWN BY: TL
SCALE: 1:100

CHECKED BY: ND
APPROVED BY: AHL
RELEASED FOR CONSTRUCTION BY: R. SOROKOWSKI
DATE: 2006/03/29

ENGINEER'S SEAL
ORIGINAL SIGNED BY
L.D. LLEWELLYN
2006/03/29
CONSULTANT DRAWING NO.
WC-E0147

THE CITY OF WINNIPEG
WATER AND WASTE DEPARTMENT
ENGINEERING DIVISION

WATER TREATMENT PLANT
CHEMICAL FEED SYSTEMS
MECHANICAL AND ELECTRICAL

ELECTICAL
CHEMICAL AREA
ROOF POWER AND LIGHTING PLAN

CITY FILE NUMBER
SHEET OF
CITY DRAWING NUMBER
1-0601C-A-E0147-001-000