
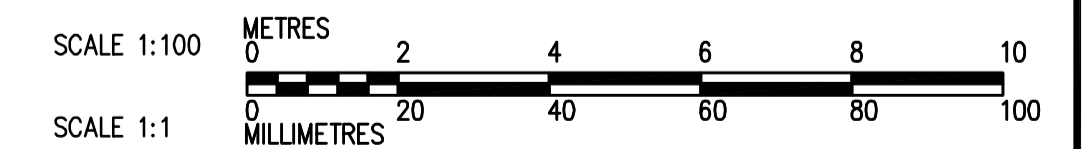


ROOF PLAN
1:100

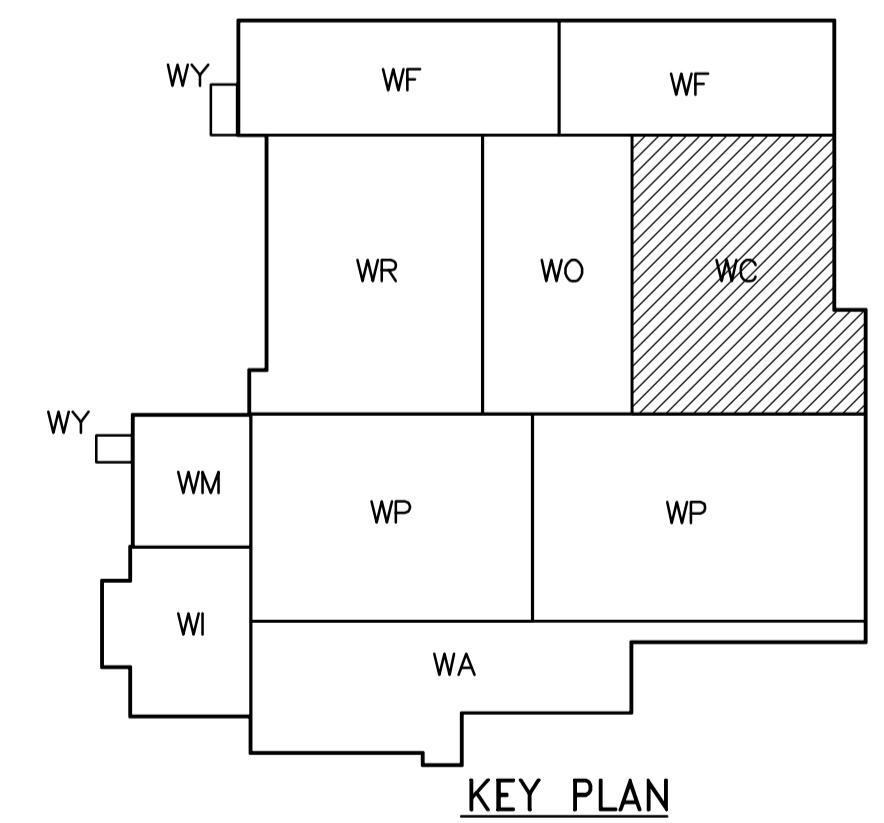

 APEGN Certificate of Authorization CH2M HILL Canada Ltd. No. 1441 Expiry: April 30, 2006	B.M. ELEV.	 Frederickson Cooper ARCHITECTS	 A Terra International Ltd. Company	ENGINEER'S SEAL ORIGINAL SIGNED BY D.K. CUDDINGTON 2006/03/29	 THE CITY OF WINNIPEG WATER AND WASTE DEPARTMENT ENGINEERING DIVISION WATER TREATMENT PLANT CHEMICAL FEED SYSTEMS MECHANICAL AND ELECTRICAL PLUMBING CHEMICAL AREA ROOF PLAN	CITY FILE NUMBER
	00 ISSUED FOR TENDER 06/03/29 JZ	DESIGNED BY JZ CHECKED BY DL DRAWN BY JMcP APPROVED BY AHL	CONSULTANT DRAWING NO. WC-H0142	SHEET OF		
	NO. REVISIONS DATE BY DATE 2005/08/02 DATE 2006/03/29	SCALE: 1:100 RELEASED FOR CONSTRUCTION BY: R. SOROKOWSKI	CITY DRAWING NUMBER 1-0601C-A-H0142-001-000			