


NOT IN CONTRACT - FOR INFORMATION ONLY

2
WC-M9111 1:50
DETAIL

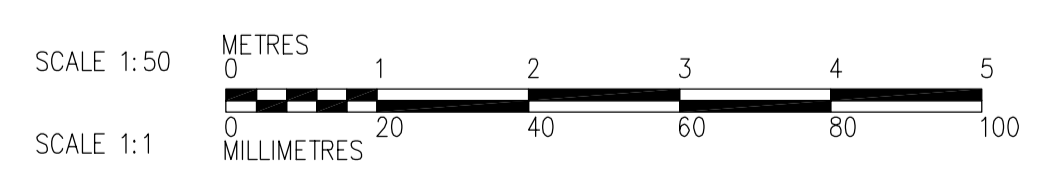

 Certificate of Authorization CH2M HILL Canada Ltd. No. 1441 Expiry: April 30, 2006	 Frederickson Cooper ARCHITECTS	 A Terra International Ltd. Company	ENGINEER'S SEAL	 THE CITY OF WINNIPEG WATER AND WASTE DEPARTMENT ENGINEERING DIVISION	CITY FILE NUMBER SHEET OF CITY DRAWING NUMBER 1-0601C-A-M9402-001-00D
			DESIGNED BY: KS CHECKED BY: NW DRAWN BY: YFS APPROVED BY: DJT SCALE: 1:50 RELEASED FOR CONSTRUCTION BY: R. SOROKOWSKI		
B.M. ELEV.			POLYMER AREA SECOND FLOOR PLAN DETAIL		
00 ISSUED FOR TENDER 2006/02/03 KS			DATE 2005/10/14 DATE 2006/02/08		
NO. REVISIONS DATE BY					