

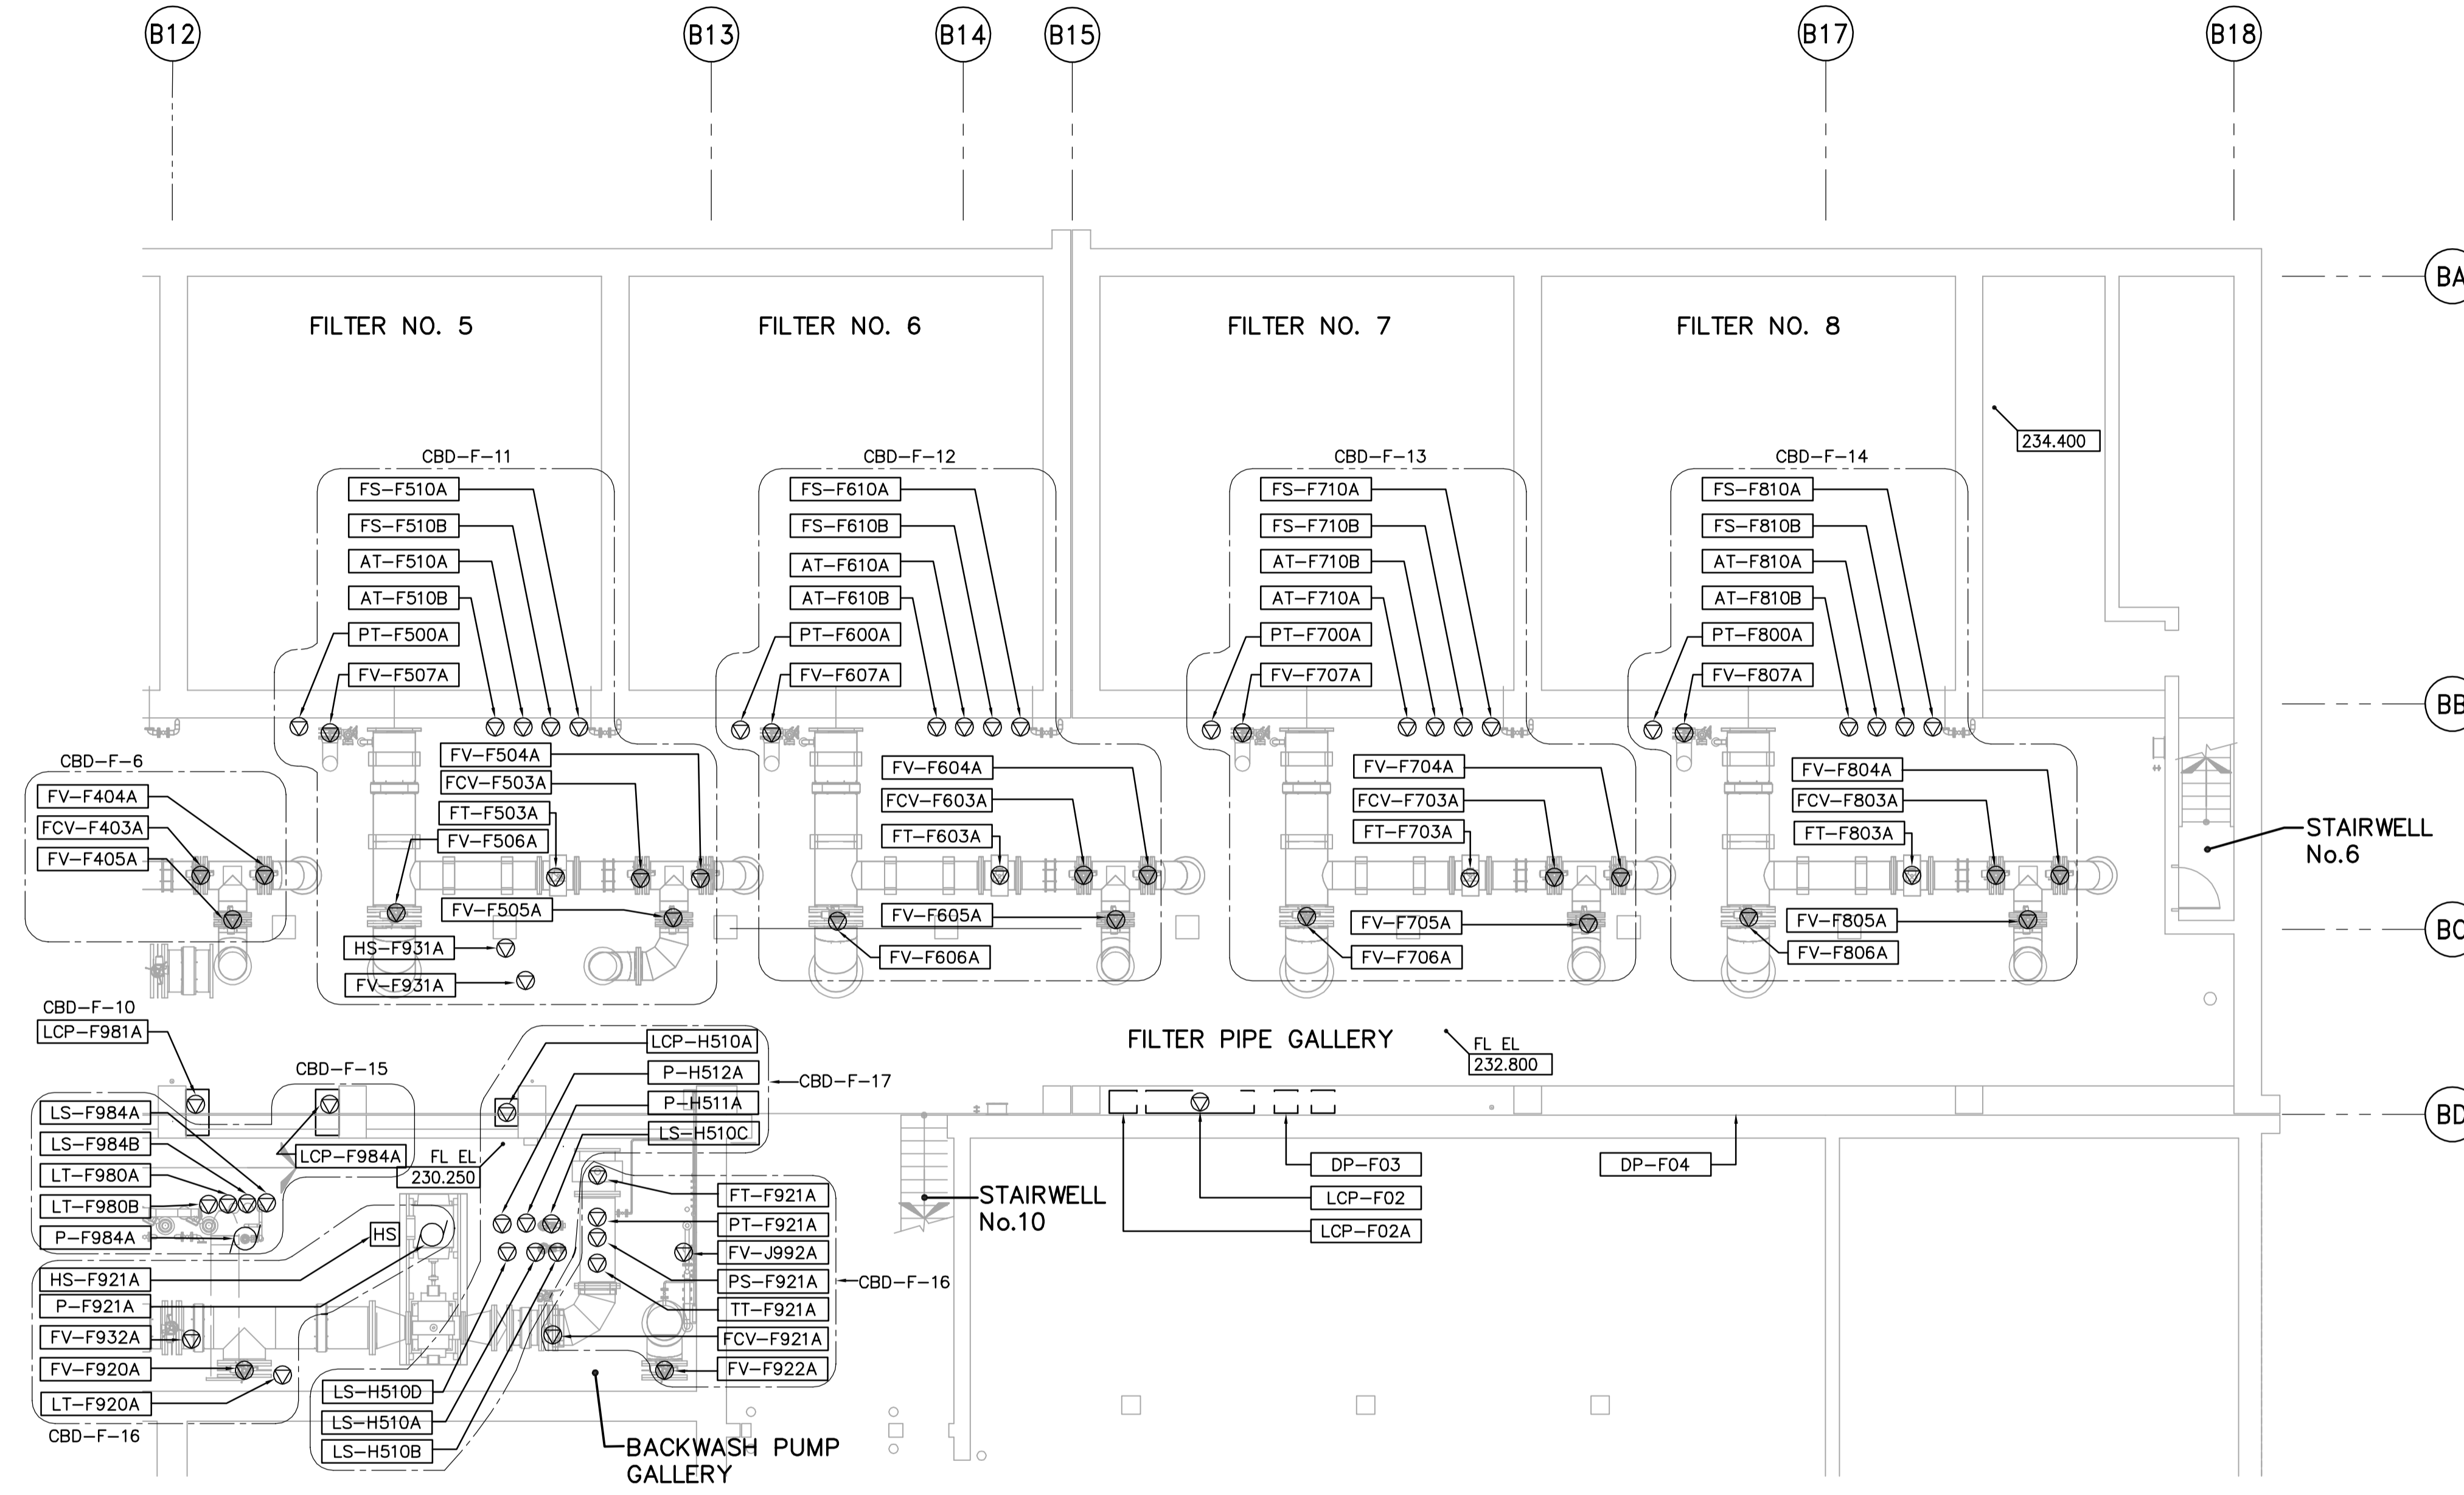


- NOTES:**
- SEE MCC #1A & #1B SINGLE LINE DIAGRAM AND DP-F01, DP-F02, DP-F03 AND DP-F04 POWER DISTRIBUTION FOR 600V POWER DISTRIBUTION.
 - SEE LP-F01 FOR 120/208V POWER DISTRIBUTION.

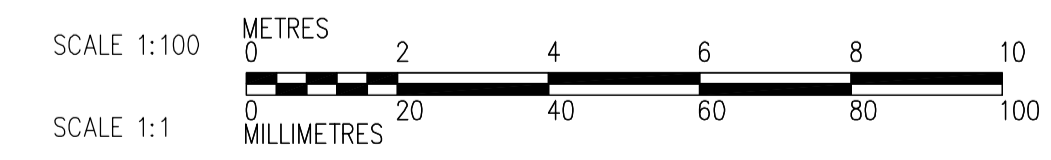

LOWER LEVEL PROCESS PLAN (AREA 2)
1:100

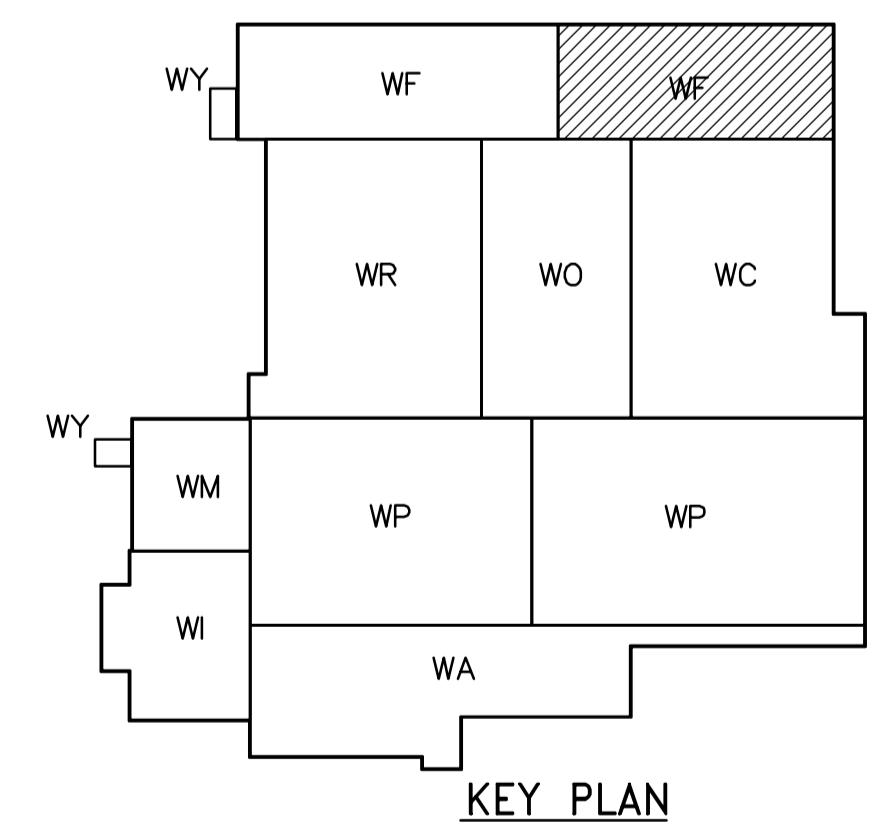

<p>APEGN Certificate of Authorization CH2M HILL Canada Ltd. No. 1441 Expiry: April 30, 2006</p>	<p>Frederickson Cooper ARCHITECTS</p>	<p>EarthTech A Tyco International Ltd. Company</p>	ENGINEER'S SEAL	<p>THE CITY OF WINNIPEG WATER AND WASTE DEPARTMENT ENGINEERING DIVISION</p>		
			DESIGNED BY JT		CHECKED BY ND	ORIGINAL SIGNED BY L.D. LLEWELLYN
			DRAWN BY KJ		APPROVED BY AHL	2006/03/29
			SCALE: 1:100		RELEASED FOR CONSTRUCTION BY: R. SOROKOWSKI	CONSULTANT DRAWING NO. WF-E0104
00 ISSUED FOR TENDER 06/03/29 LL	NO. REVISIONS	DATE BY DATE 2005/07/13	DATE 2006/03/29	WATER TREATMENT PLANT FILTRATION MECHANICAL AND ELECTRICAL ELECTRICAL FILTRATION AREA 2 LOWER LEVEL PROCESS PLAN CITY FILE NUMBER SHEET OF CITY DRAWING NUMBER 1-0601F-A-E0104-001-000		