





- NOTES:
- SEE MCC 4A & 4B SINGLE LINE DIAGRAMS AND DISTRIBUTION PANEL SCHEDULE DP-F32 FOR 600V POWER DISTRIBUTION
  - SEE DWG WB-E0403 FOR FILTER WIRING DETAILS

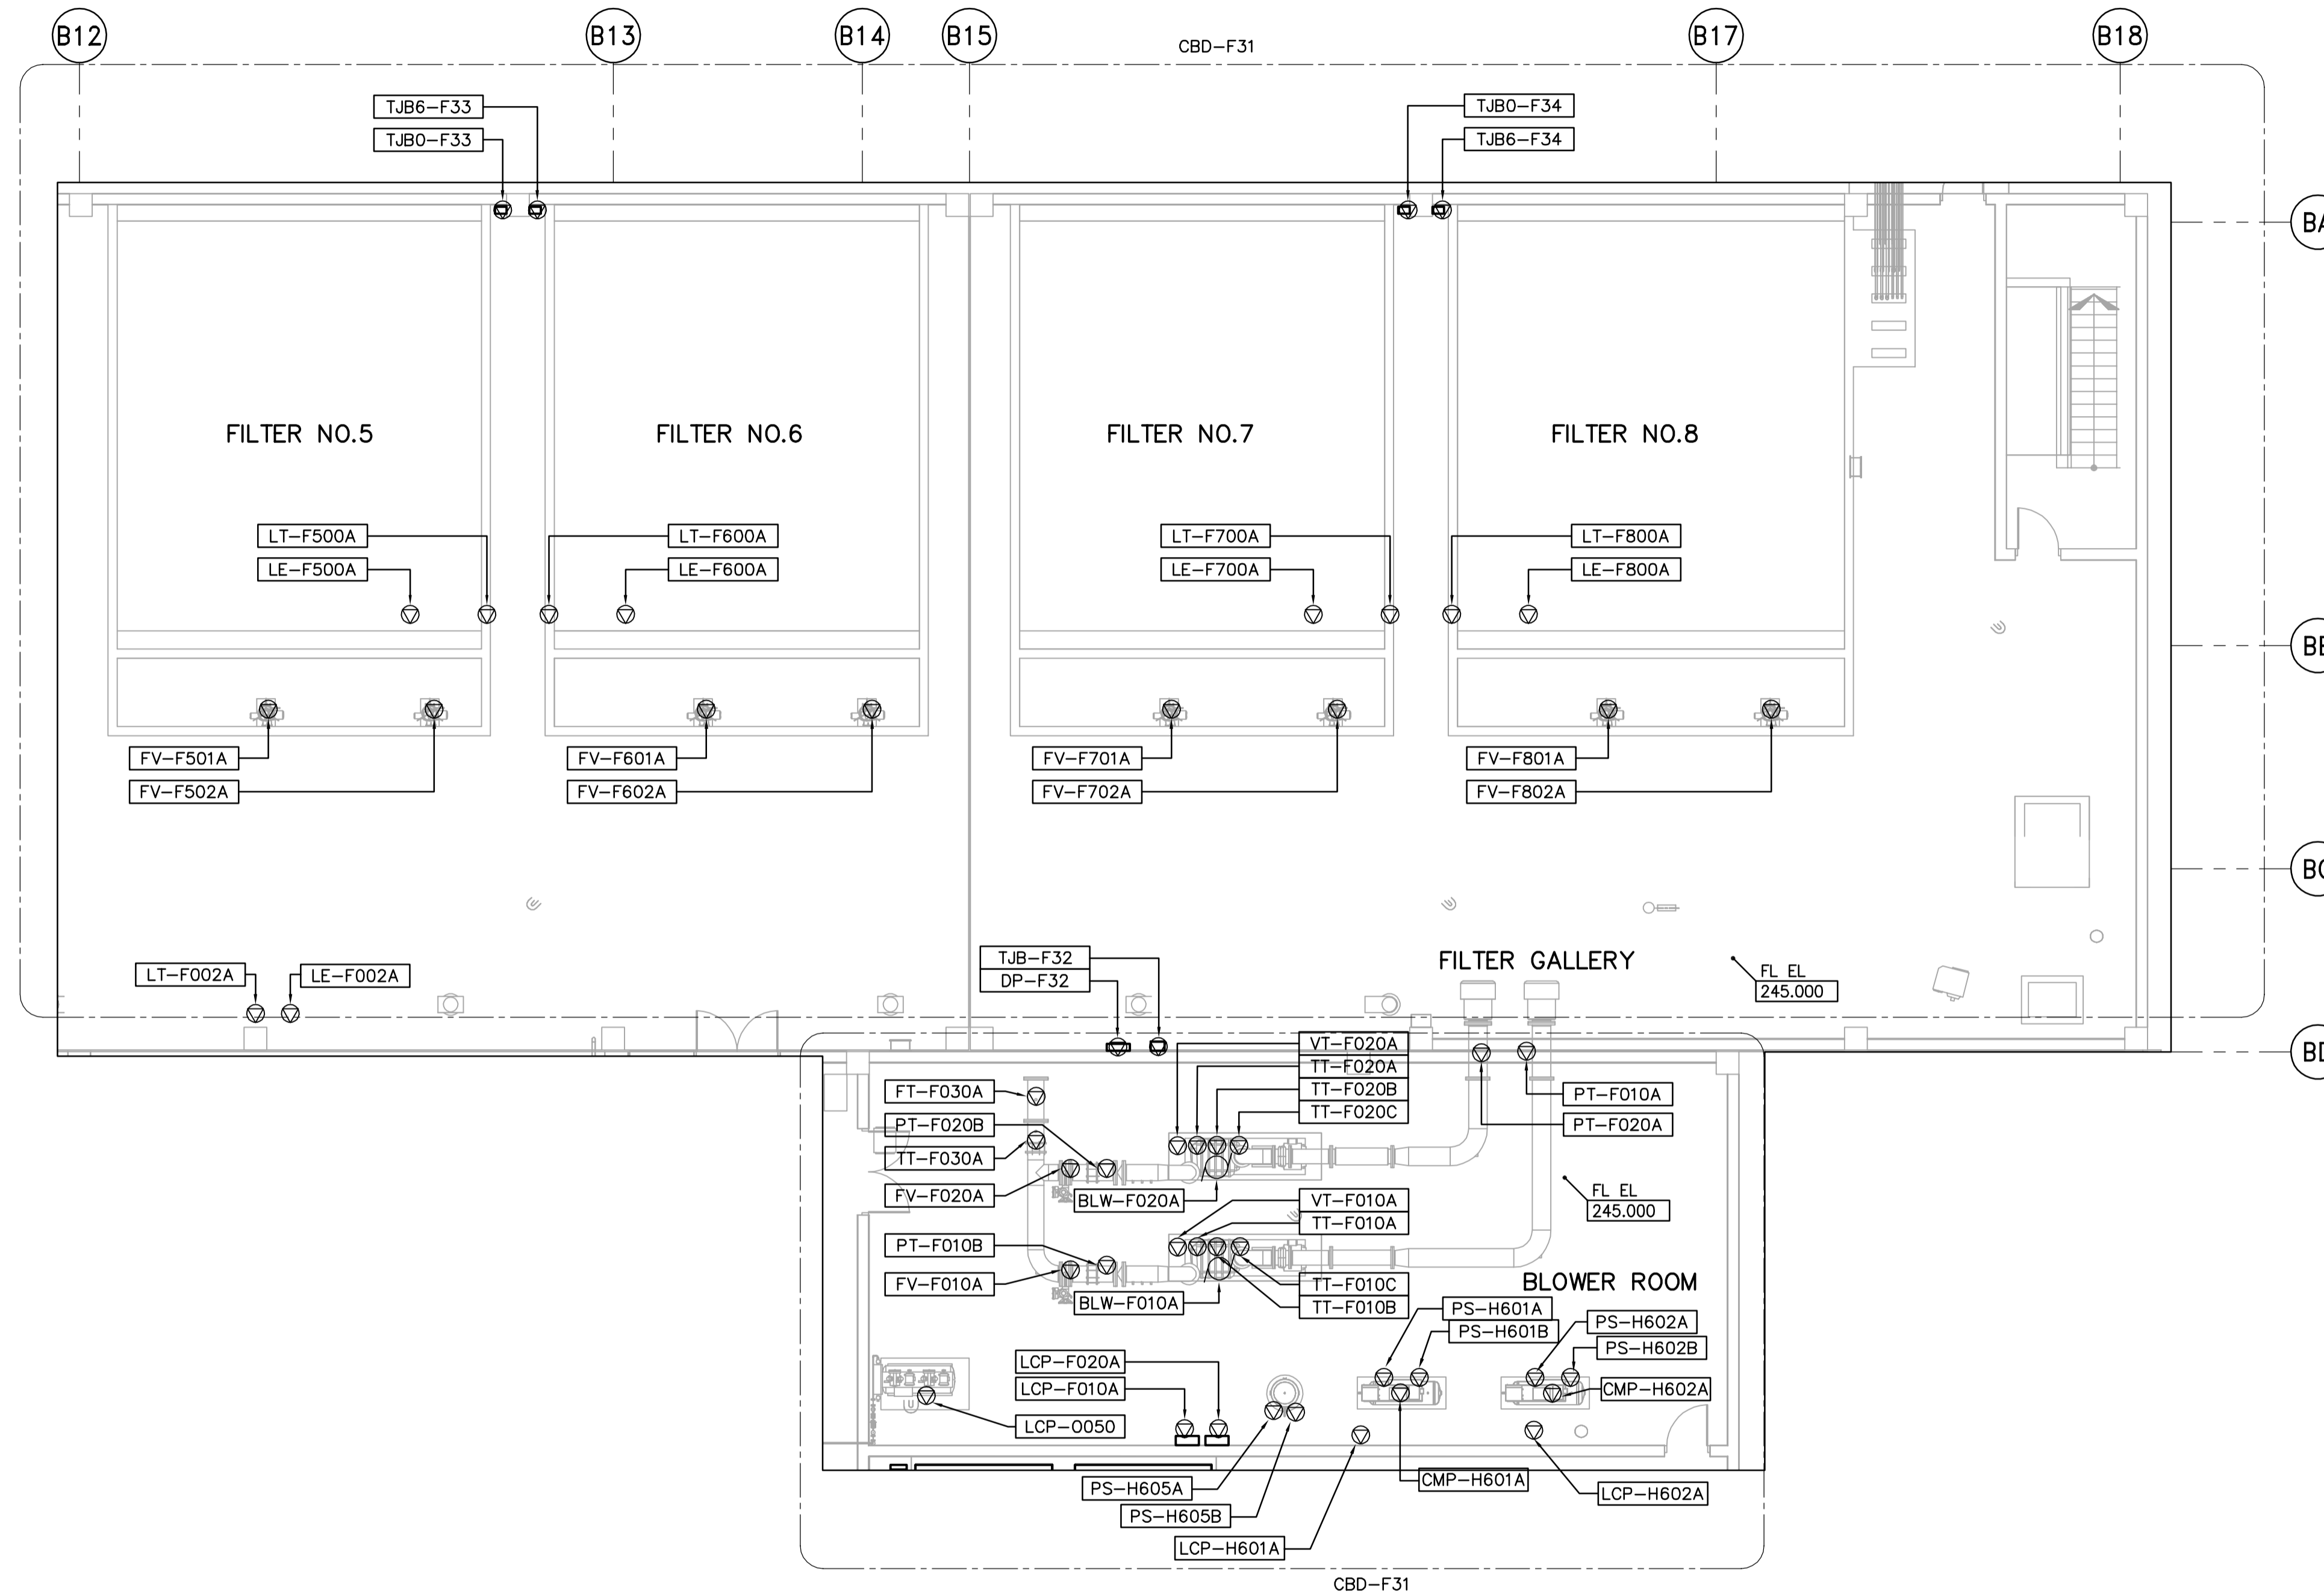

THIRD FLOOR PROCESS PLAN (AREA 2)  
1:100

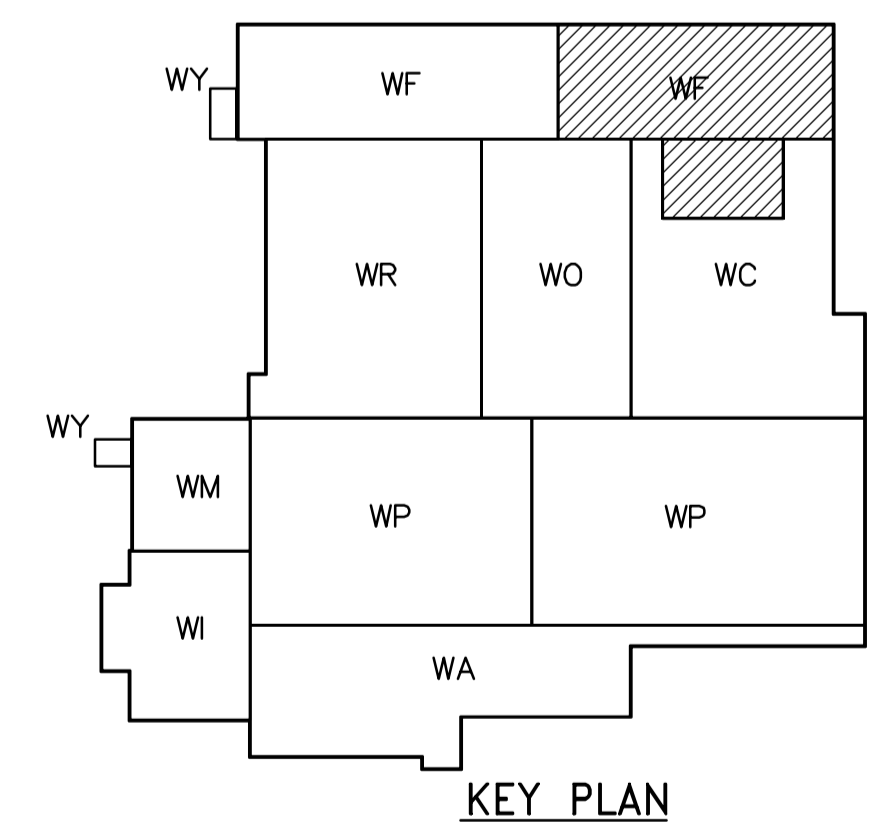

<p><b>APEGN</b> Certificate of Authorization CH2M HILL Canada Ltd. No. 1441 Expiry: April 30, 2006</p>	<p>Frederickson Cooper ARCHITECTS</p>	<p>EarthTech A Tyco International Ltd. Company</p>	ENGINEER'S SEAL	<p><b>THE CITY OF WINNIPEG</b> WATER AND WASTE DEPARTMENT ENGINEERING DIVISION</p>
			DESIGNED BY: LL CHECKED BY: ND DRAWN BY: PS APPROVED BY: AHL SCALE: 1:100 RELEASED FOR CONSTRUCTION BY: R. SOROKOWSKI DATE: 2006/03/29	
B.M. ELEV.			ELECTRICAL FILTRATION AREA 2 THIRD FLOOR PROCESS PLAN CITY DRAWING NUMBER: 1-0601F-A-E0134-001-000	
00 ISSUED FOR TENDER 06/03/29 LL NO. REVISIONS DATE BY		DATE: 2005/07/13 DATE: 2006/03/29		