
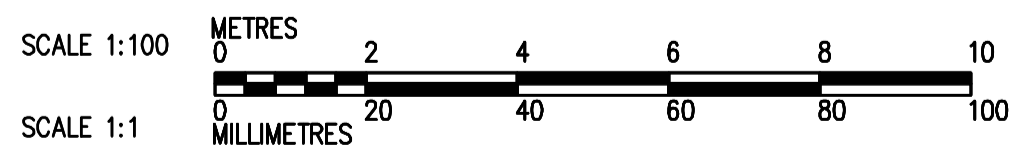


FIRST FLOOR PLAN
1:100

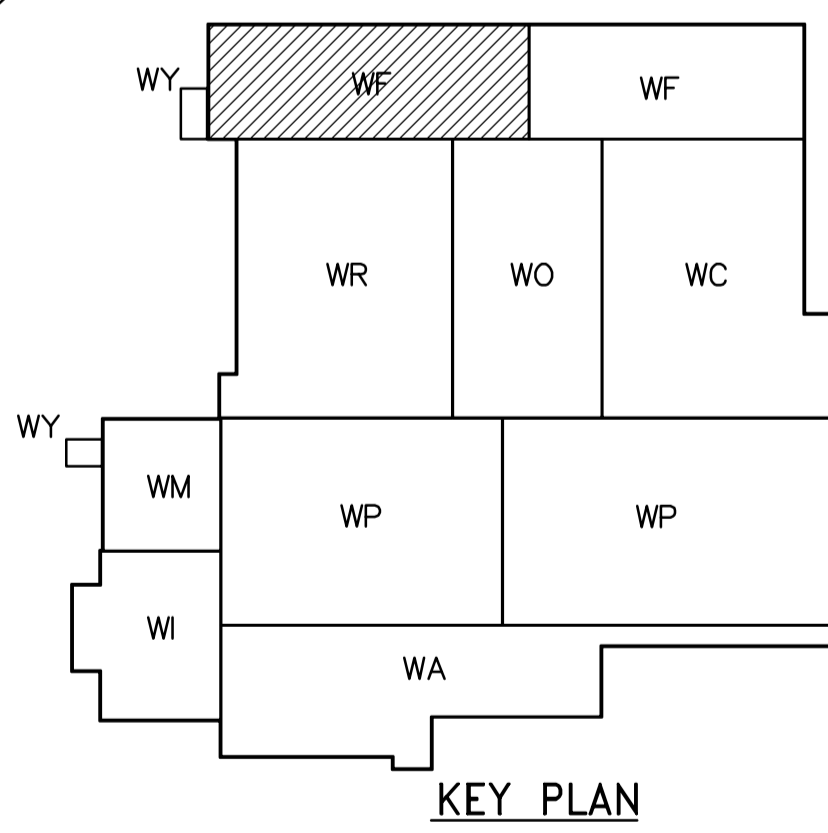

<p>Certificate of Authorization CH2M HILL Canada Ltd. No. 1441 Expiry: April 30, 2006</p>	<p>Frederickson Cooper ARCHITECTS</p>	<p>A Terra International Ltd. Company</p>	ENGINEER'S SEAL	<p>THE CITY OF WINNIPEG WATER AND WASTE DEPARTMENT ENGINEERING DIVISION</p>
			<p>DESIGNED BY: JZ/SW DRAWN BY: JMcP SCALE: 1:100</p>	
<p>00 ISSUED FOR TENDER 06/03/29 SW</p>	<p>DATE: 2005/08/02</p>	<p>DATE: 2006/03/29</p>	<p>CONSULTANT DRAWING NO.: WF-H0113</p>	<p>PLUMBING FILTRATION AREA 1 FIRST FLOOR PLAN</p>
				<p>CITY FILE NUMBER</p> <p>SHEET OF</p> <p>CITY DRAWING NUMBER 1-0601F-A-H0113-001-000</p>