


- NOTES:
1. PROVIDE FIRE DAMPER AT ALL DUCT PENETRATION THRU FLOOR.

THIRD FLOOR PLAN
1:100

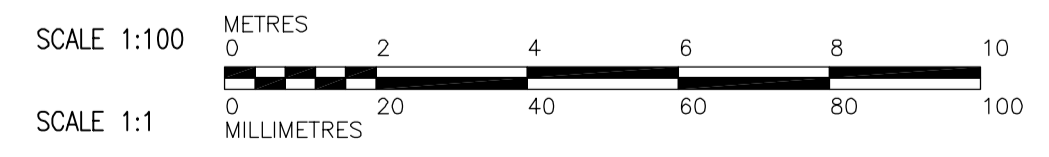

<p>APEGN Certificate of Authorization CH2M HILL Canada Ltd. No. 1441 Expiry: April 30, 2006</p>	<p>Frederickson Cooper ARCHITECTS</p>	<p>EarthTech A Tyco International Ltd. Company</p>	ENGINEER'S SEAL	<p>THE CITY OF WINNIPEG WATER AND WASTE DEPARTMENT ENGINEERING DIVISION</p>		
			DESIGNED BY TT		CHECKED BY DL	ORIGINAL SIGNED BY D.K. CUDDINGTON
			DRAWN BY AM		APPROVED BY AHL	2006/03/29
			SCALE: 1:100		RELEASED FOR CONSTRUCTION BY: R. SOROKOWSKI	CONSULTANT DRAWING NO. WF-H0131
00 ISSUED FOR TENDER	06/03/29 TT	2005/08/19	2006/03/29	<p>WATER TREATMENT PLANT FILTRATION MECHANICAL AND ELECTRICAL</p> <p>HVAC FILTRATION AREA 1 THIRD FLOOR PLAN</p>	<p>CITY FILE NUMBER</p> <p>SHEET OF</p> <p>CITY DRAWING NUMBER 1-0601F-A-H0131-001-000</p>	