
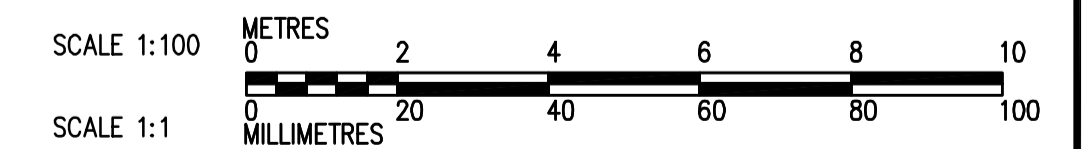


ROOF PLAN  
1:100

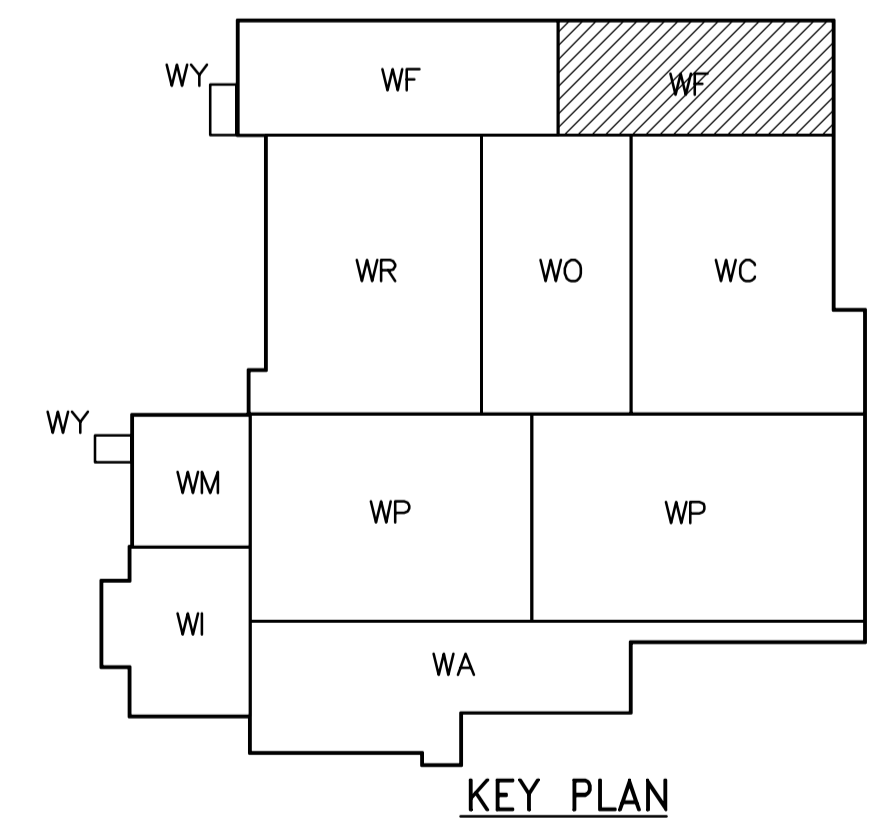

<p><b>APEGN</b> Certificate of Authorization CH2M HILL Canada Ltd. No. 1441 Expiry: April 30, 2006</p>	<p>Frederickson Cooper ARCHITECTS</p>	<p>A Geo International Ltd. Company</p>	ENGINEER'S SEAL ORIGINAL SIGNED BY D.K. CUDDINGTON 2006/03/29	<p><b>THE CITY OF WINNIPEG</b> WATER AND WASTE DEPARTMENT ENGINEERING DIVISION</p>
	DESIGNED BY: JZ/SW CHECKED BY: DL	DRAWN BY: JMcP APPROVED BY: AHL	CONSULTANT DRAWING NO. WF-H0144	
	SCALE: 1:100 RELEASED FOR CONSTRUCTION BY: R. SOROKOWSKI	DATE: 2005/08/02 DATE: 2006/03/29	WATER TREATMENT PLANT FILTRATION MECHANICAL AND ELECTRICAL	
	B.M. ELEV.	PLUMBING FILTRATION AREA 2 ROOF PLAN	CITY FILE NUMBER SHEET OF CITY DRAWING NUMBER 1-0601F-A-H0144-001-000	
00 ISSUED FOR TENDER 06/03/29 SW	NO. REVISIONS DATE BY			