
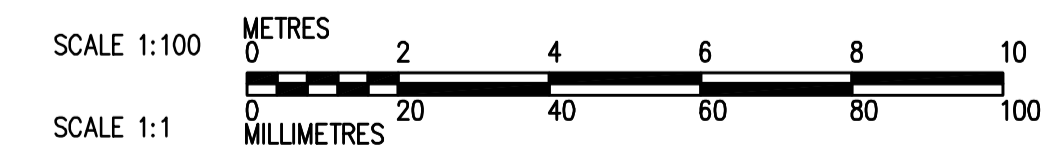


THIRD FLOOR PLAN  
1:100

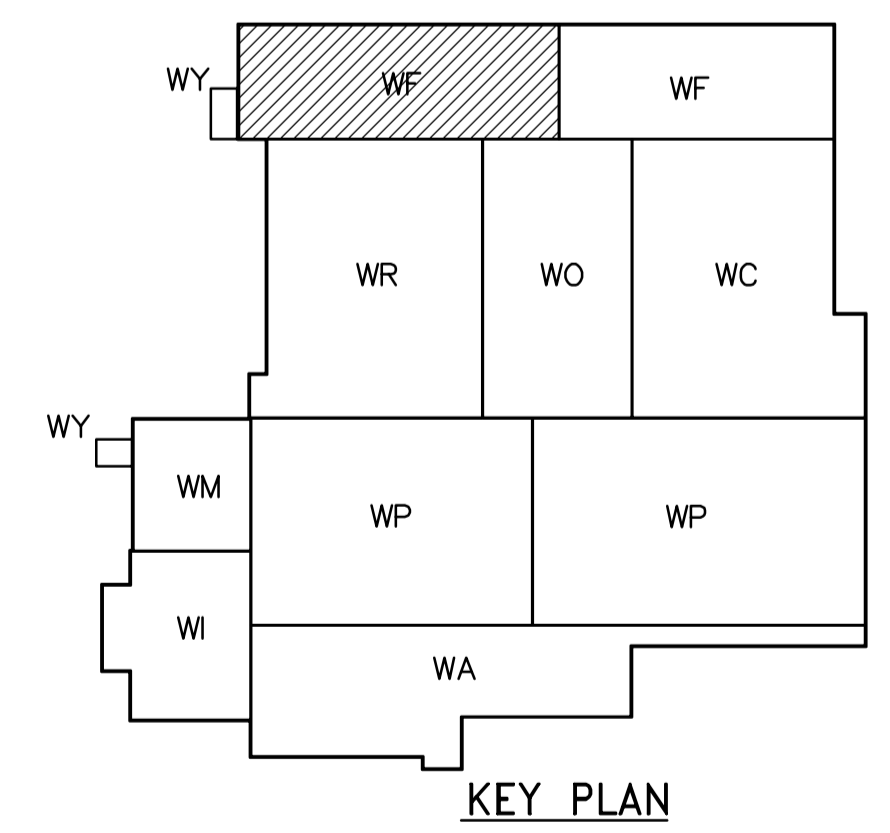

 <b>APEGN</b> Certificate of Authorization CH2M HILL Canada Ltd. No. 1441 Expiry: April 30, 2006	 Frederickson Cooper ARCHITECTS	 A Terra International Ltd. Company	ENGINEER'S SEAL	 <b>THE CITY OF WINNIPEG</b> WATER AND WASTE DEPARTMENT ENGINEERING DIVISION	CITY FILE NUMBER
			DESIGNED BY: JZ/SW CHECKED BY: DL DRAWN BY: JMcP APPROVED BY: DJT SCALE: 1:100 RELEASED FOR CONSTRUCTION BY: R. SOROKOWSKI		ORIGINAL SIGNED BY: D.K. CUDDINGTON DATE: 2006/02/06 CONSULTANT DRAWING NO.: WF-H9133
B.M. ELEV.		ISSUED FOR TENDER: 2006/02/03 SW NO. REVISIONS: DATE BY: DATE 2005/08/02 DATE 2006/02/08			