



PLAN AT EL 245.00
1:100

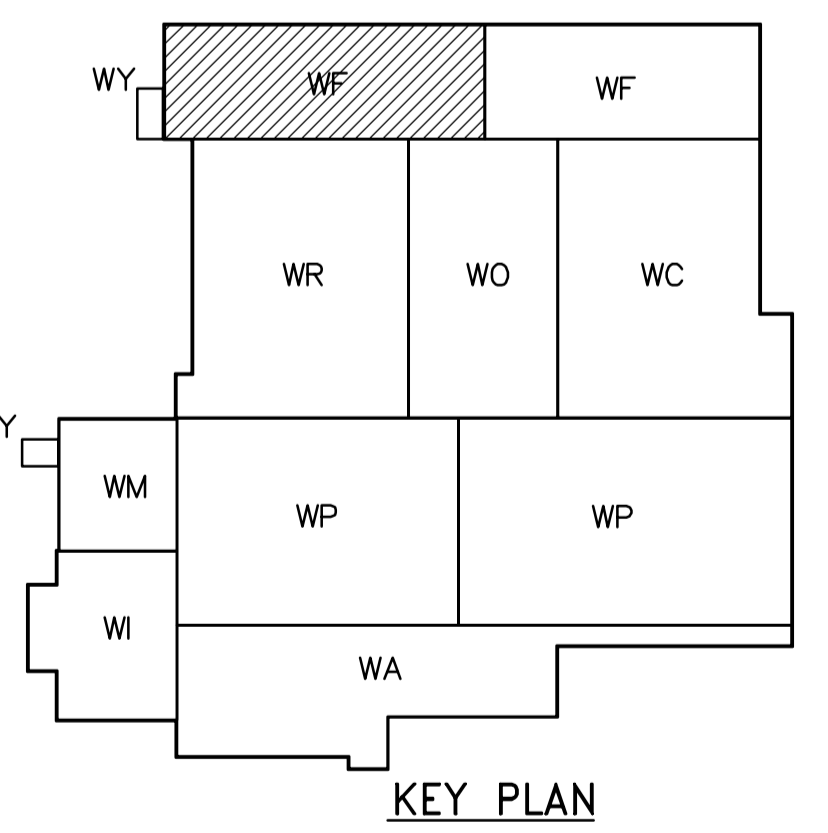

NOTES:
1. SUPPLY BY OTHERS, INSTALLATION BY CONTRACTOR.

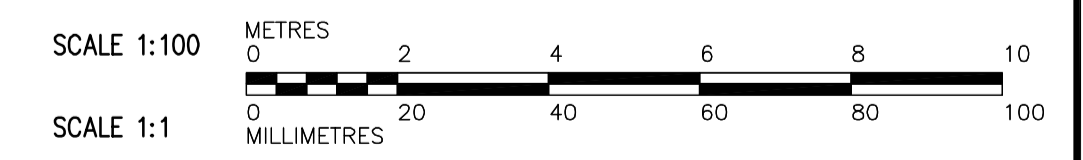

 Certificate of Authorization CH2M HILL Canada Ltd. No. 1441 Expiry: April 30, 2006	B.M. ELEV. <table border="1"> <tr><td> </td><td> </td><td> </td></tr> <tr><td> </td><td> </td><td> </td></tr> <tr><td> </td><td> </td><td> </td></tr> <tr><td> </td><td> </td><td> </td></tr> </table>													 Frederickson Cooper ARCHITECTS DESIGNED BY TB DRAWN BY TAR/EK SCALE: 1:100 00 ISSUED FOR TENDER 06/03/29 TB NO. REVISIONS DATE BY DATE 2005/07/08	 ENGINEER'S SEAL ORIGINAL SIGNED BY P. WOBMA 2006/03/29 CONSULTANT DRAWING NO. WF-M0131 CHECKED BY LS APPROVED BY AHL RELEASED FOR CONSTRUCTION BY: R. SOROKOWSKI DATE 2006/03/29	 THE CITY OF WINNIPEG WATER AND WASTE DEPARTMENT ENGINEERING DIVISION WATER TREATMENT PLANT FILTRATION MECHANICAL AND ELECTRICAL PROCESS MECHANICAL FILTRATION AREA 1 THIRD FLOOR PLAN	CITY FILE NUMBER SHEET OF
CITY DRAWING NUMBER 1-0601F-A-M0131-001-000																	
CITY FILE NUMBER SHEET OF																	
CITY DRAWING NUMBER 1-0601F-A-M0131-001-000																	