

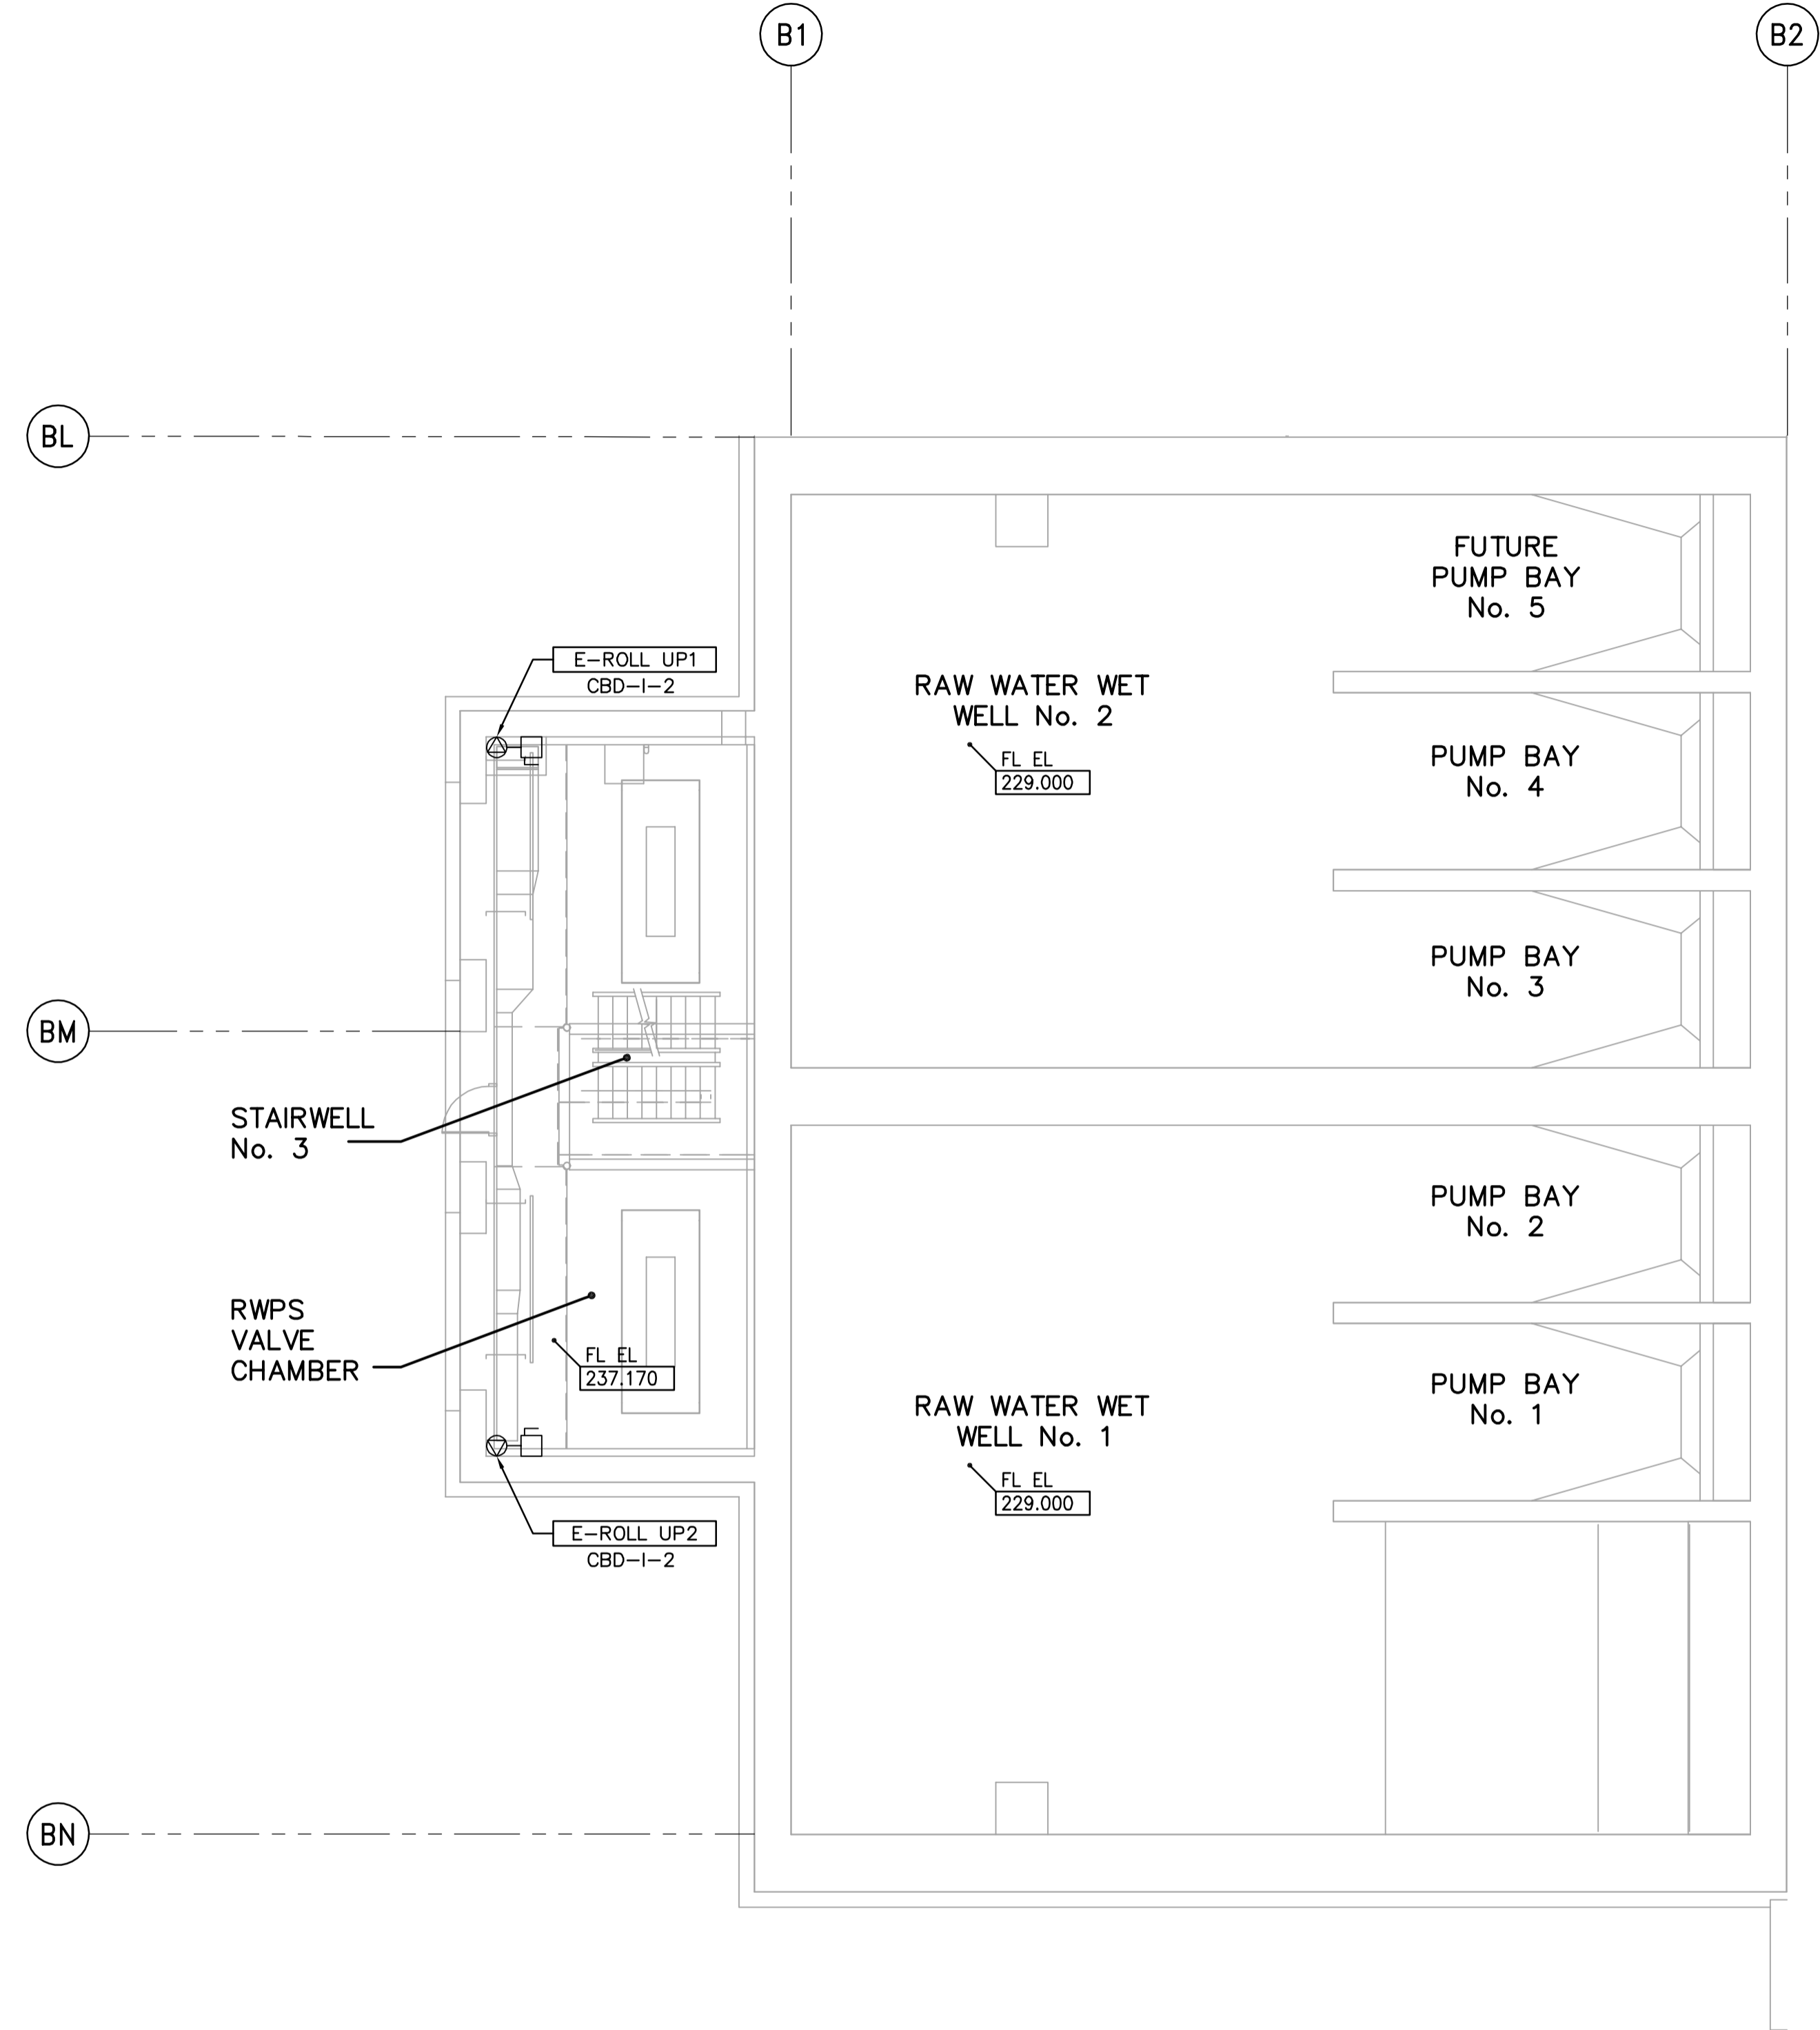


NOTE:
1. SEE MCC #1A & #1B SINGLE LINE DIAGRAM FOR 600V POWER DISTRIBUTION.

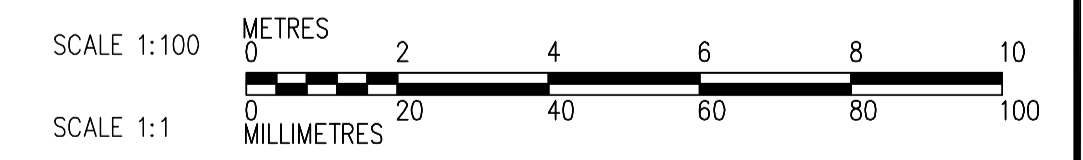

FIRST FLOOR FACILITY PLAN
1:100

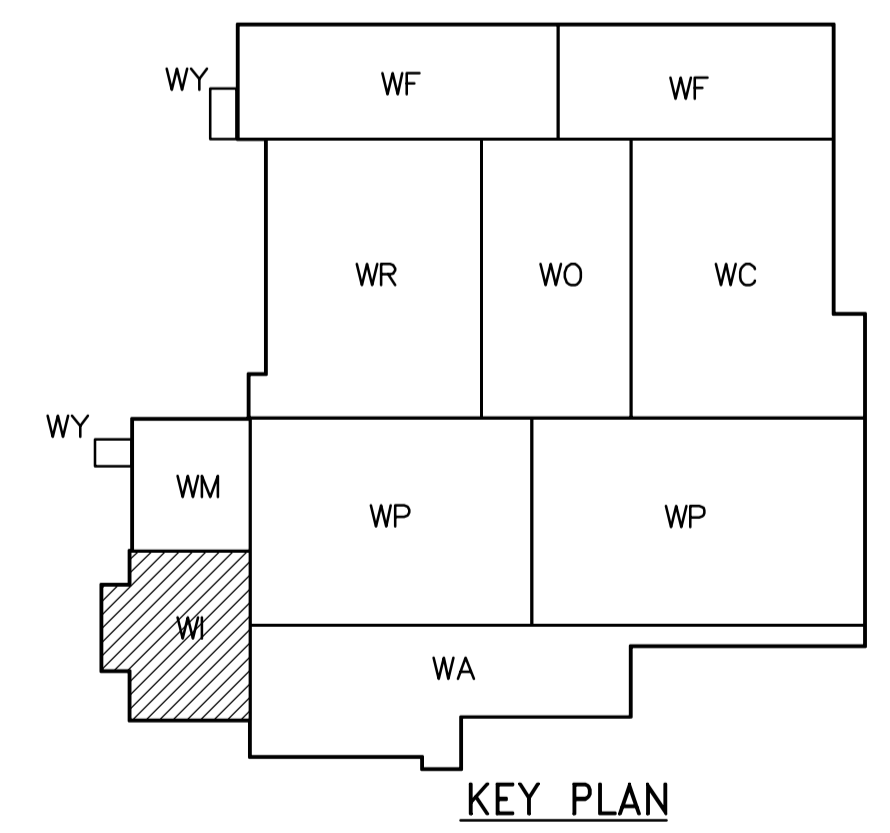

<p>APEGN Certificate of Authorization CH2M HILL Canada Ltd. No. 1441 Expiry: April 30, 2006</p>	<p>Frederickson Cooper ARCHITECTS</p>	<p>A Geo International Ltd. Company</p>	ENGINEER'S SEAL	<p>THE CITY OF WINNIPEG WATER AND WASTE DEPARTMENT ENGINEERING DIVISION</p>	CITY FILE NUMBER
			DESIGNED BY: JT CHECKED BY: ND DRAWN BY: KJ APPROVED BY: AHL SCALE: 1:100 RELEASED FOR CONSTRUCTION BY: R. SOROKOWSKI		ORIGINAL SIGNED BY: L.D. LLEWELLYN DATE: 2006/03/29 CONSULTANT DRAWING NO.: WI-E0111
B.M. ELEV.		NO. REVISIONS DATE BY		DATE 2005/07/13 DATE 2006/03/29	
00 ISSUED FOR TENDER 06/03/29 LL					