





- NOTES:**
1. SEE MCC #1A & #1B SINGLE LINE DIAGRAM FOR 600V POWER DISTRIBUTION.
 2. SEE LP-M11 FOR 120/208V POWER DISTRIBUTION.

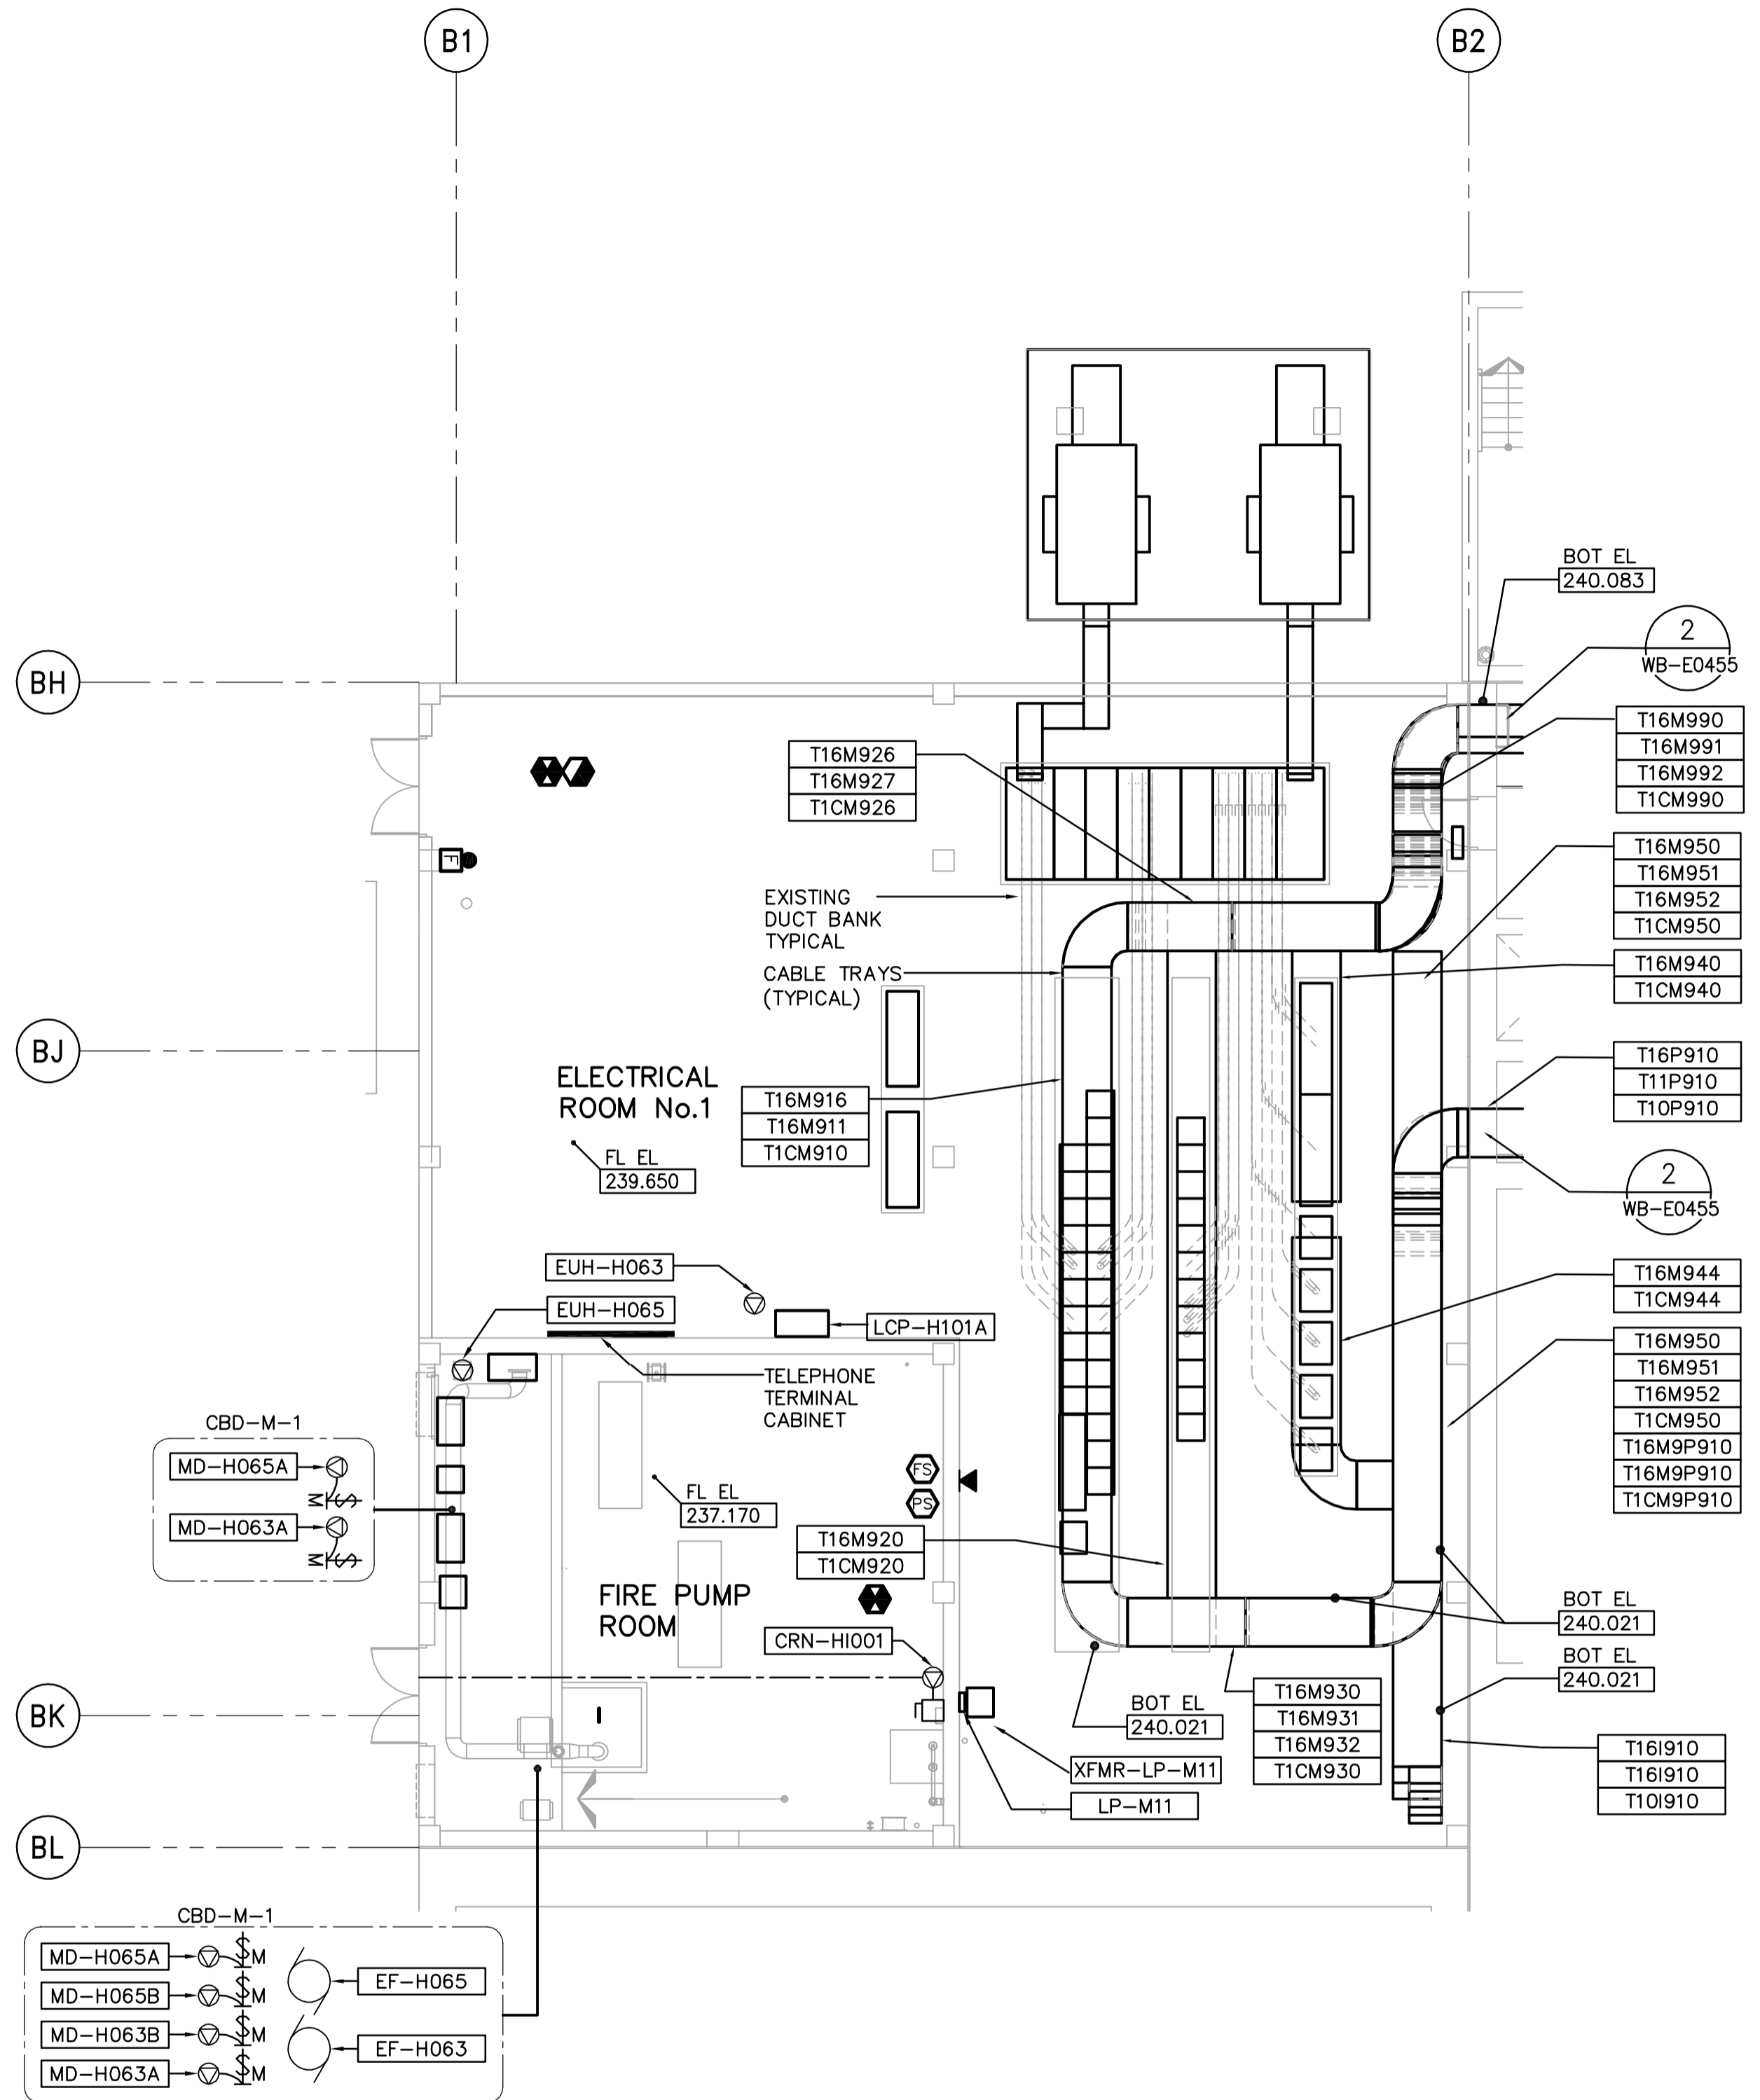

CABLE TRAY TAGGING
SEE DETAIL

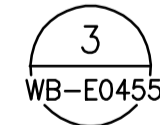

FIRST FLOOR FACILITY PLAN
1:100

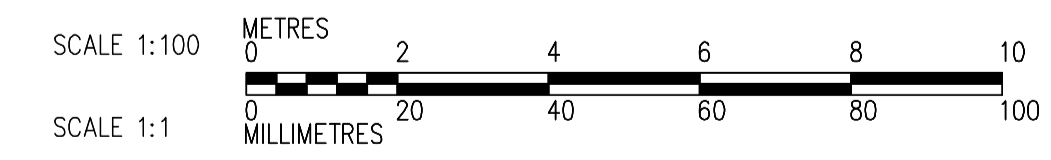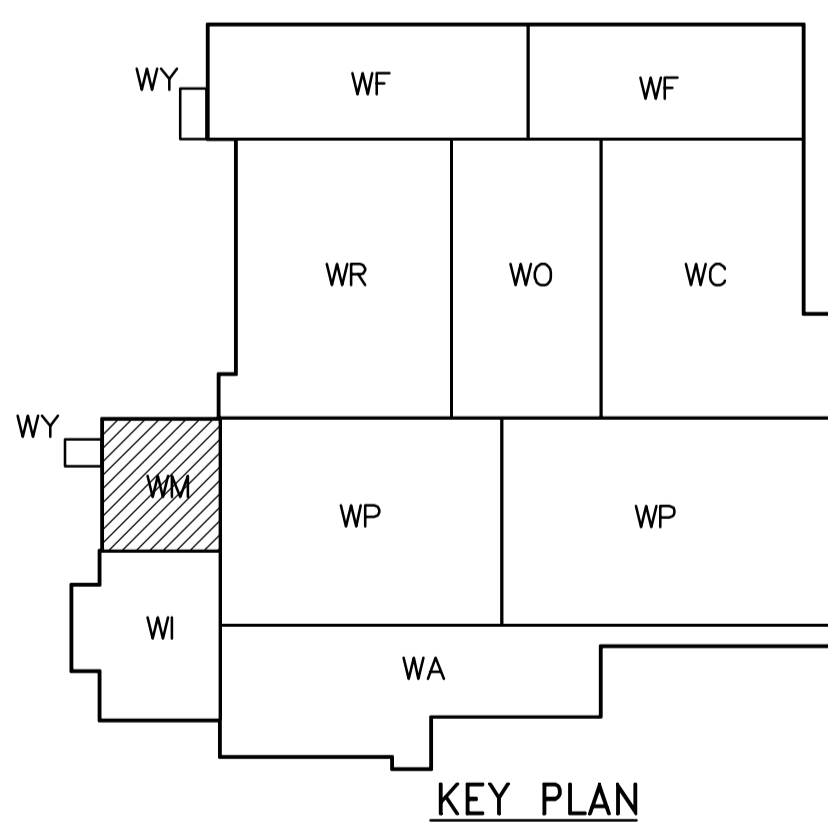

<p>APEGN Certificate of Authorization CH2M HILL Canada Ltd. No. 1441 Expiry: April 30, 2006</p>	<p>Frederickson Cooper ARCHITECTS</p>	<p>EarthTech A 3M International Ltd. Company</p>	ENGINEER'S SEAL	<p>THE CITY OF WINNIPEG WATER AND WASTE DEPARTMENT ENGINEERING DIVISION</p>
			<p>DESIGNED BY: JT</p> <p>CHECKED BY: ND</p> <p>DRAWN BY: KJ</p> <p>APPROVED BY: AHL</p> <p>SCALE: 1:100</p> <p>RELEASED FOR CONSTRUCTION BY: R. SOROKOWSKI</p>	
<p>00 ISSUED FOR TENDER 06/03/29 LL</p>			<p>CONSULTANT DRAWING NO. WM-E0111</p>	<p>CITY FILE NUMBER</p>
<p>NO. REVISIONS DATE BY DATE 2005/06/30 DATE 2006/03/29</p>			<p>ELECTRICAL ELECTRICAL ROOM AREA FIRST FLOOR FACILITY PLAN</p>	<p>SHEET OF</p> <p>CITY DRAWING NUMBER 1-0601M-A-E0111-001-000</p>